




FRONT ELEVATION

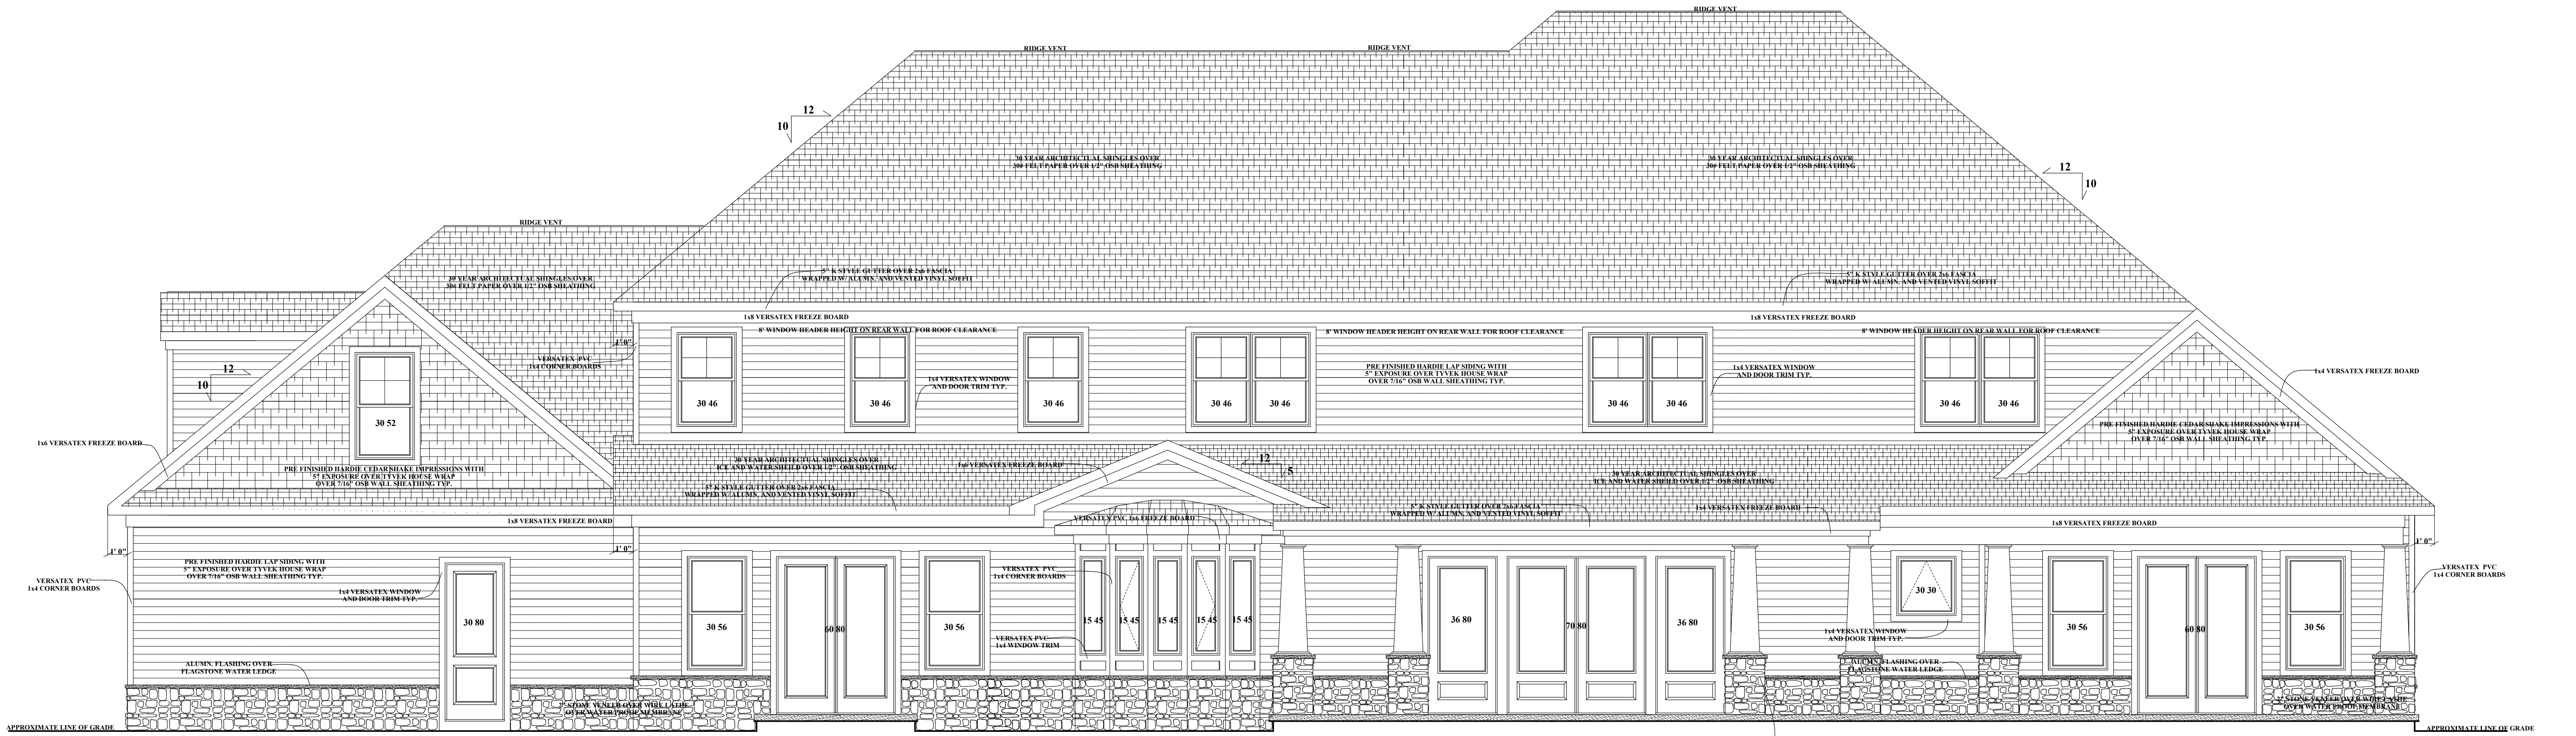

REAR ELEVATION

THE CONTRACTOR IS RESPONSIBLE FOR DIMENSIONS TO BE CONFIRMED AND CORRELATED AT SITE FOR INFORMATION THAT PERTAINS SOLELY TO THE FABRICATION PROCESSES OR TO THE MEASUREMENTS, TECHNIQUES, SEQUENCES, AND PROCEDURES OF CONSTRUCTION OF THE WORK OF ALL TRADES

RB HOME DESIGNS

DATE :


SCALE : 1/4" = 1'

DRAWN :
R. BREDLOW


FRONT / REAR ELEVATION

SHEET NO.

A-1

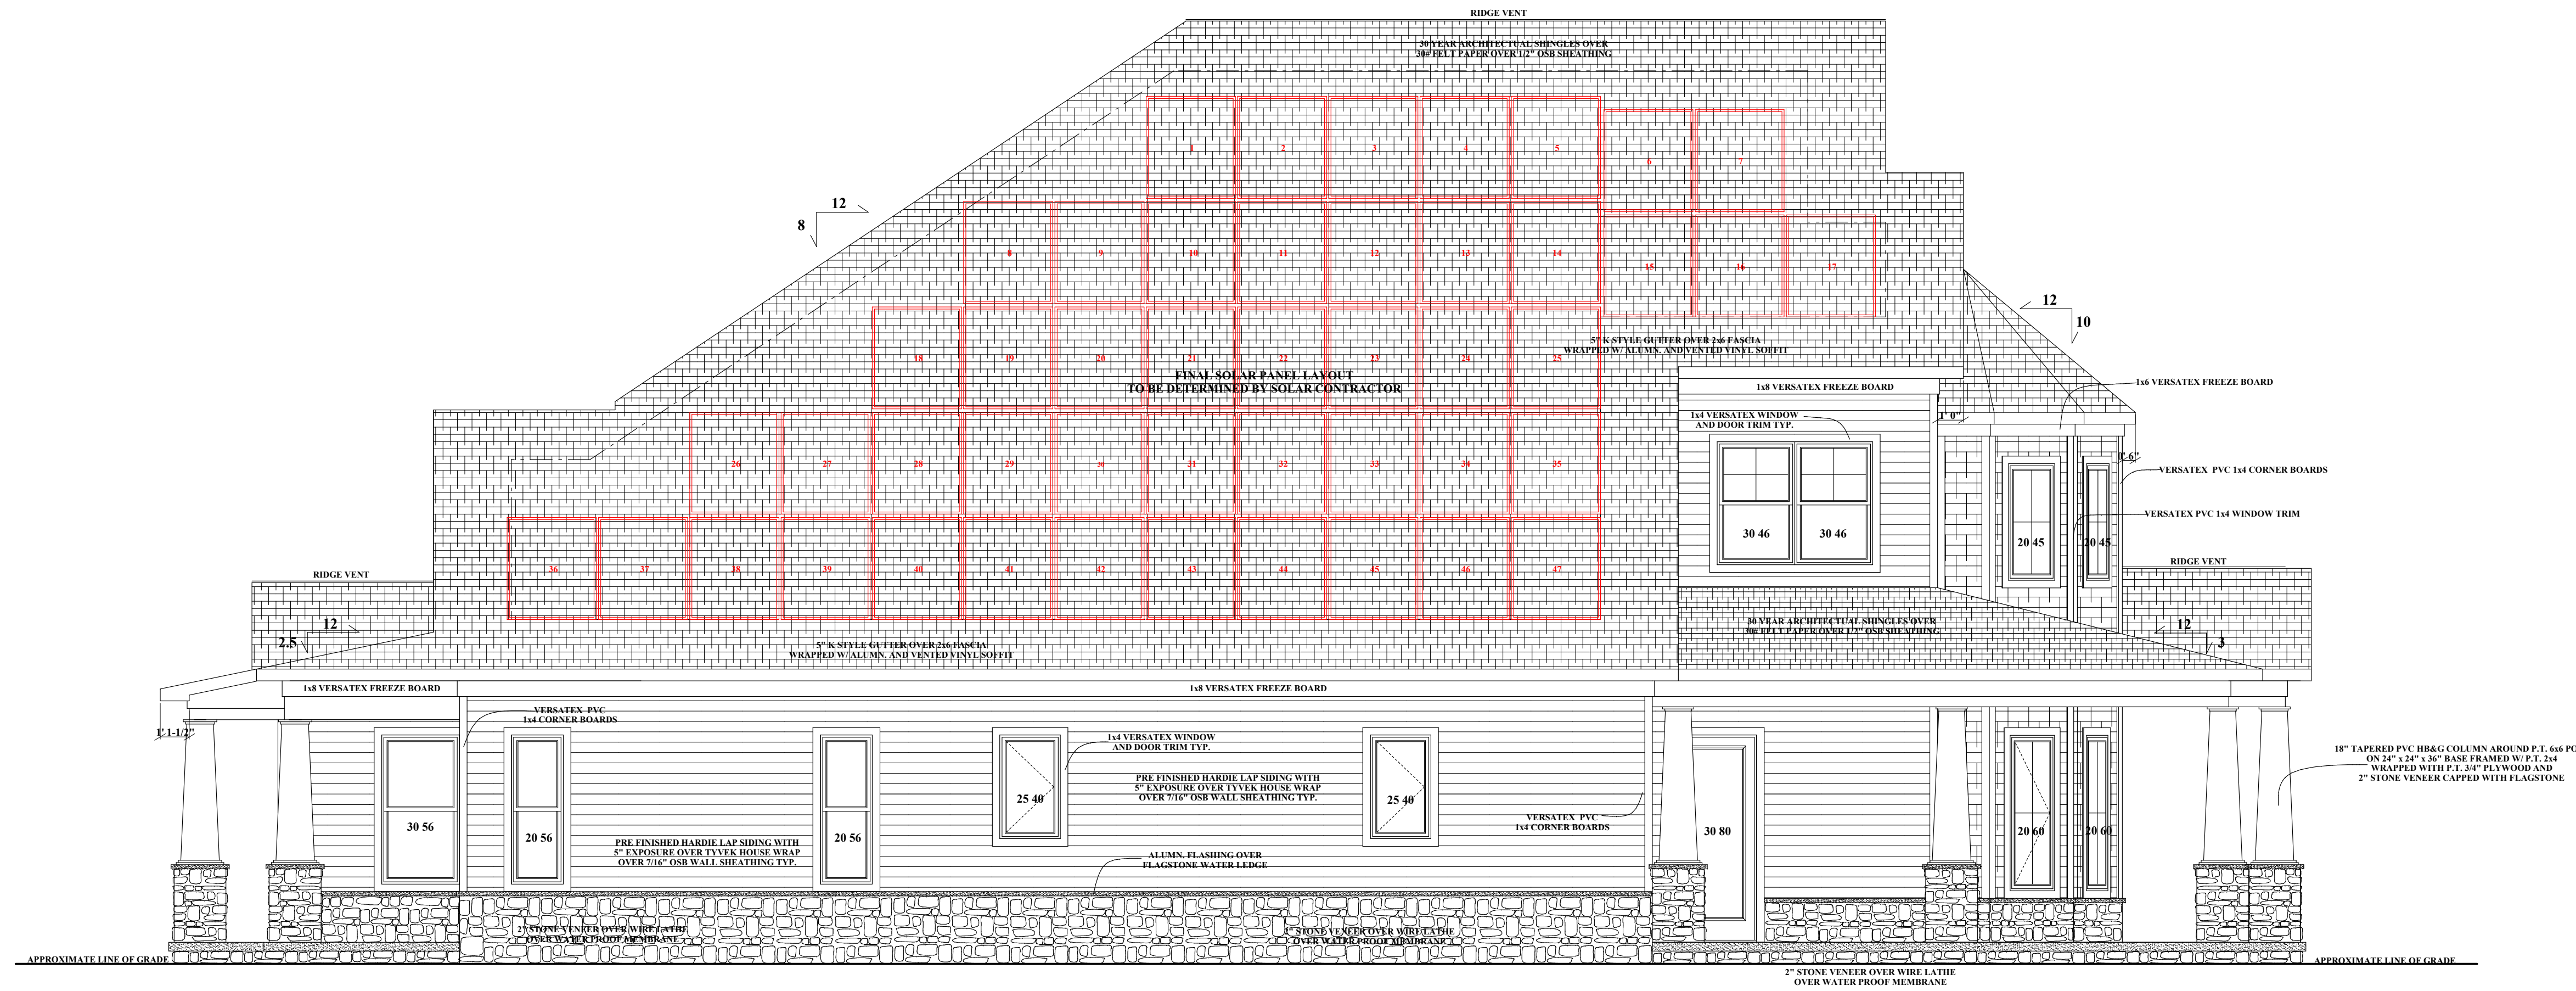

LEFT ELEVATION

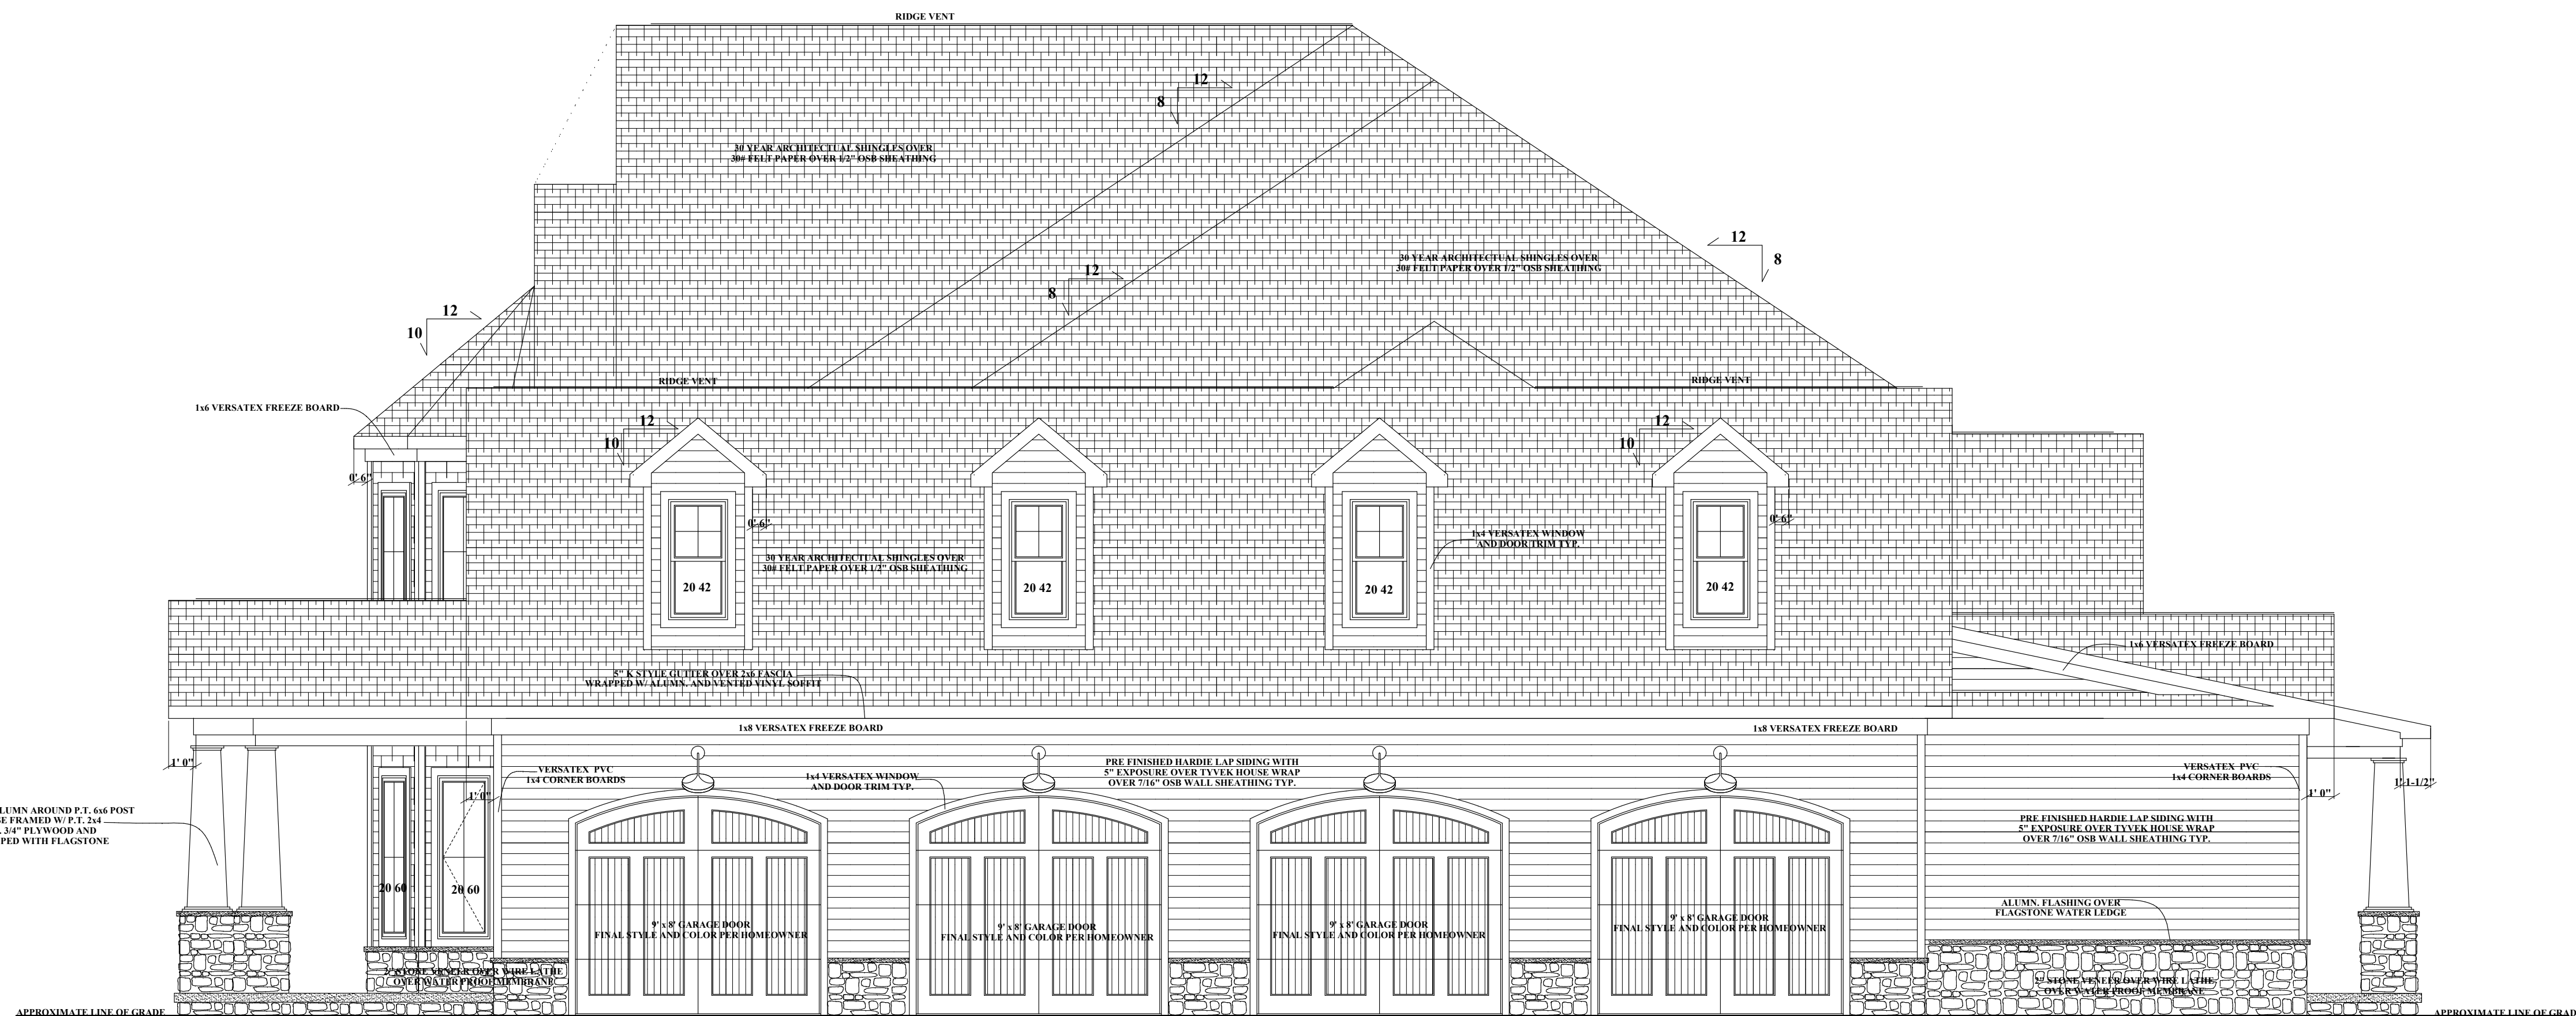

RIGHT ELEVATION

THE CONTRACTOR IS RESPONSIBLE FOR DIMENSIONS TO BE CONFIRMED AND CORRELATED AT SITE FOR INFORMATION THAT PERTAINS SOLELY TO THE FABRICATION PROCESSES OR TO THE MEASUREMENTS, METHODS, TECHNIQUES, SEQUENCES, AND PROCEDURES OF CONSTRUCTION OF THE WORK OF ALL TRADES

RB HOME DESIGNS

DATE :


SCALE : 1/4" = 1'

DRAWN : R. BREDLOW

LEFT/ RIGHT ELEVATION

SHEET NO.

A-2

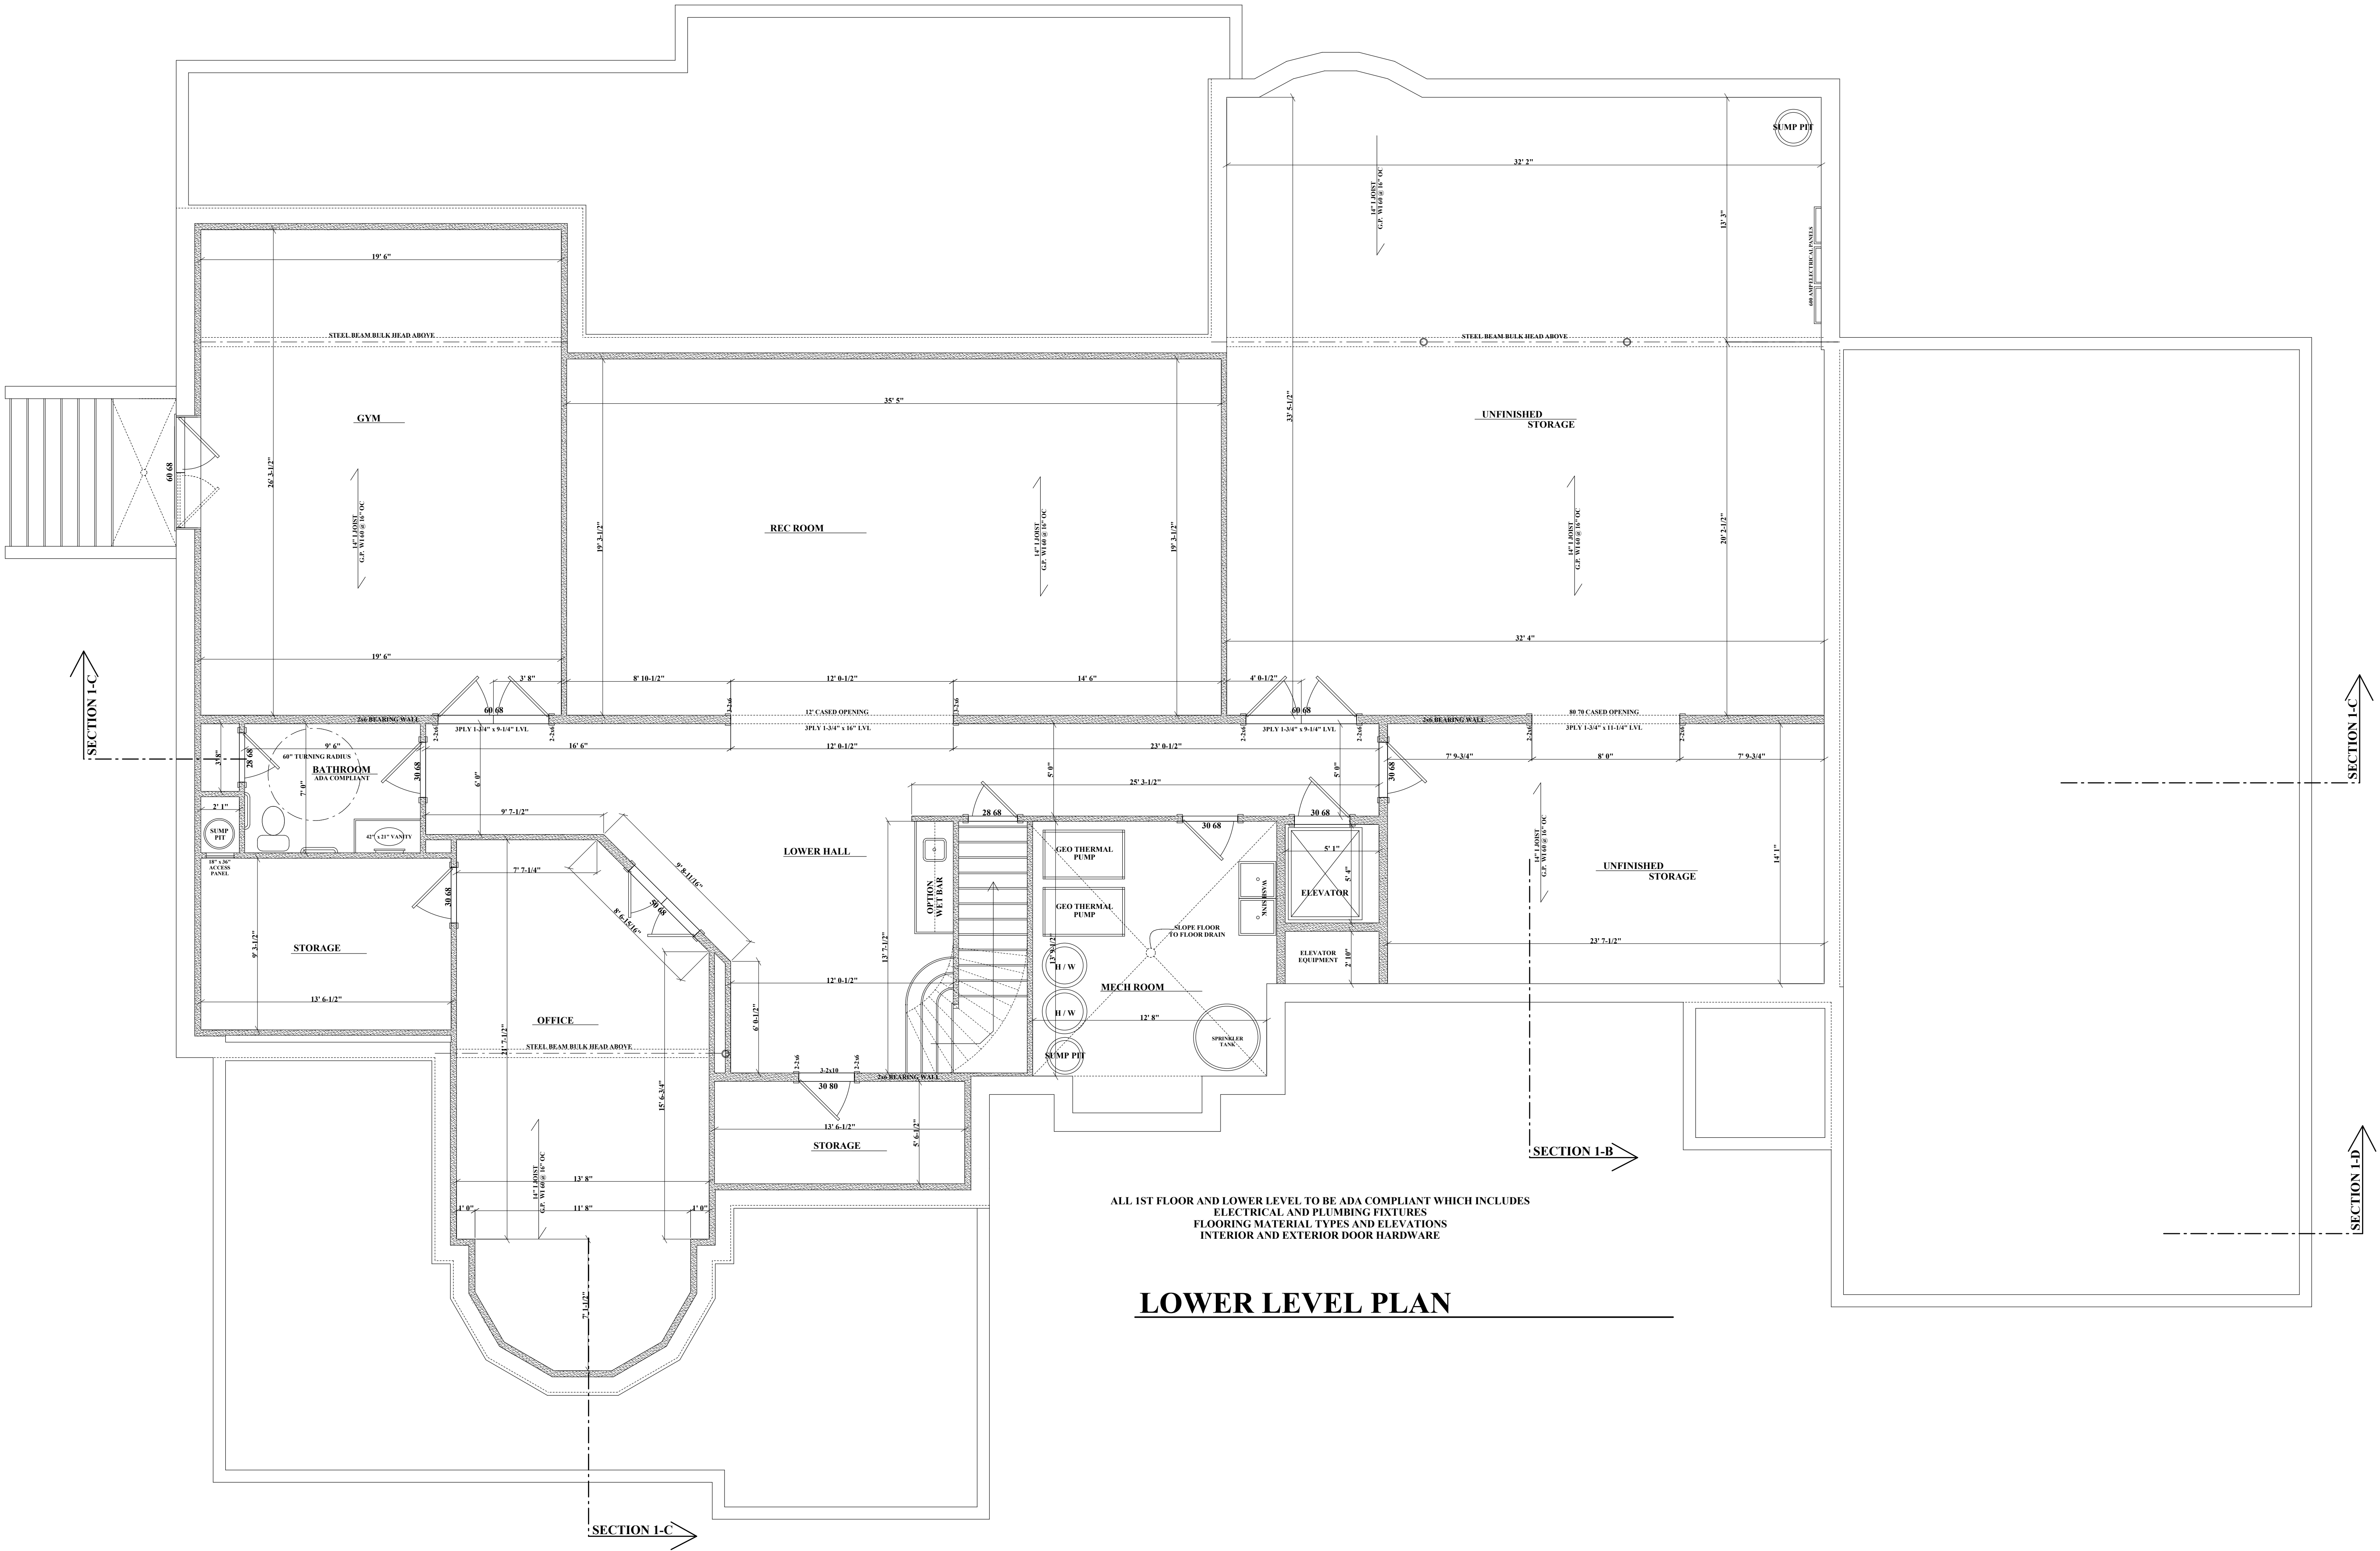

ALL 1ST FLOOR AND LOWER LEVEL TO BE ADA COMPLIANT WHICH INCLUDES ELECTRICAL AND PLUMBING FIXTURES FLOORING MATERIAL TYPES AND ELEVATIONS INTERIOR AND EXTERIOR DOOR HARDWARE

LOWER LEVEL PLAN

THE CONTRACTOR IS RESPONSIBLE FOR DIMENSIONS TO BE CONFIRMED AND CORRELATED AT SITE FOR INFORMATION THAT PERTAINS SOLELY TO THE FABRICATION PROCESSES OR TO THE MEANS, METHODS, TECHNIQUES, SEQUENCES, AND PROCEDURES OF CONSTRUCTION OF THE WORK OF ALL TRADES

RB HOME DESIGNS

DATE :

SCALE : 1/4" = 1'

DRAWN : R. BREDLOW

LOWER LEVEL PLAN

SHEET NO.

A-4

THE CONTRACTOR IS RESPONSIBLE FOR DIMENSIONS TO BE CONFIRMED AND CORRELATED AT SITE FOR INFORMATION THAT PERTAINS SOLELY TO THE FABRICATION PROCESSES OR TO THE MEASUREMENTS, METHODS, TECHNIQUES, SEQUENCES, AND PROCEDURES OF CONSTRUCTION OF THE WORK OF ALL TRADES

RB HOME DESIGNS

DATE :

SCALE : 1/4" = 1'


DRAWN :

R. BREDLOW

1ST FLOOR PLAN

SHEET NO.

A-5

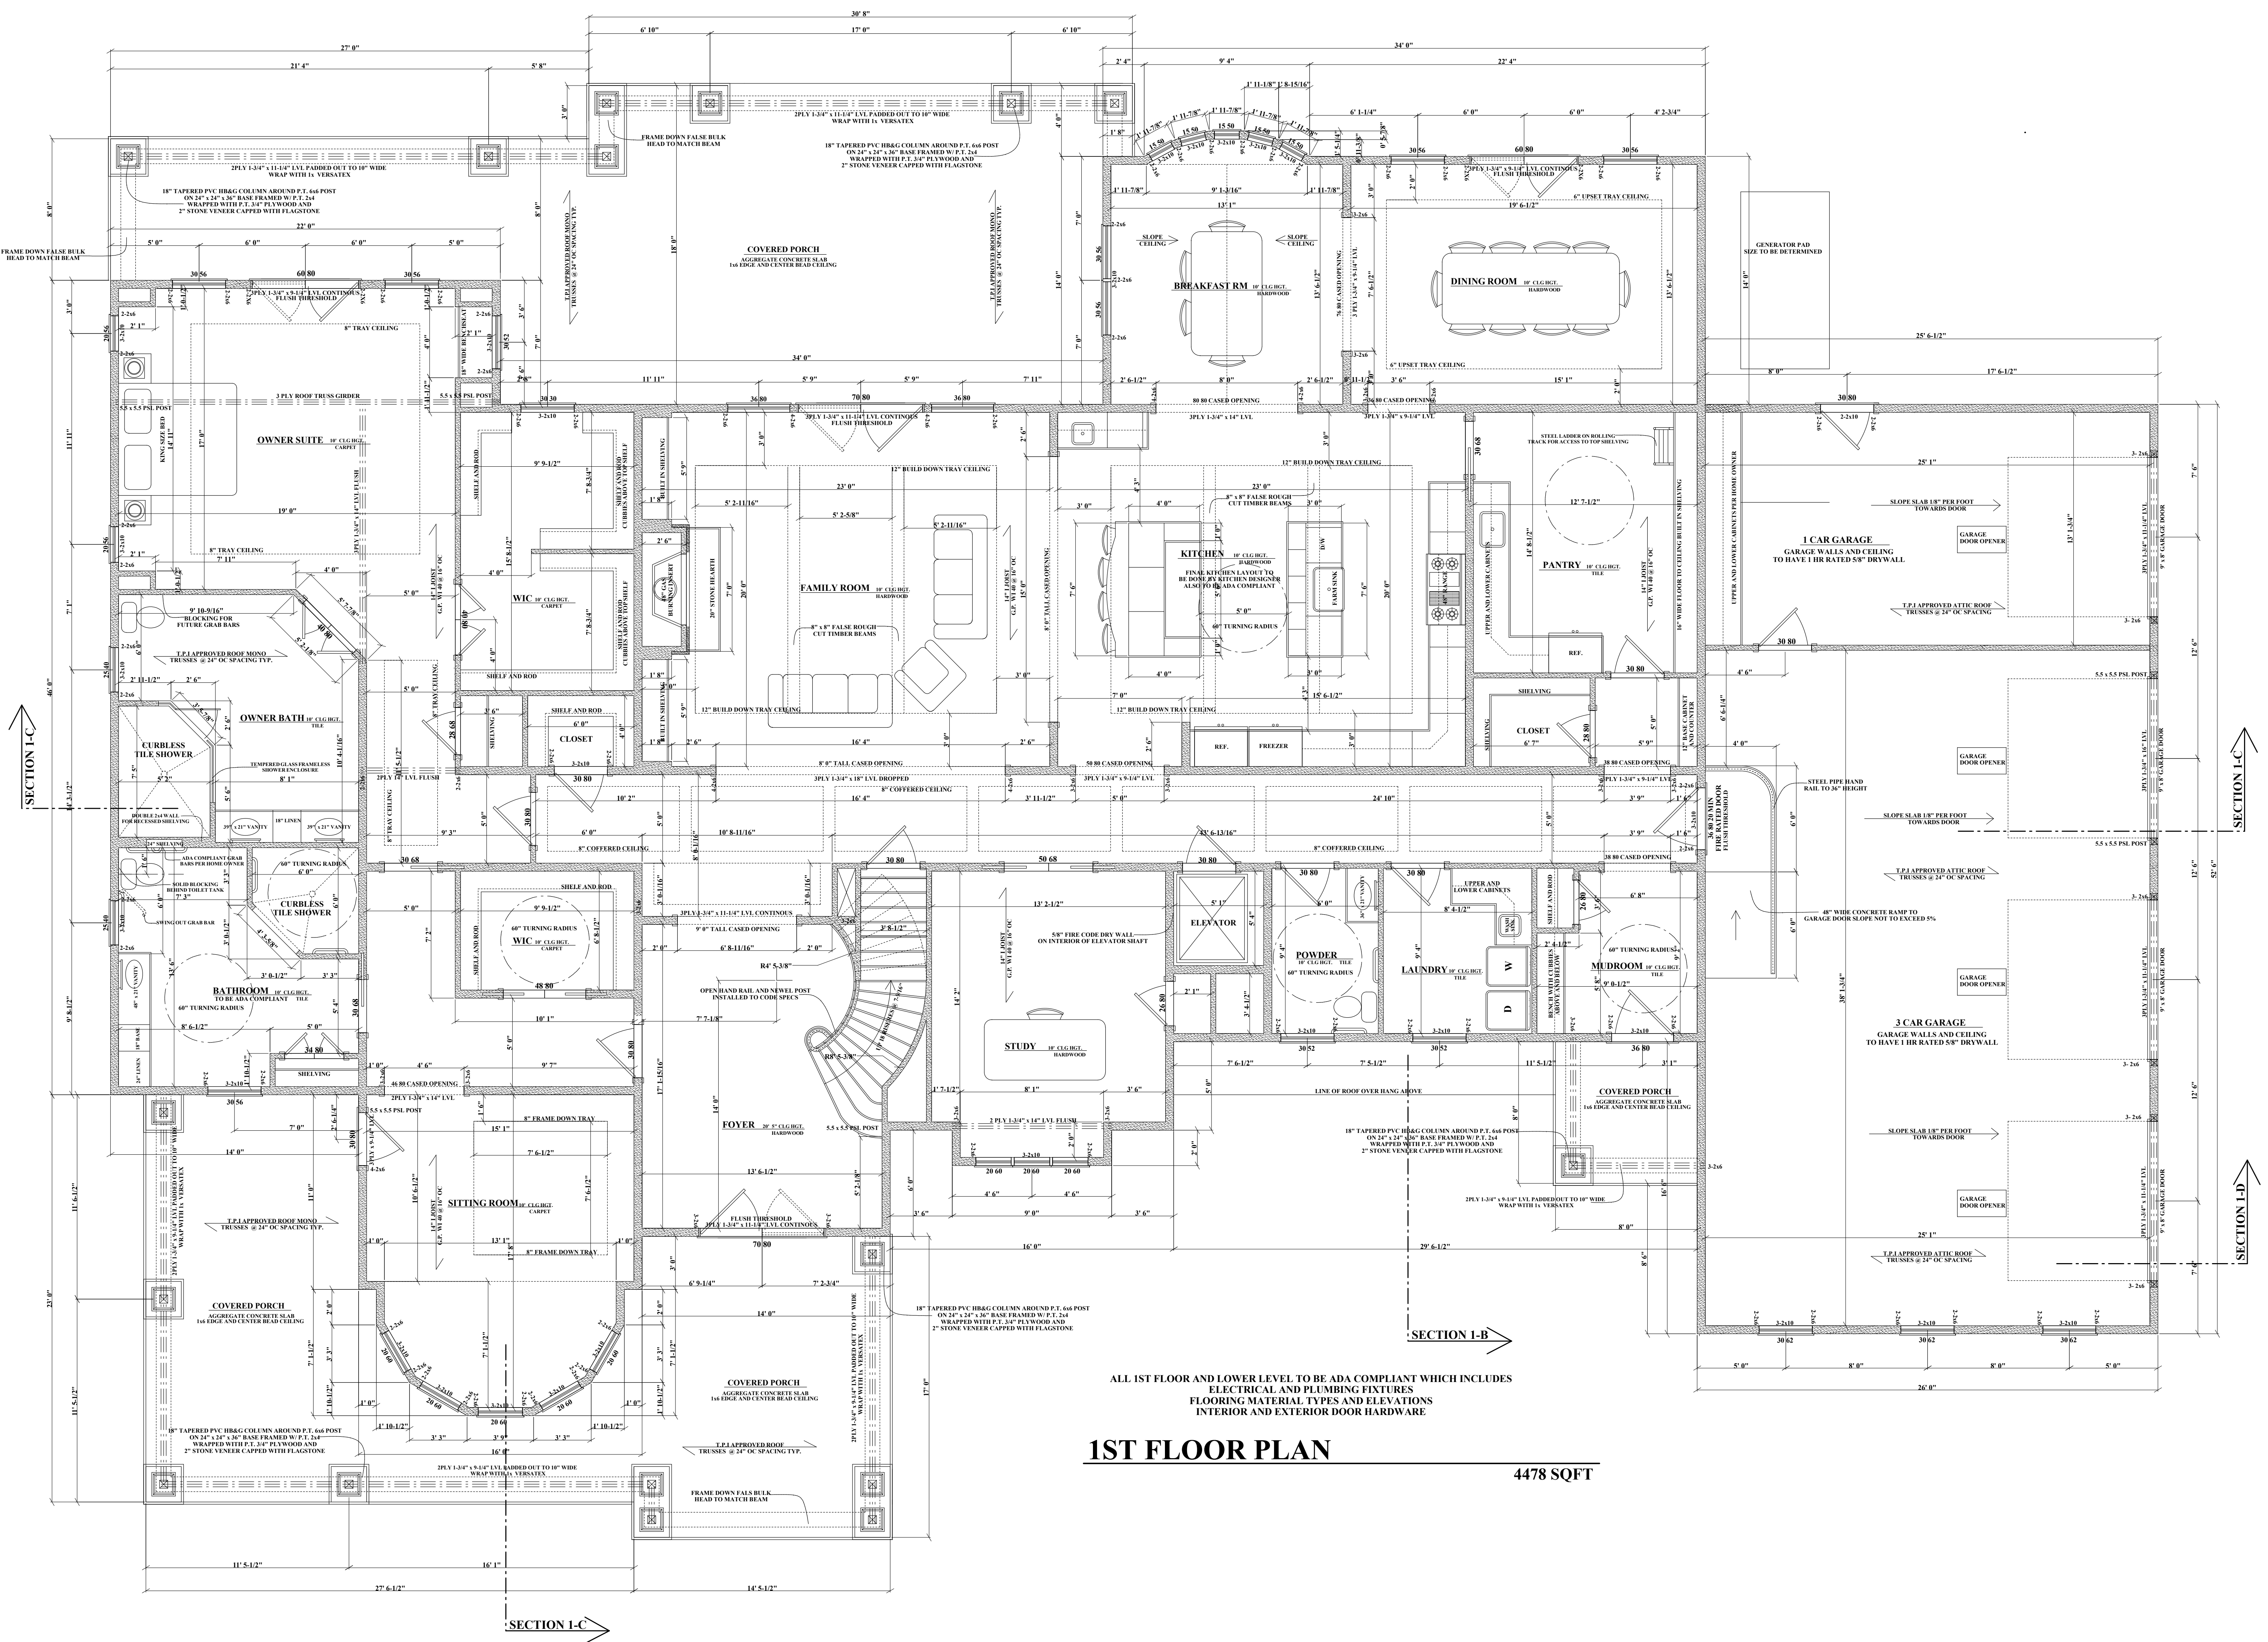

ALL 1ST FLOOR AND LOWER LEVEL TO BE ADA COMPLIANT WHICH INCLUDES ELECTRICAL AND PLUMBING FIXTURES

1ST FLOOR PLAN

4478 SQFT

THE CONTRACTOR IS RESPONSIBLE FOR DIMENSIONS TO BE CONFIRMED AND CORRELATED AT SITE FOR INFORMATION THAT PERTAINS SOLELY TO THE FABRICATION PROCESSES OR TO THE MEANS, METHODS, TECHNIQUES, SEQUENCES, AND PROCEDURES OF CONSTRUCTION OF THE WORK OF ALL TRADES

RB HOME DESIGNS

DATE :


SCALE : 1/4" = 1'

DRAWN : R. BREDLOW

2ND FLOOR PLAN


SHEET NO.

A-7

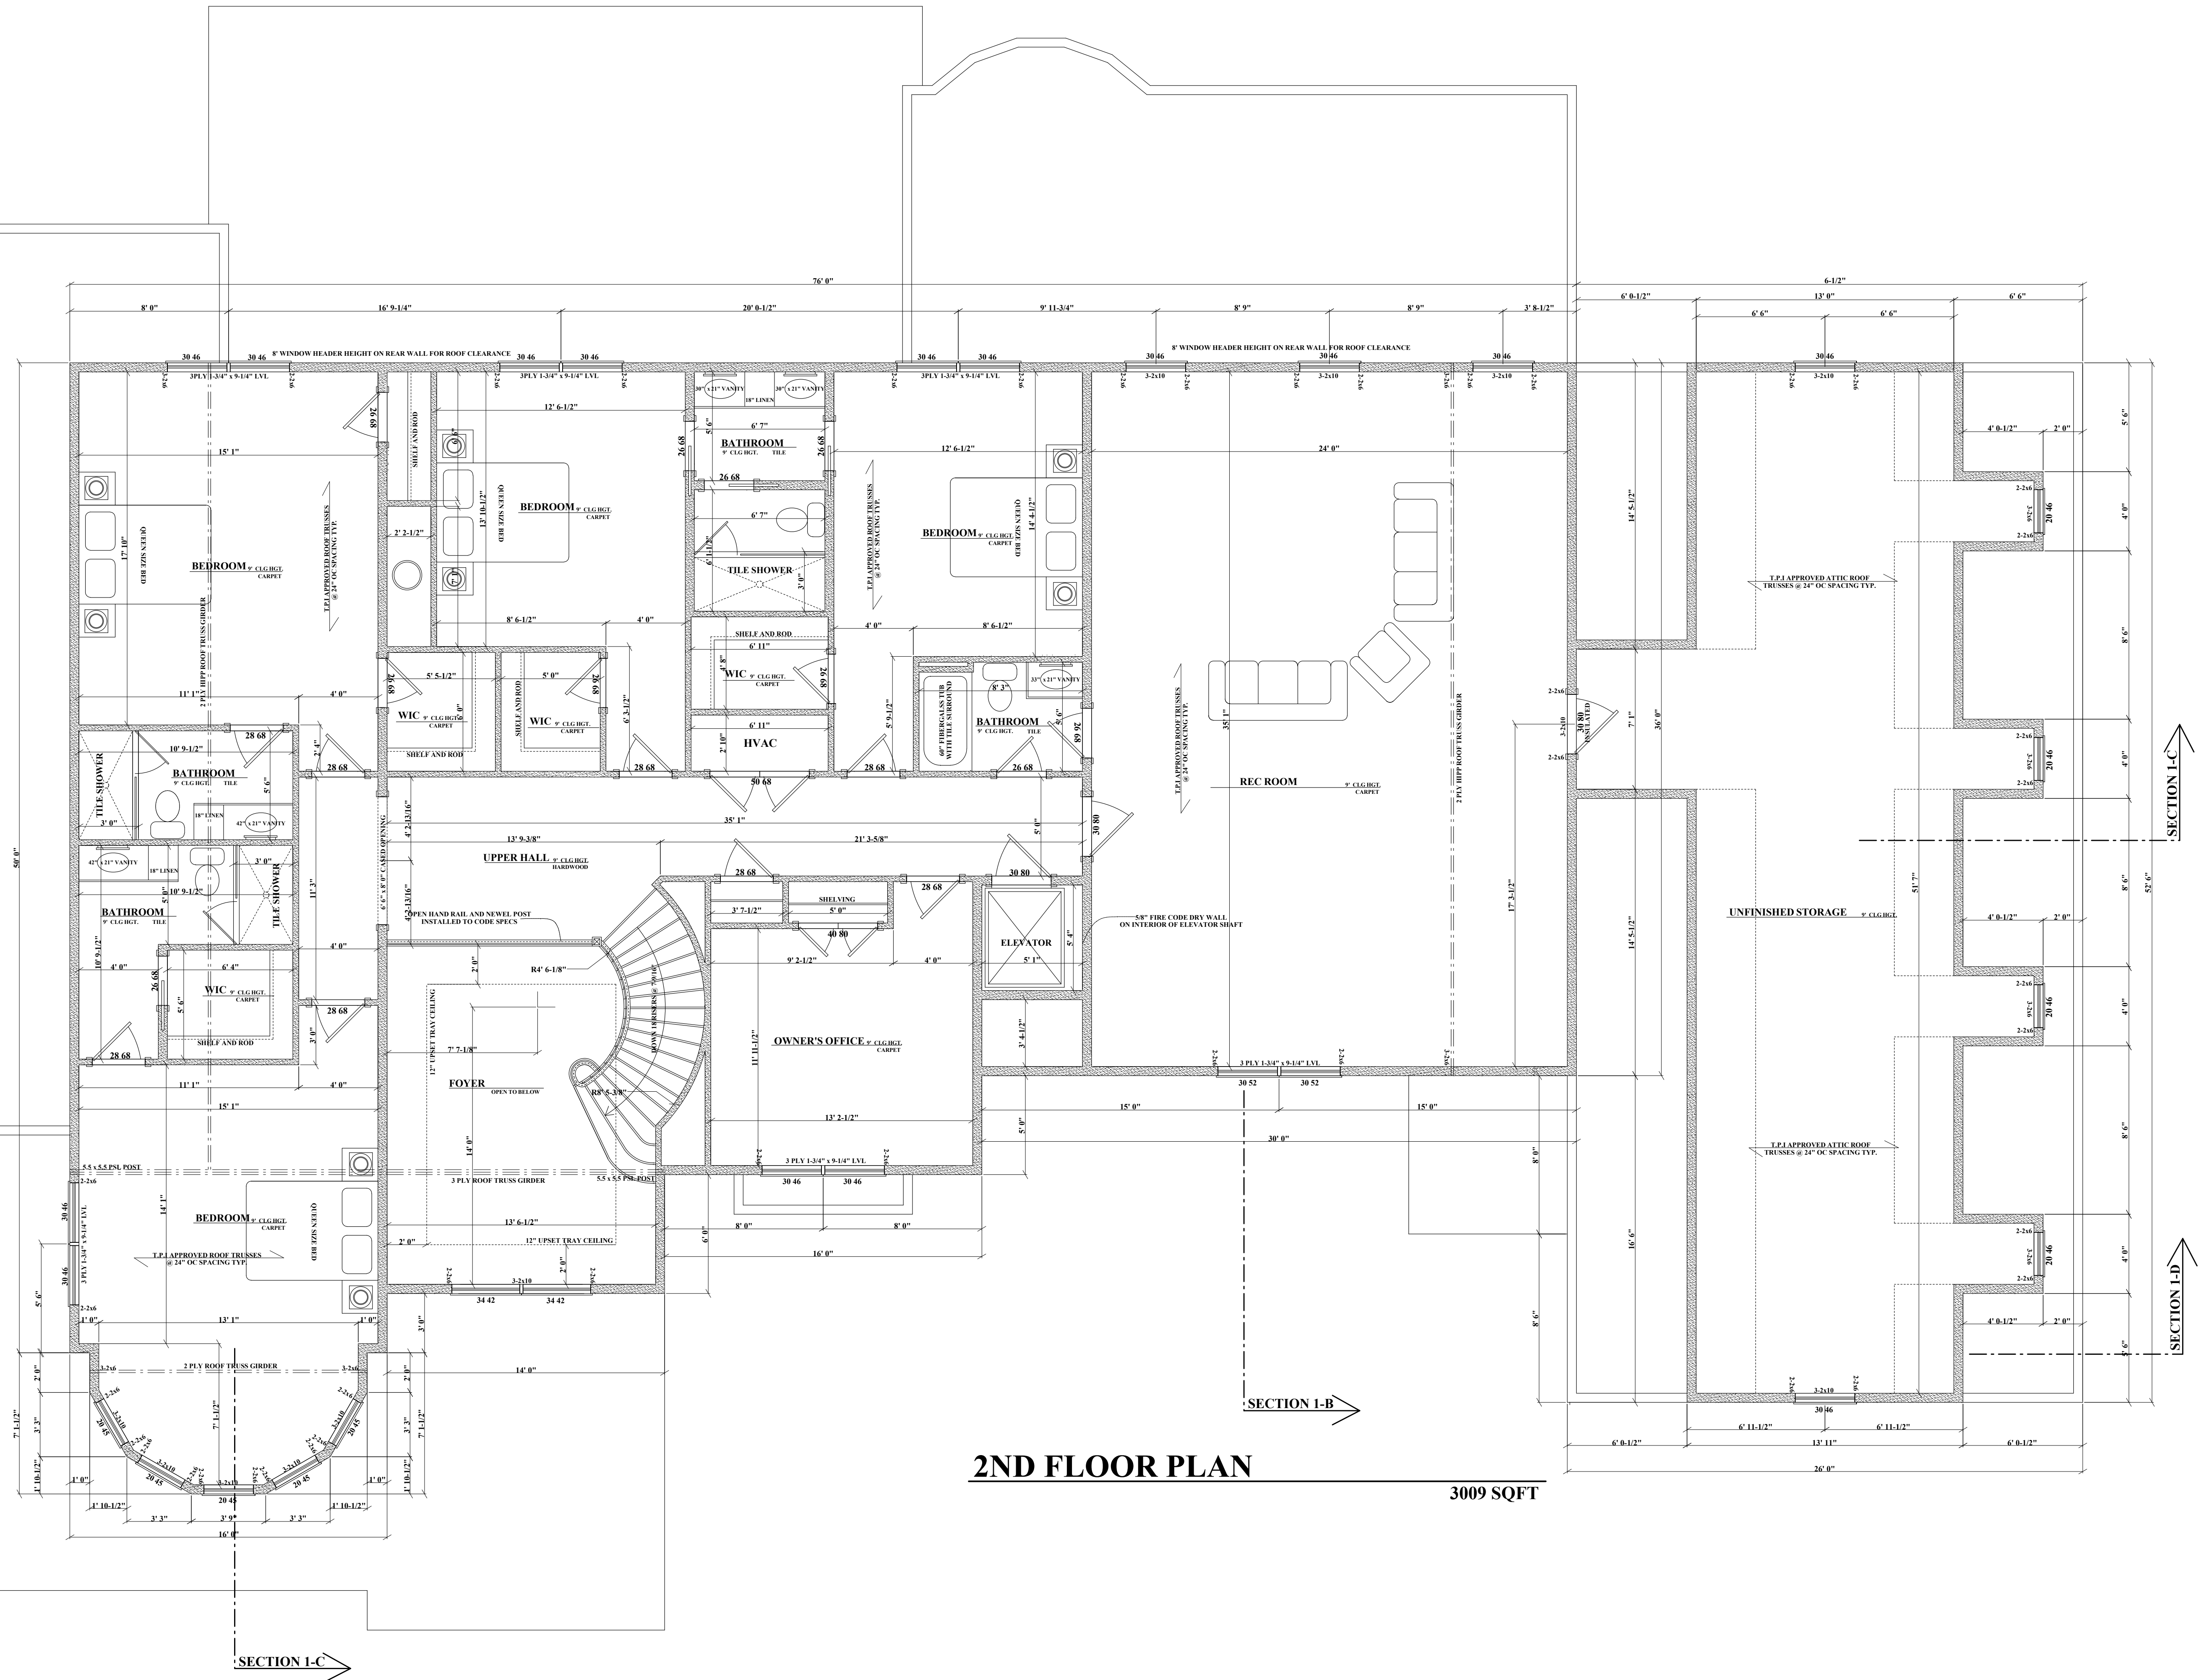

2ND FLOOR PLAN

3009 SQFT

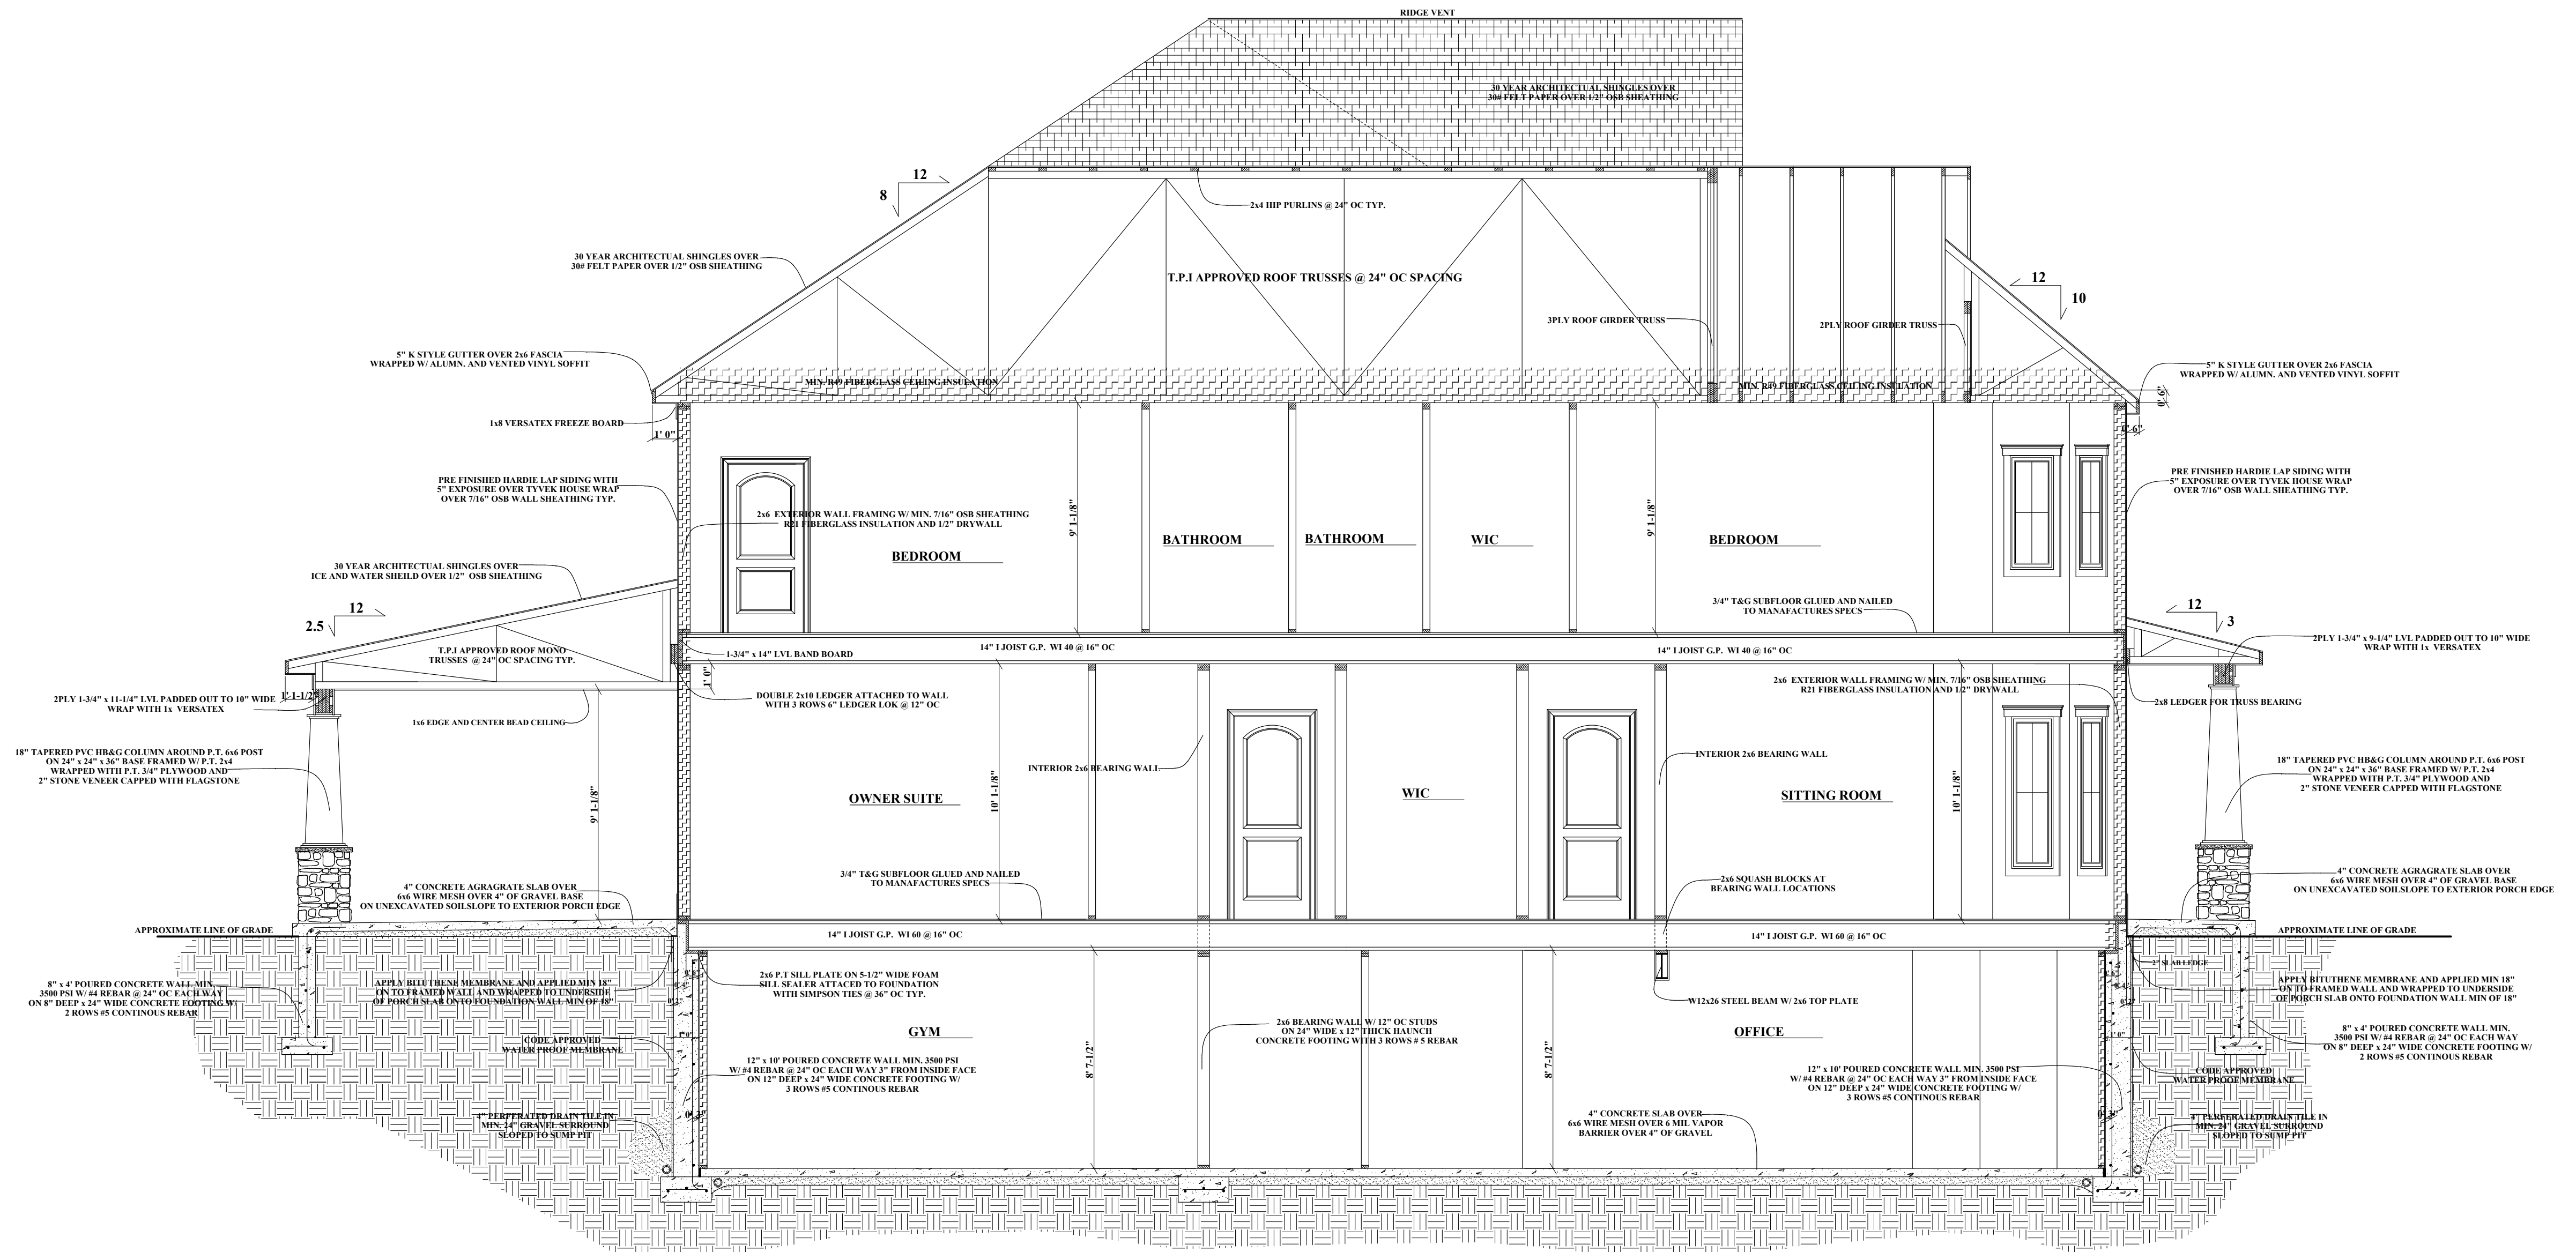

SECTION 1-A

THE CONTRACTOR IS RESPONSIBLE FOR DIMENSIONS TO BE CONFIRMED AND CORRELATED AT SITE FOR INFORMATION THAT PERTAINS SOLELY TO THE FABRICATION PROCESSES OR TO THE MEANS, METHODS, TECHNIQUES, SEQUENCES, AND PROCEDURES OF CONSTRUCTION OF THE WORK OF ALL TRADES

RB HOME DESIGNS

DATE :

SCALE : 1/4" = 1'


DRAWN :

R. BREDLOW


SECTION 1-A

SHEET NO.

A-9

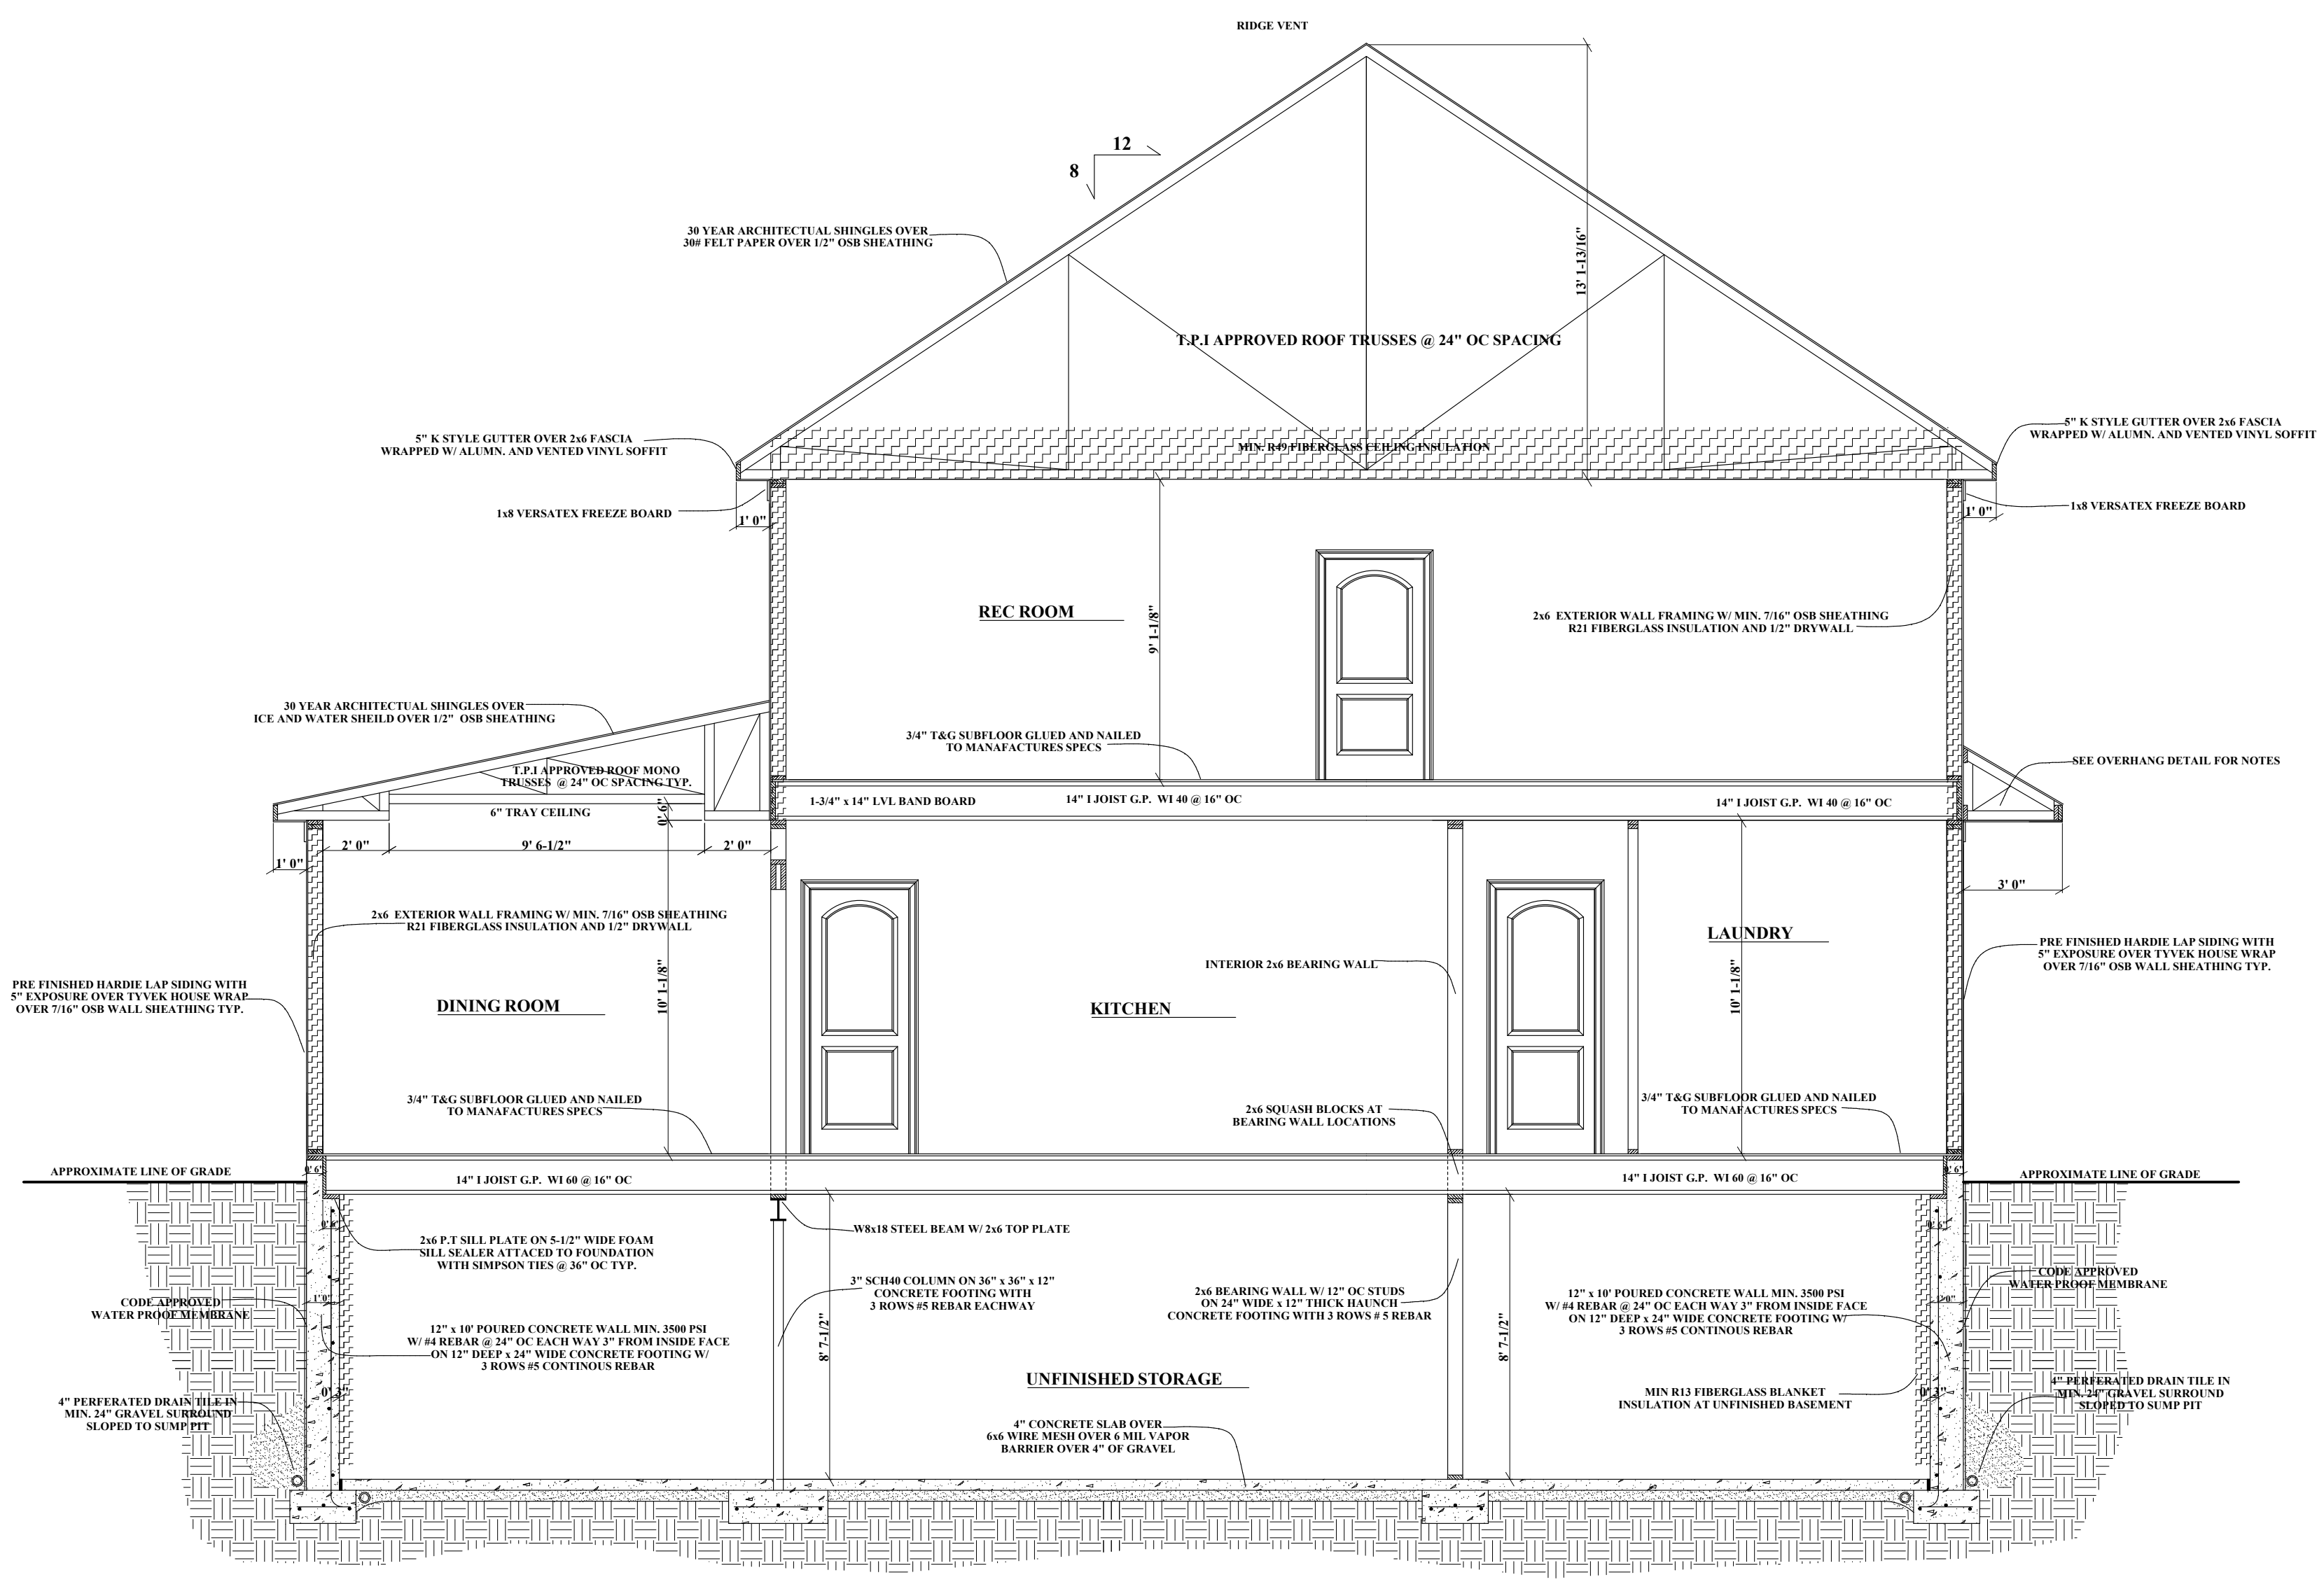

SECTION 1-B

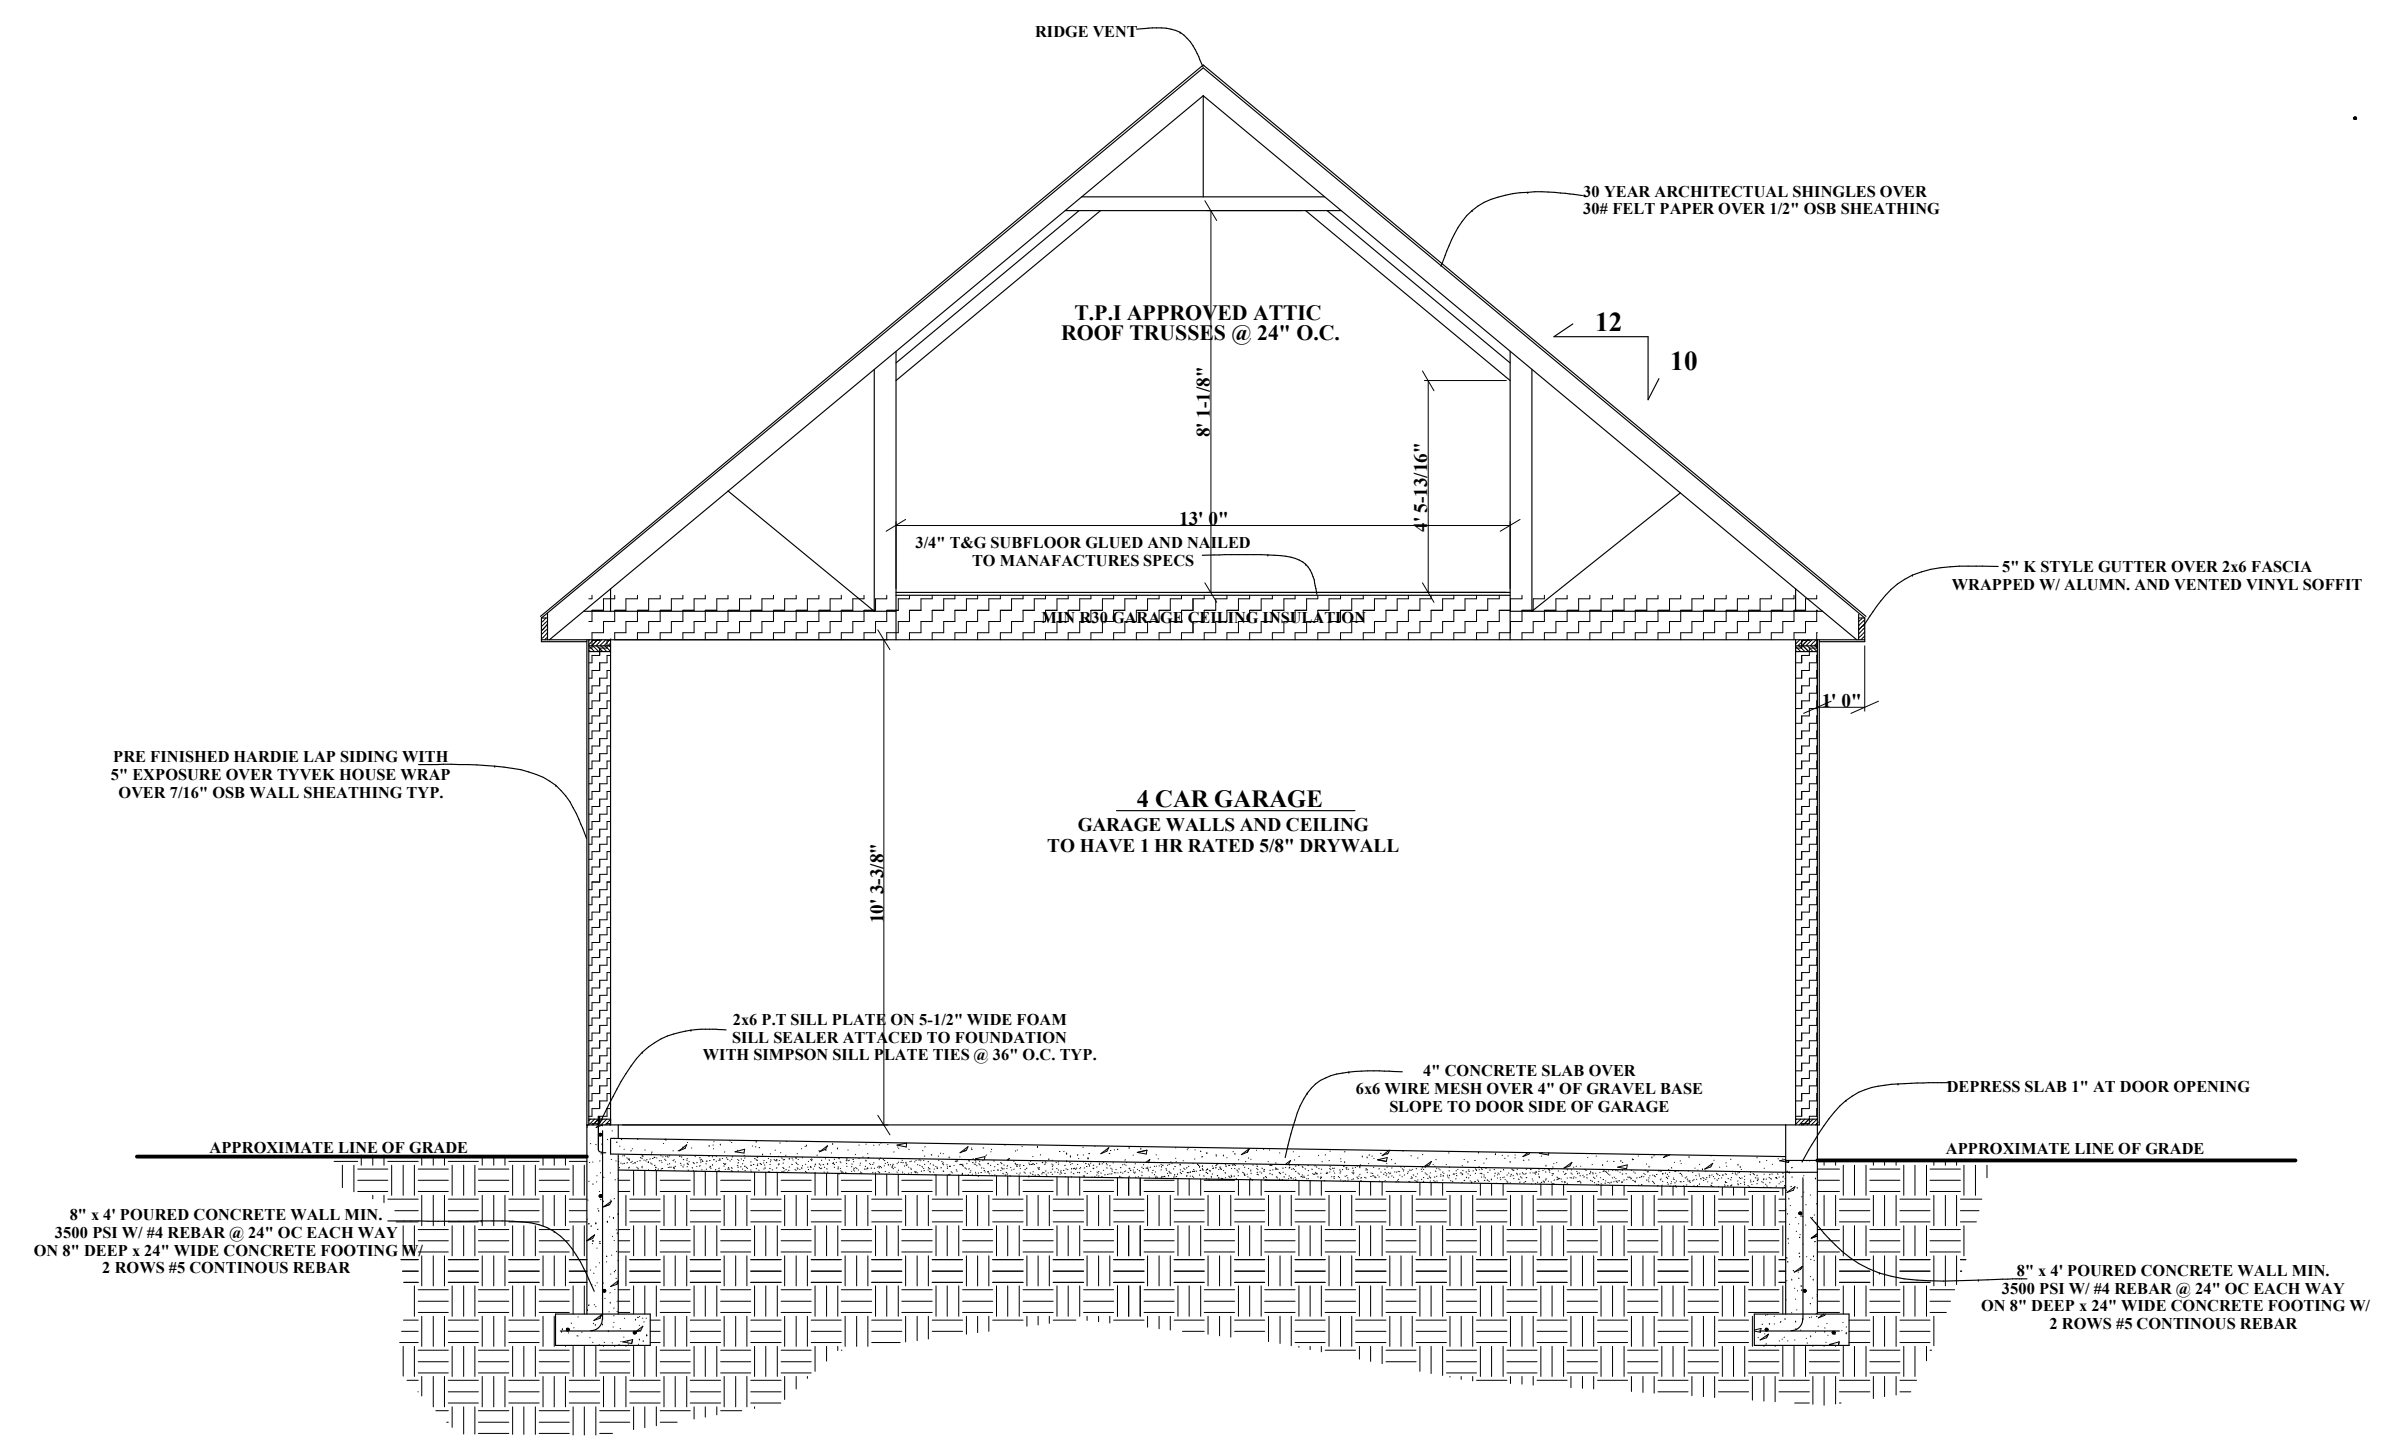

SECTION 1-C

THE CONTRACTOR IS RESPONSIBLE FOR DIMENSIONS TO BE CONFIRMED AND CORRELATED AT SITE FOR INFORMATION THAT PERTAINS SOLELY TO THE FABRICATION PROCESSES OR TO THE MEANS, METHODS, TECHNIQUES, SEQUENCES, AND PROCEDURES OF CONSTRUCTION OF THE WORK OF ALL TRADES

RB HOME DESIGNS

DATE :


SCALE : 1/4" = 1'

DRAWN : R. BREDLOW

SECTION 1-B, 1-C

SHEET NO.

A-10

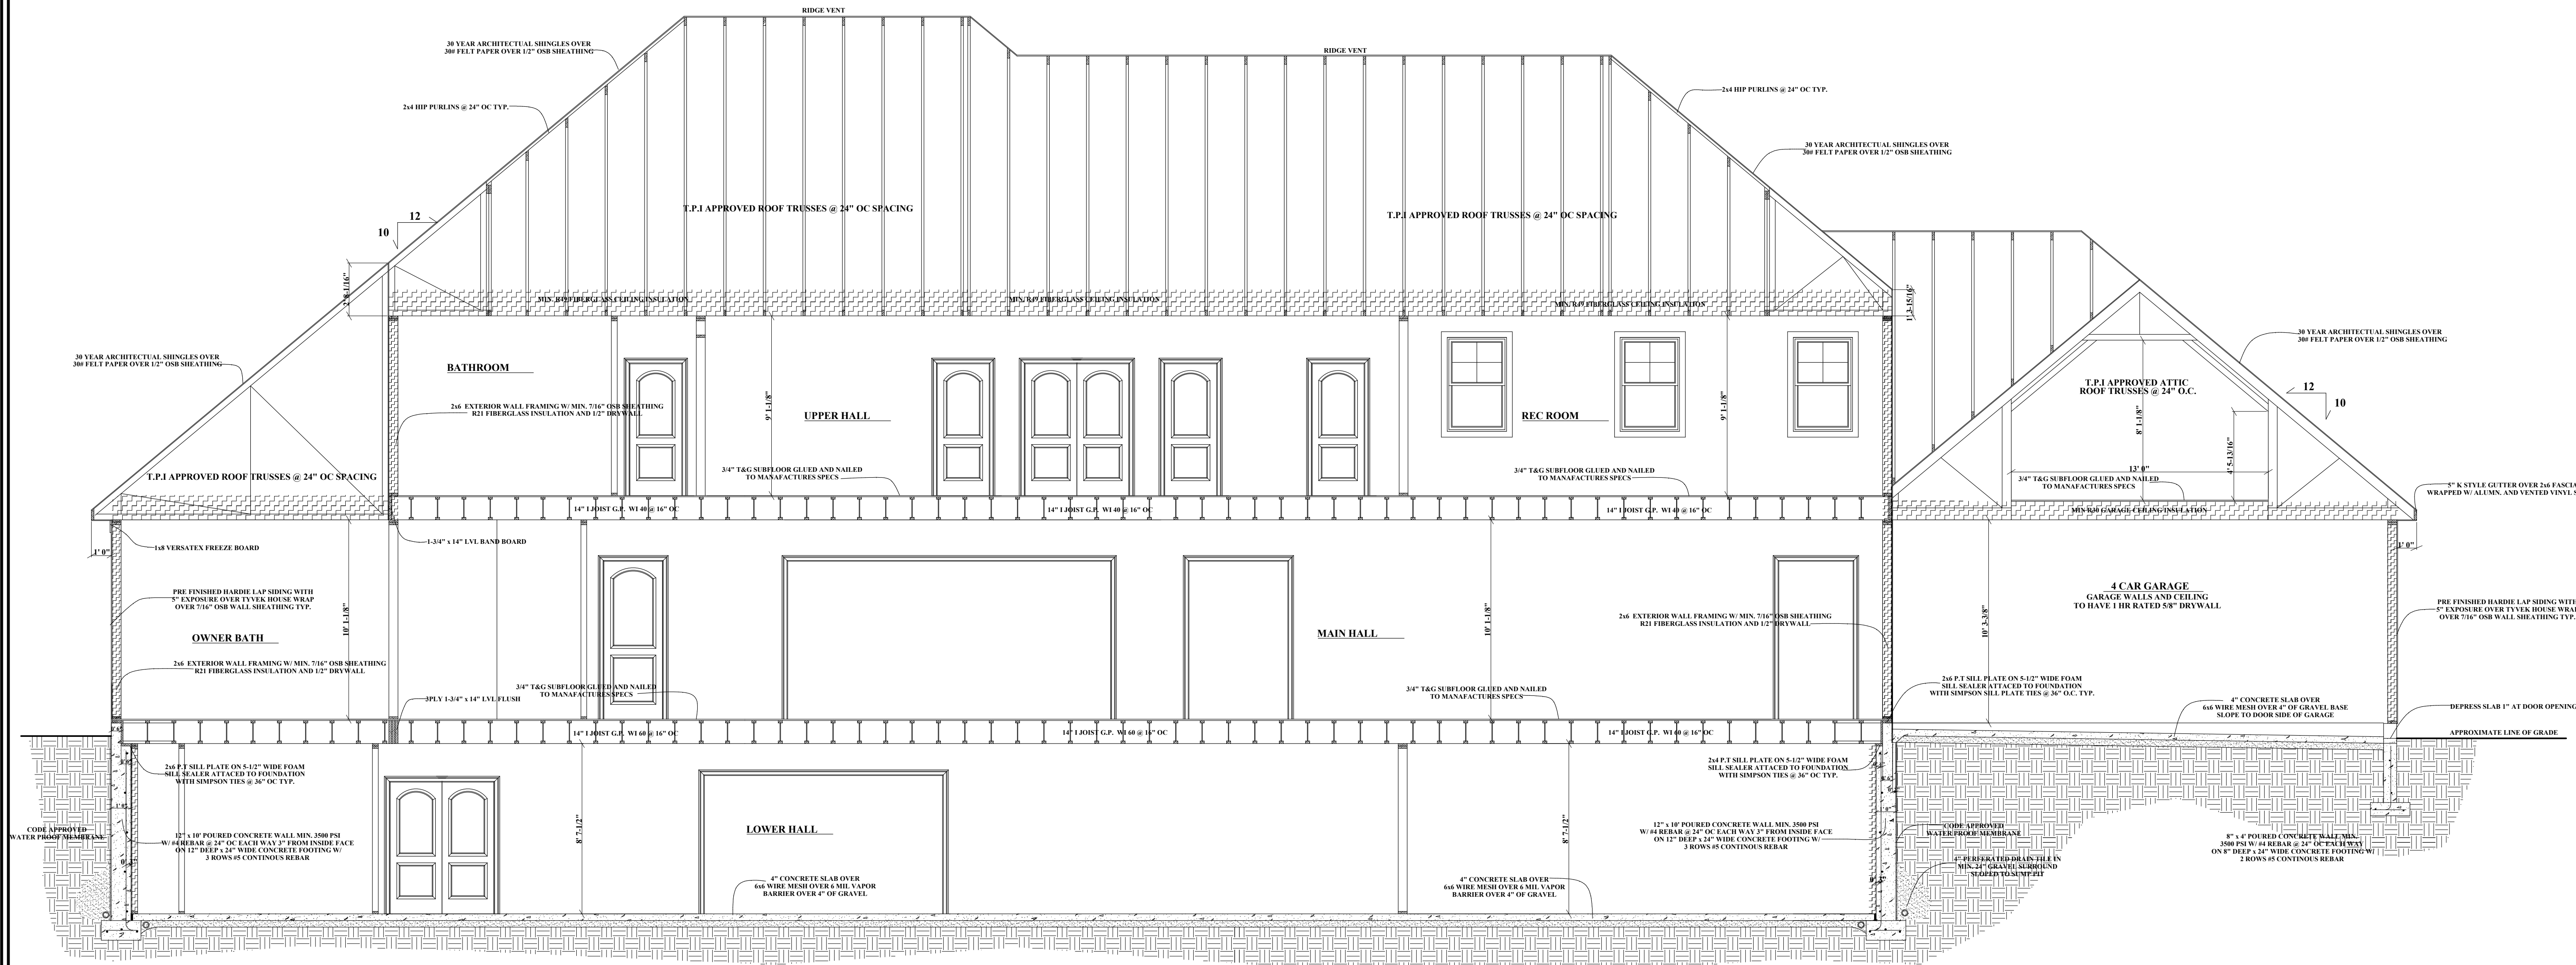

SECTION 1-D

THE CONTRACTOR IS RESPONSIBLE FOR DIMENSIONS TO BE CONFIRMED AND CORRELATED AT SITE FOR INFORMATION THAT PERTAINS SOLELY TO THE FABRICATION PROCESSES OR TO THE MEASUREMENTS, METHODS, TECHNIQUES, SEQUENCES, AND PROCEDURES OF CONSTRUCTION OF THE WORK OF ALL TRADES

RB HOME DESIGNS

DATE :


SCALE : 1/4" = 1'

DRAWN : R. BREDLOW


SECTION 1-D

SHEET NO.


A-11

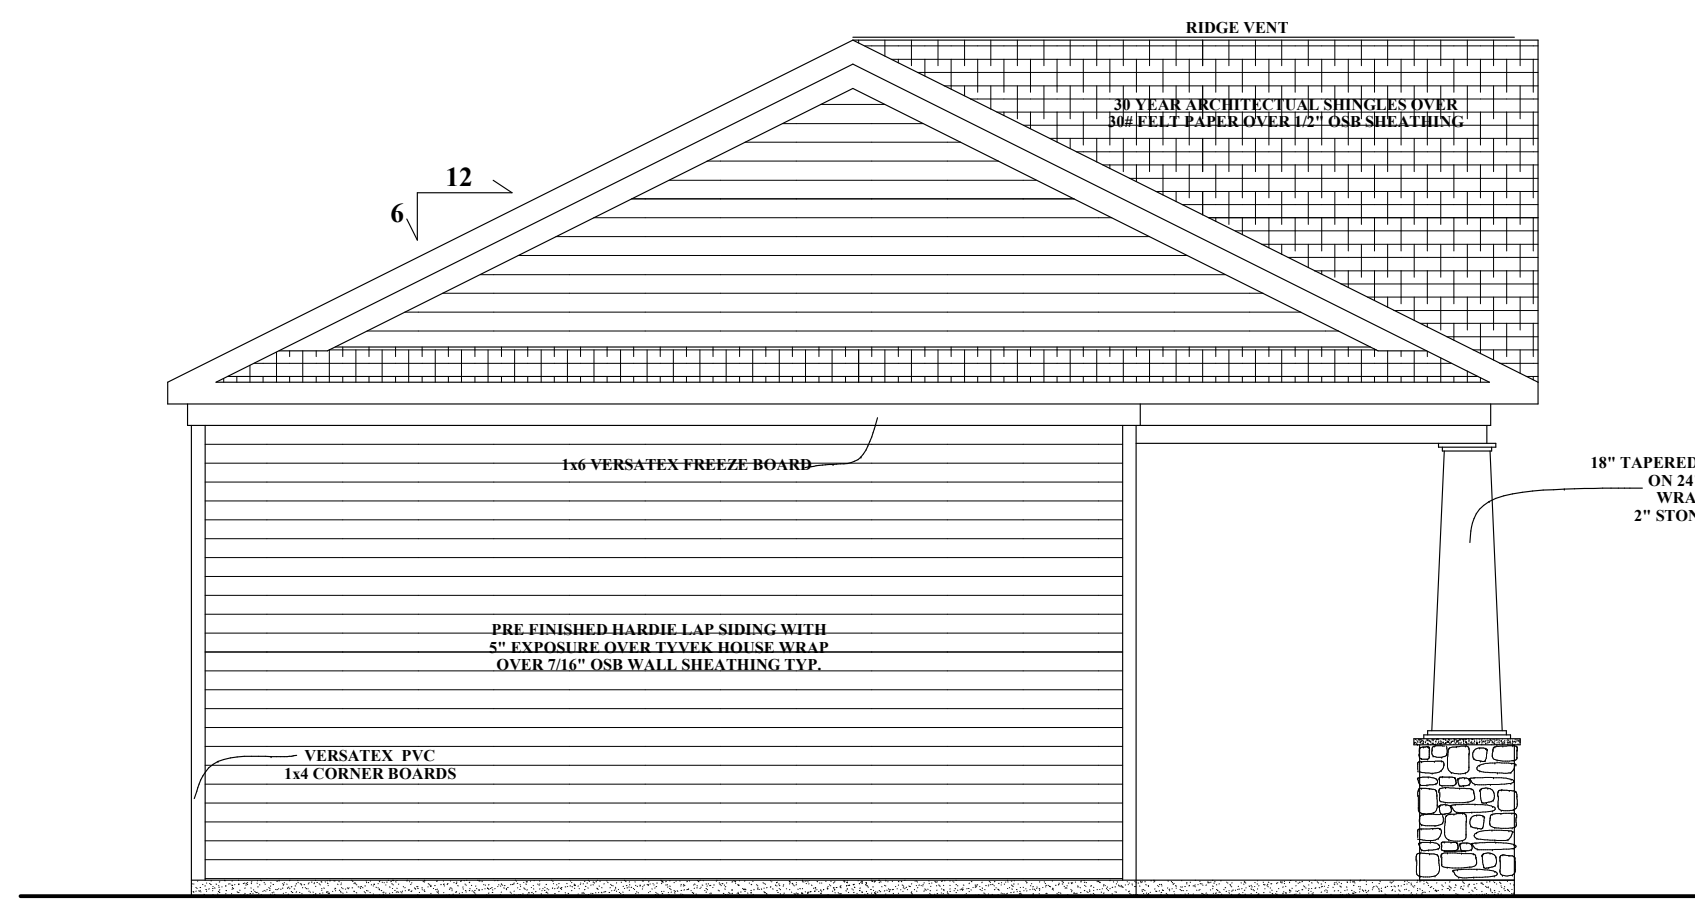


LEFT ELEVATION

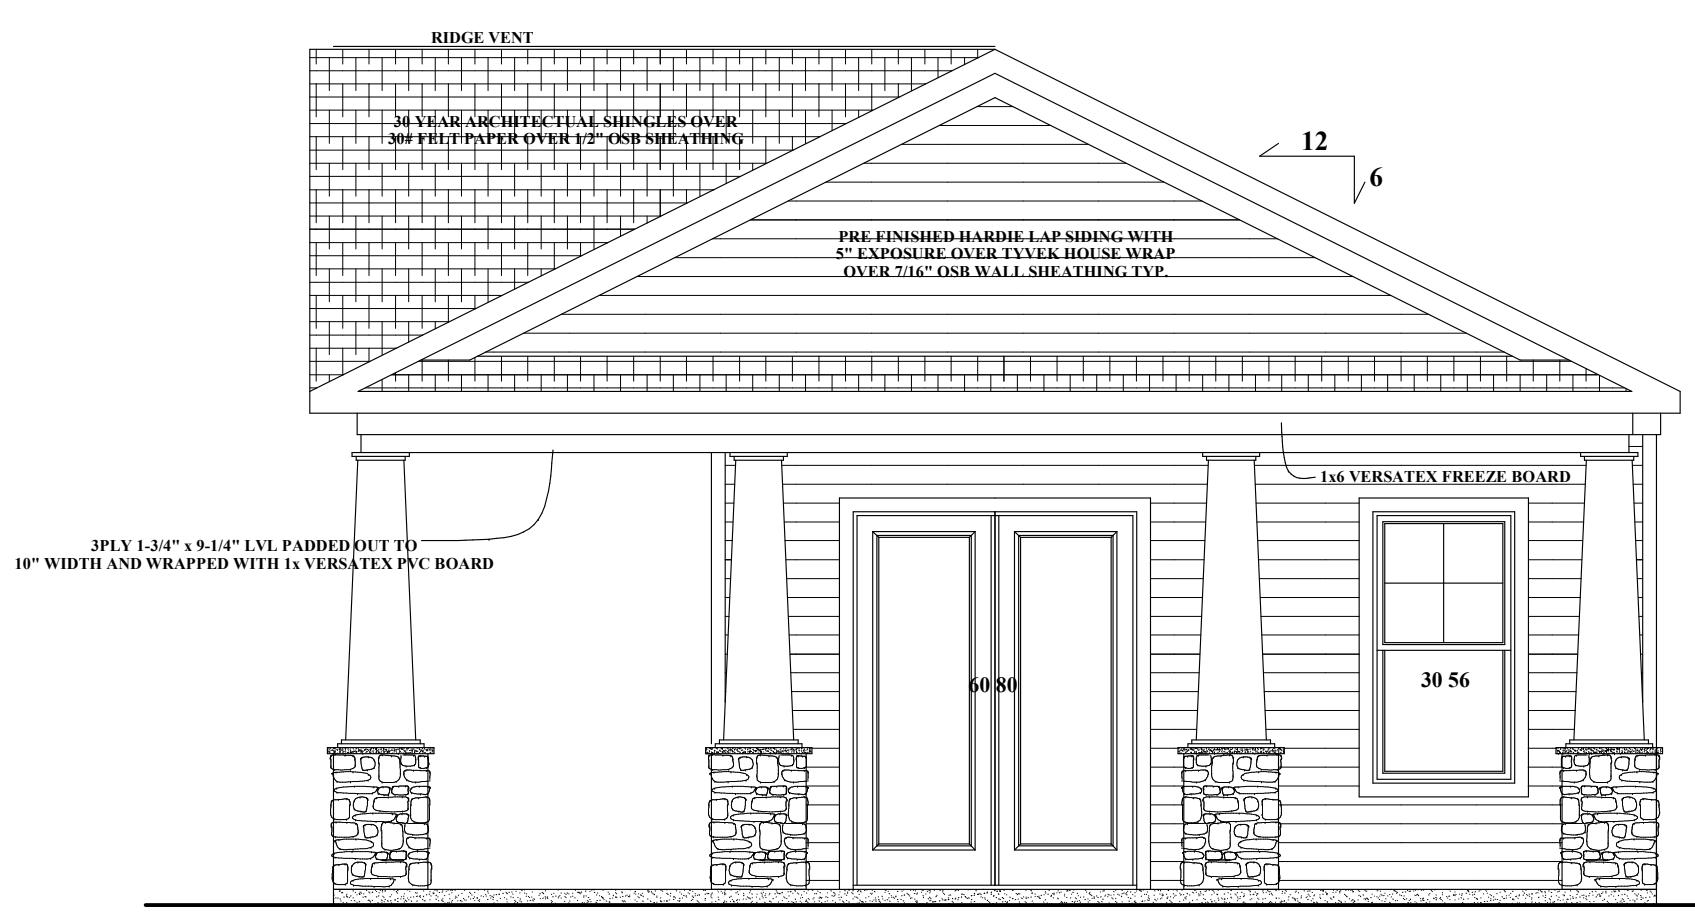


RIGHT ELEVATION

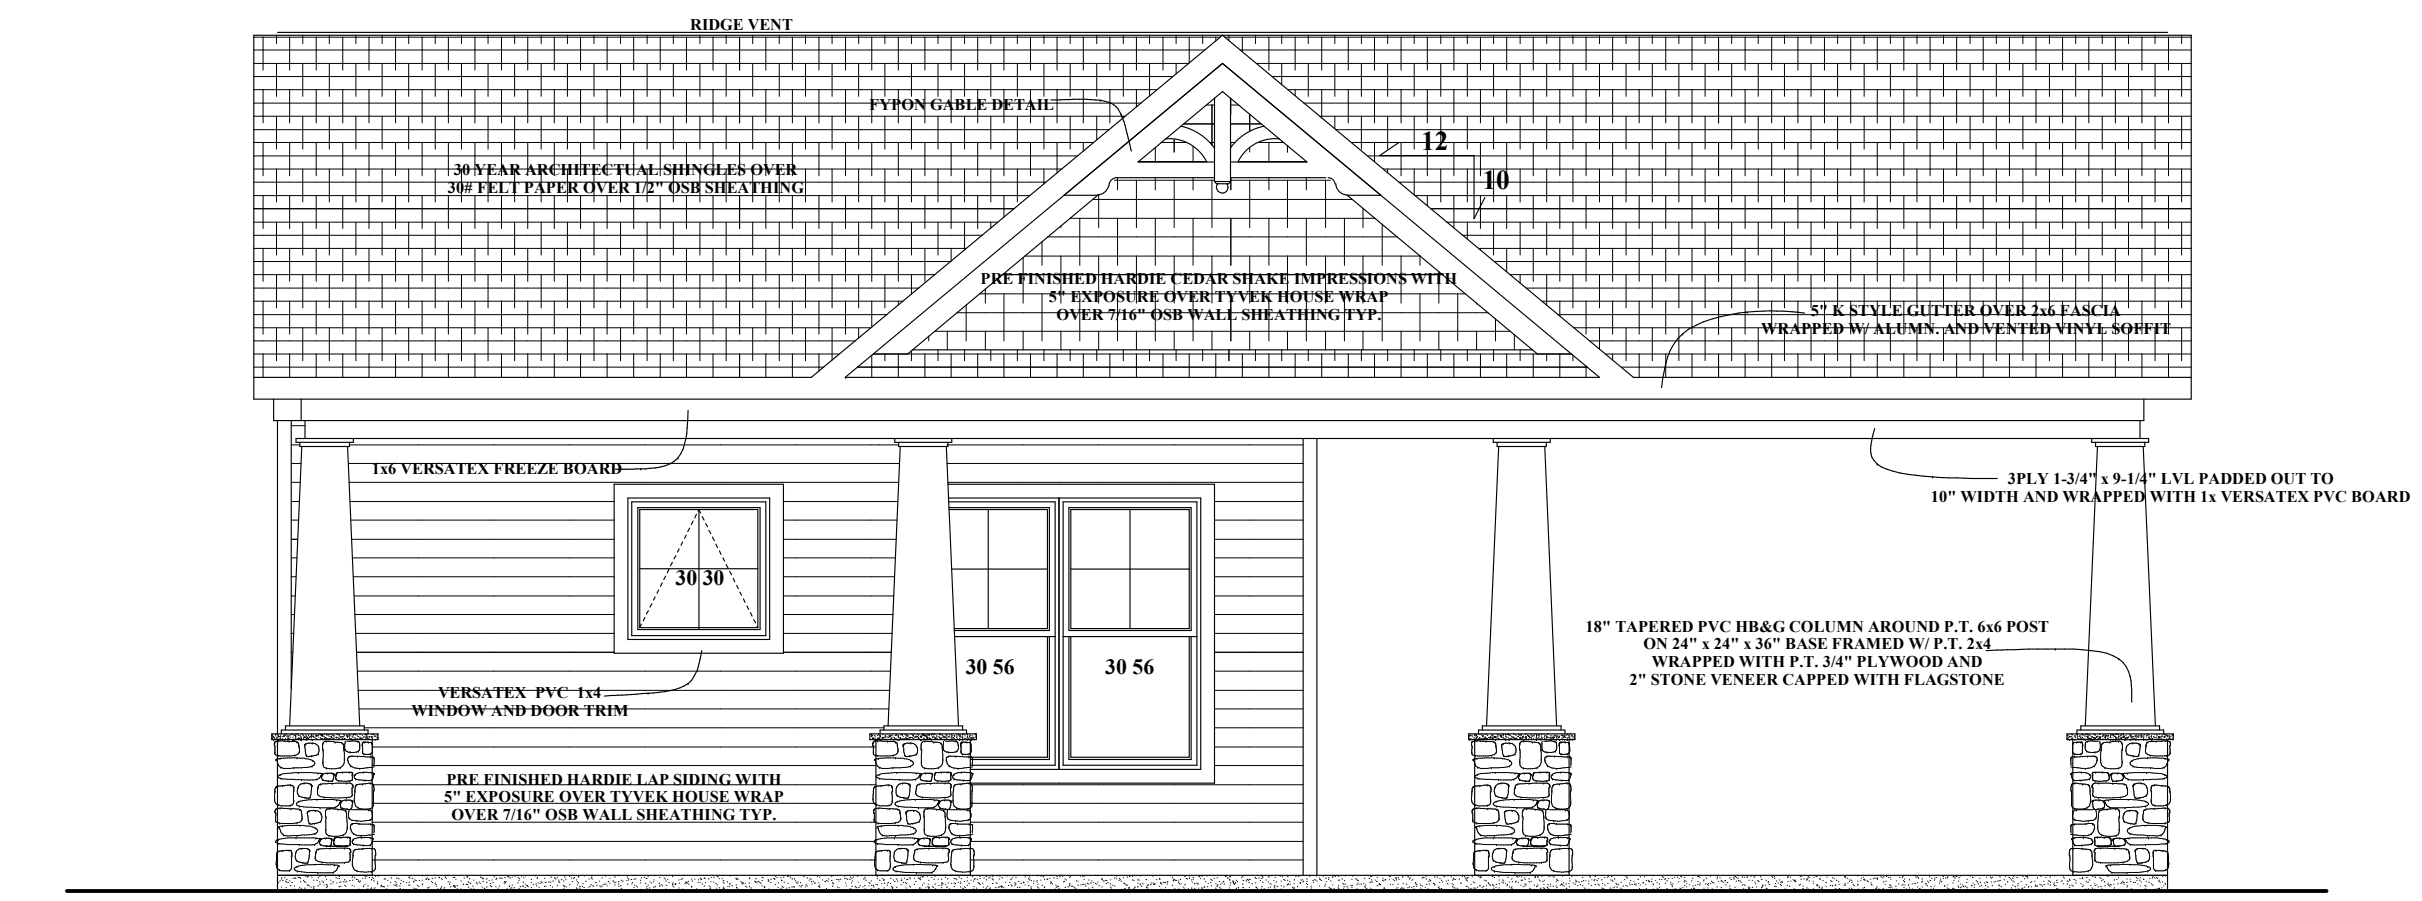


FRONT ELEVATION

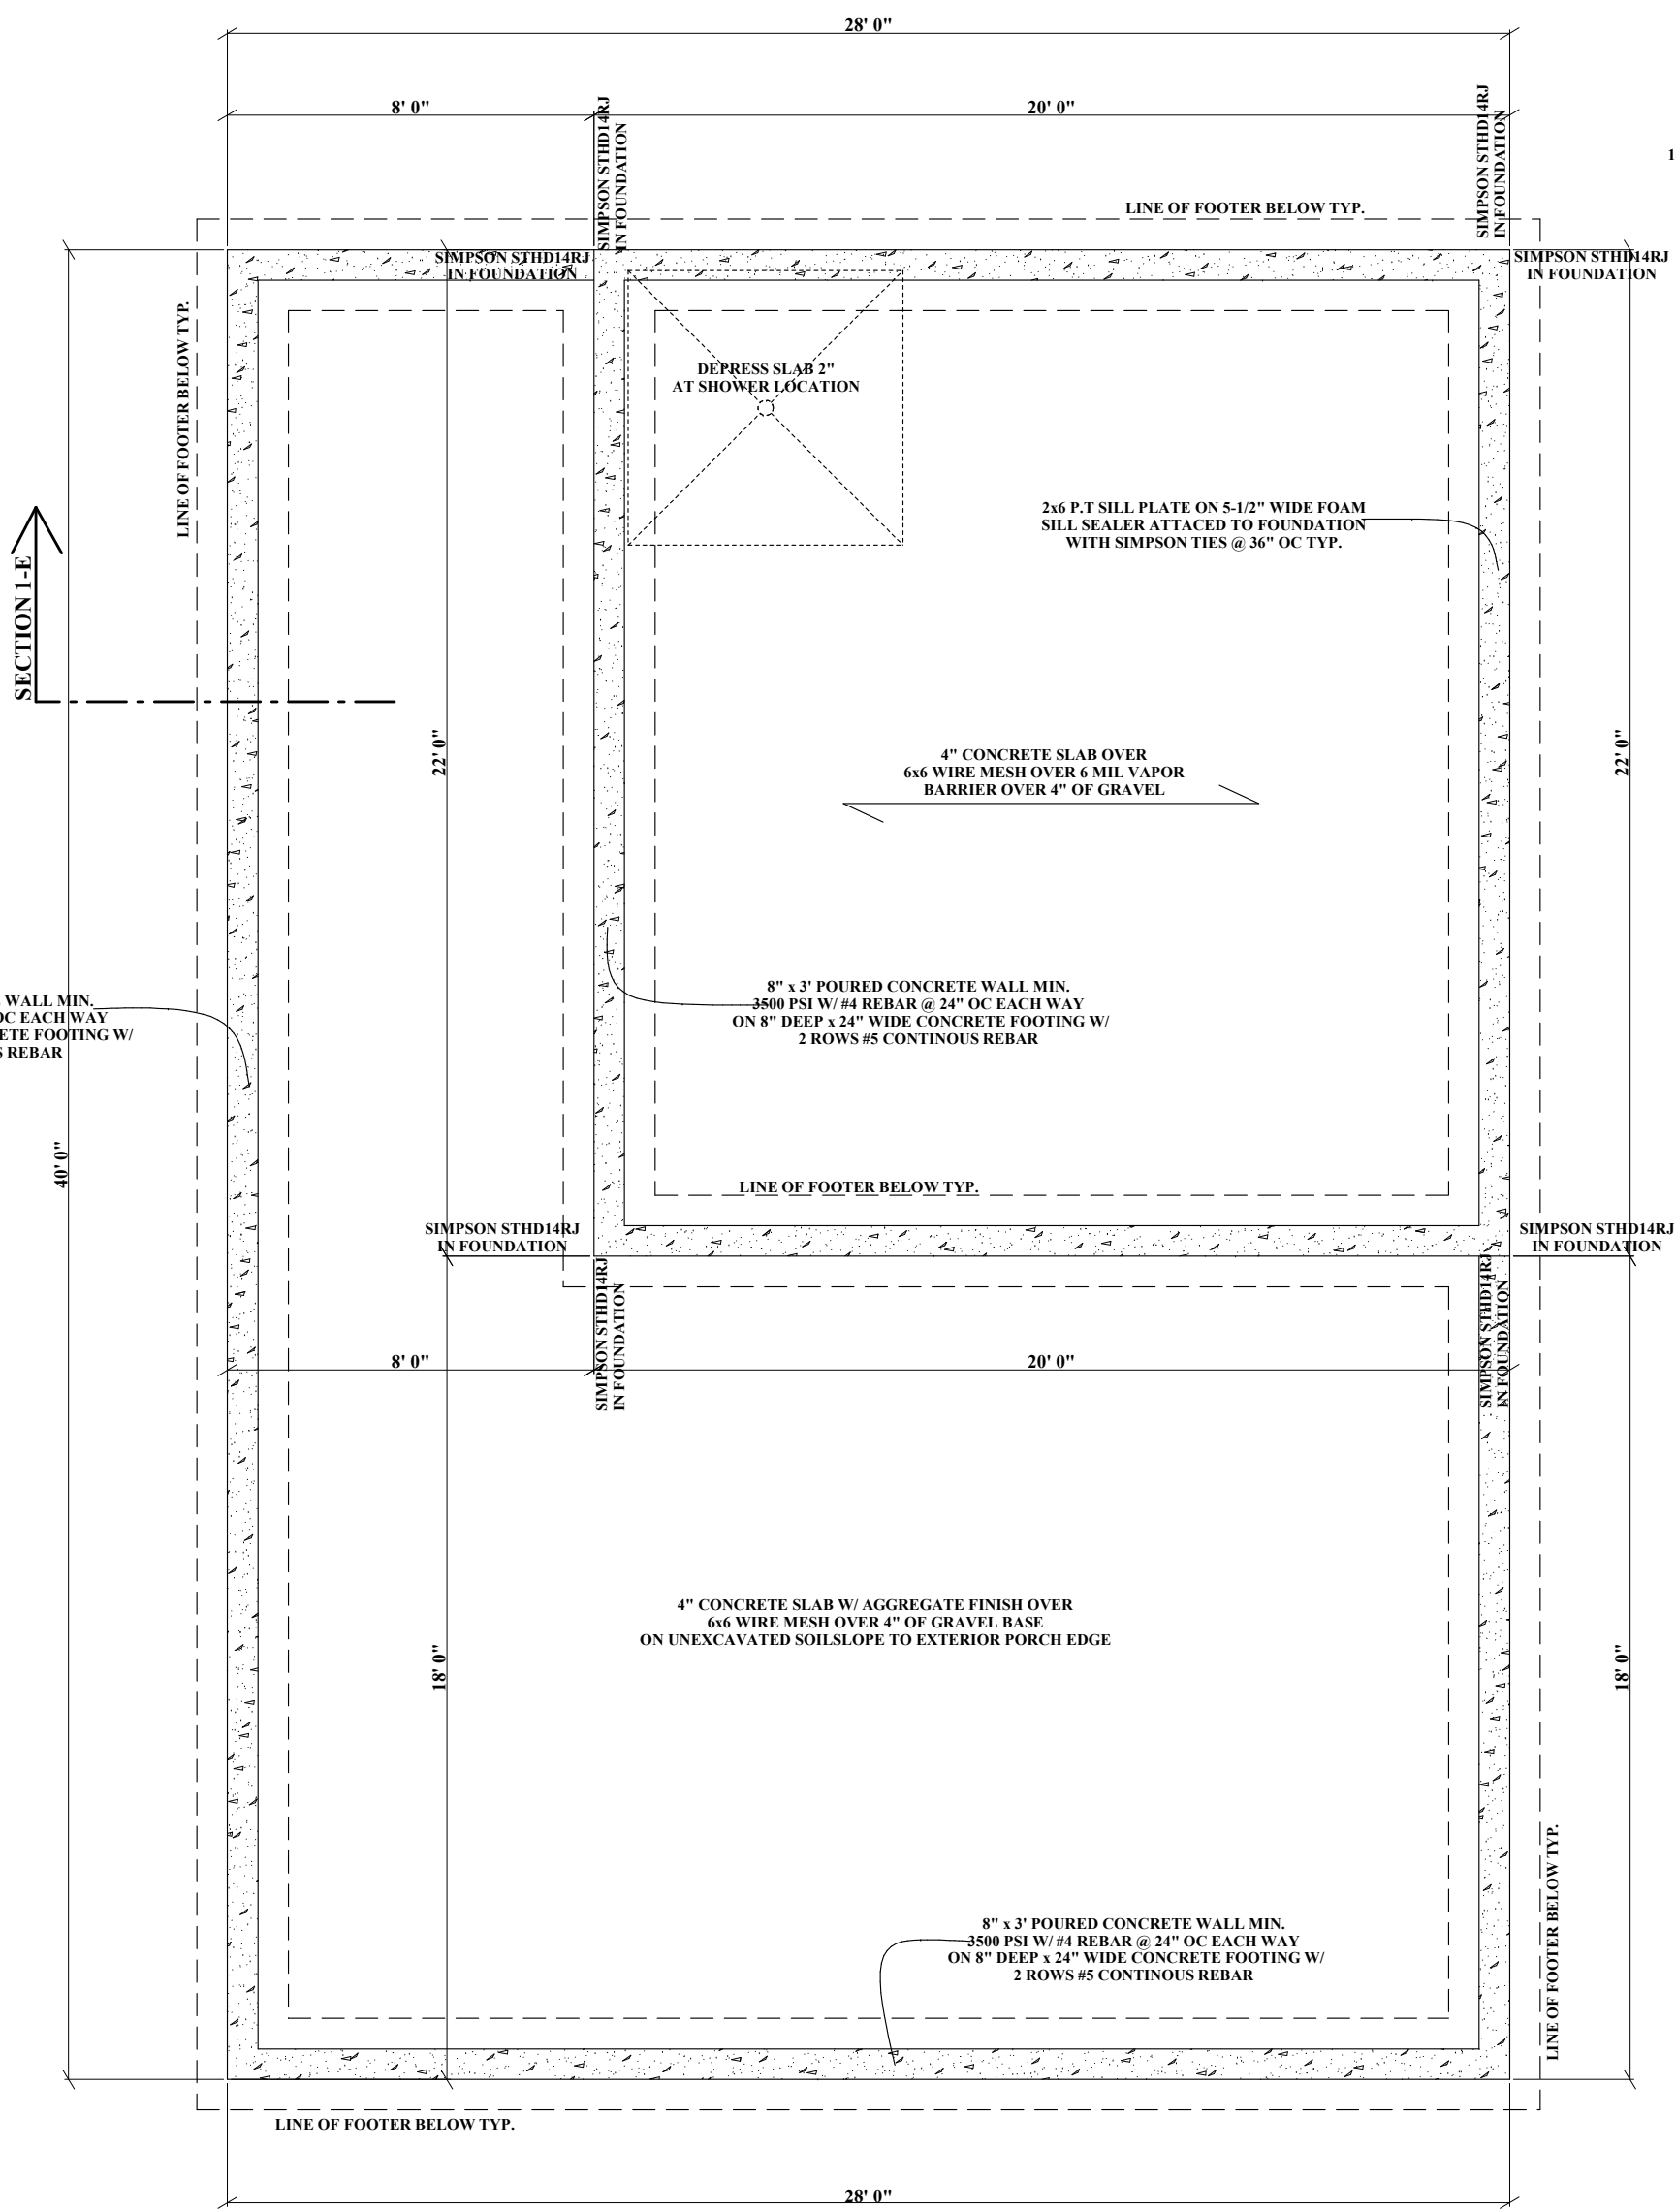

FOUNDATION PLAN

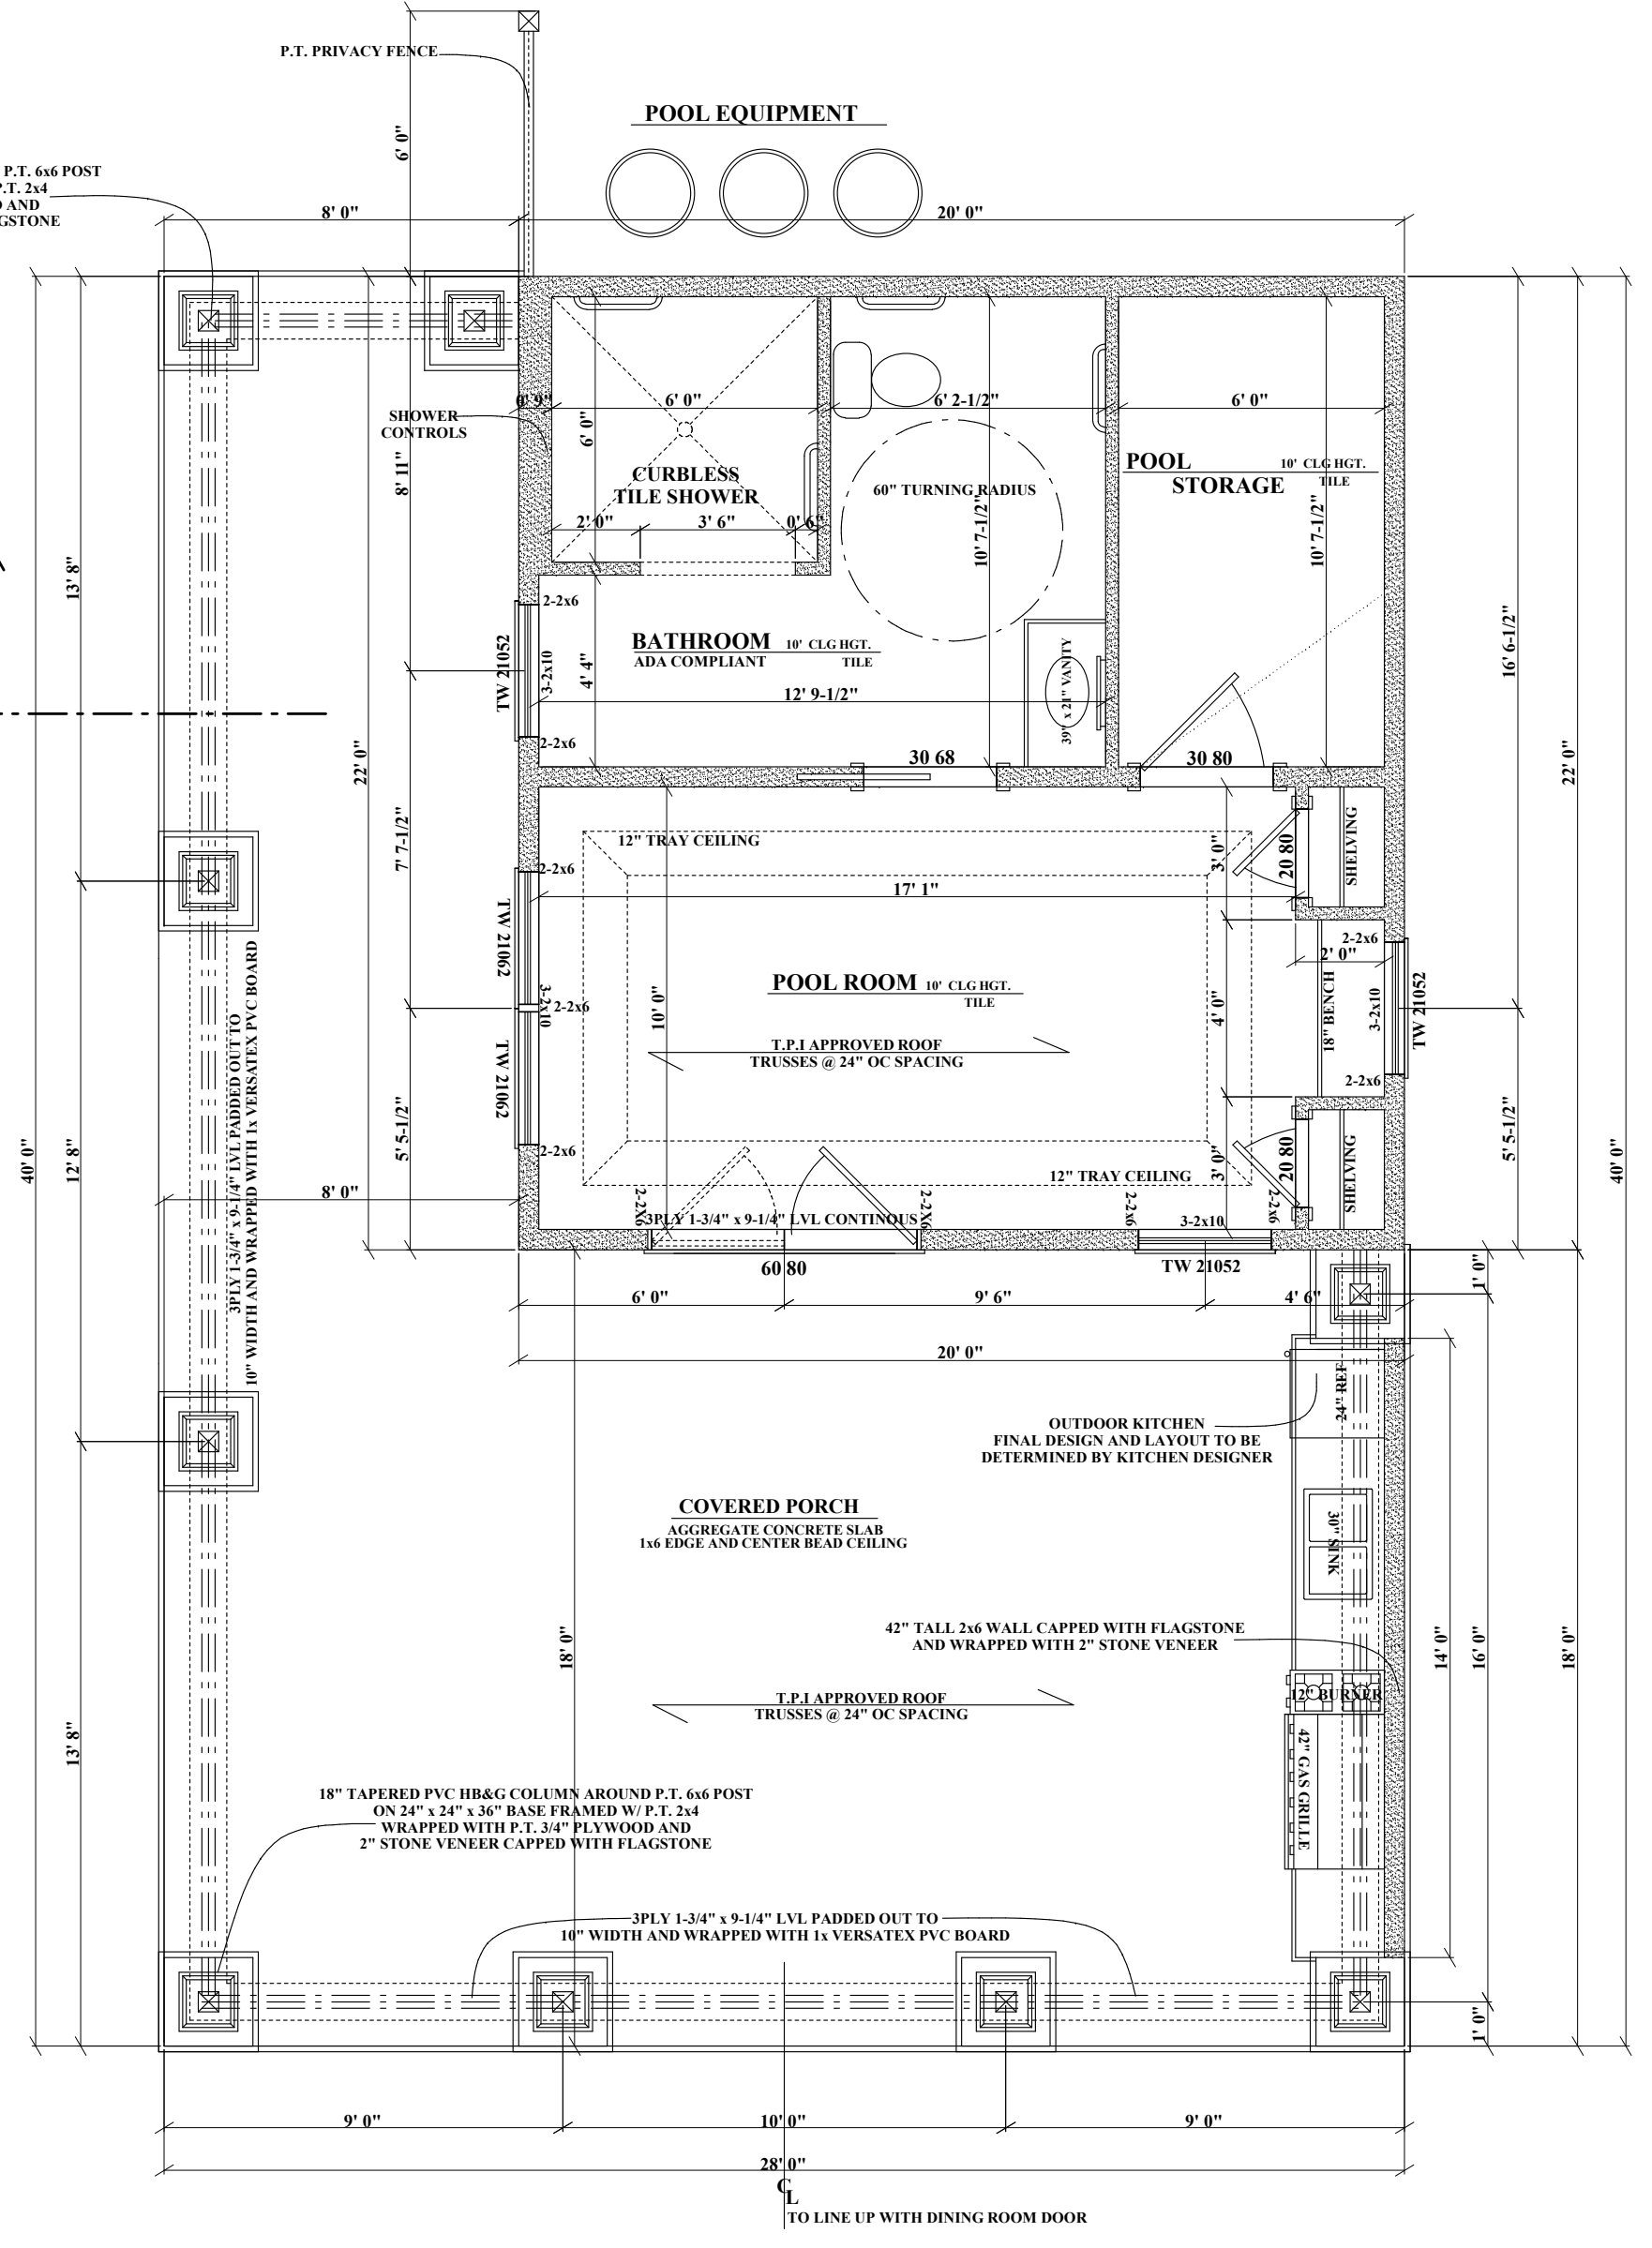

FLOOR PLAN

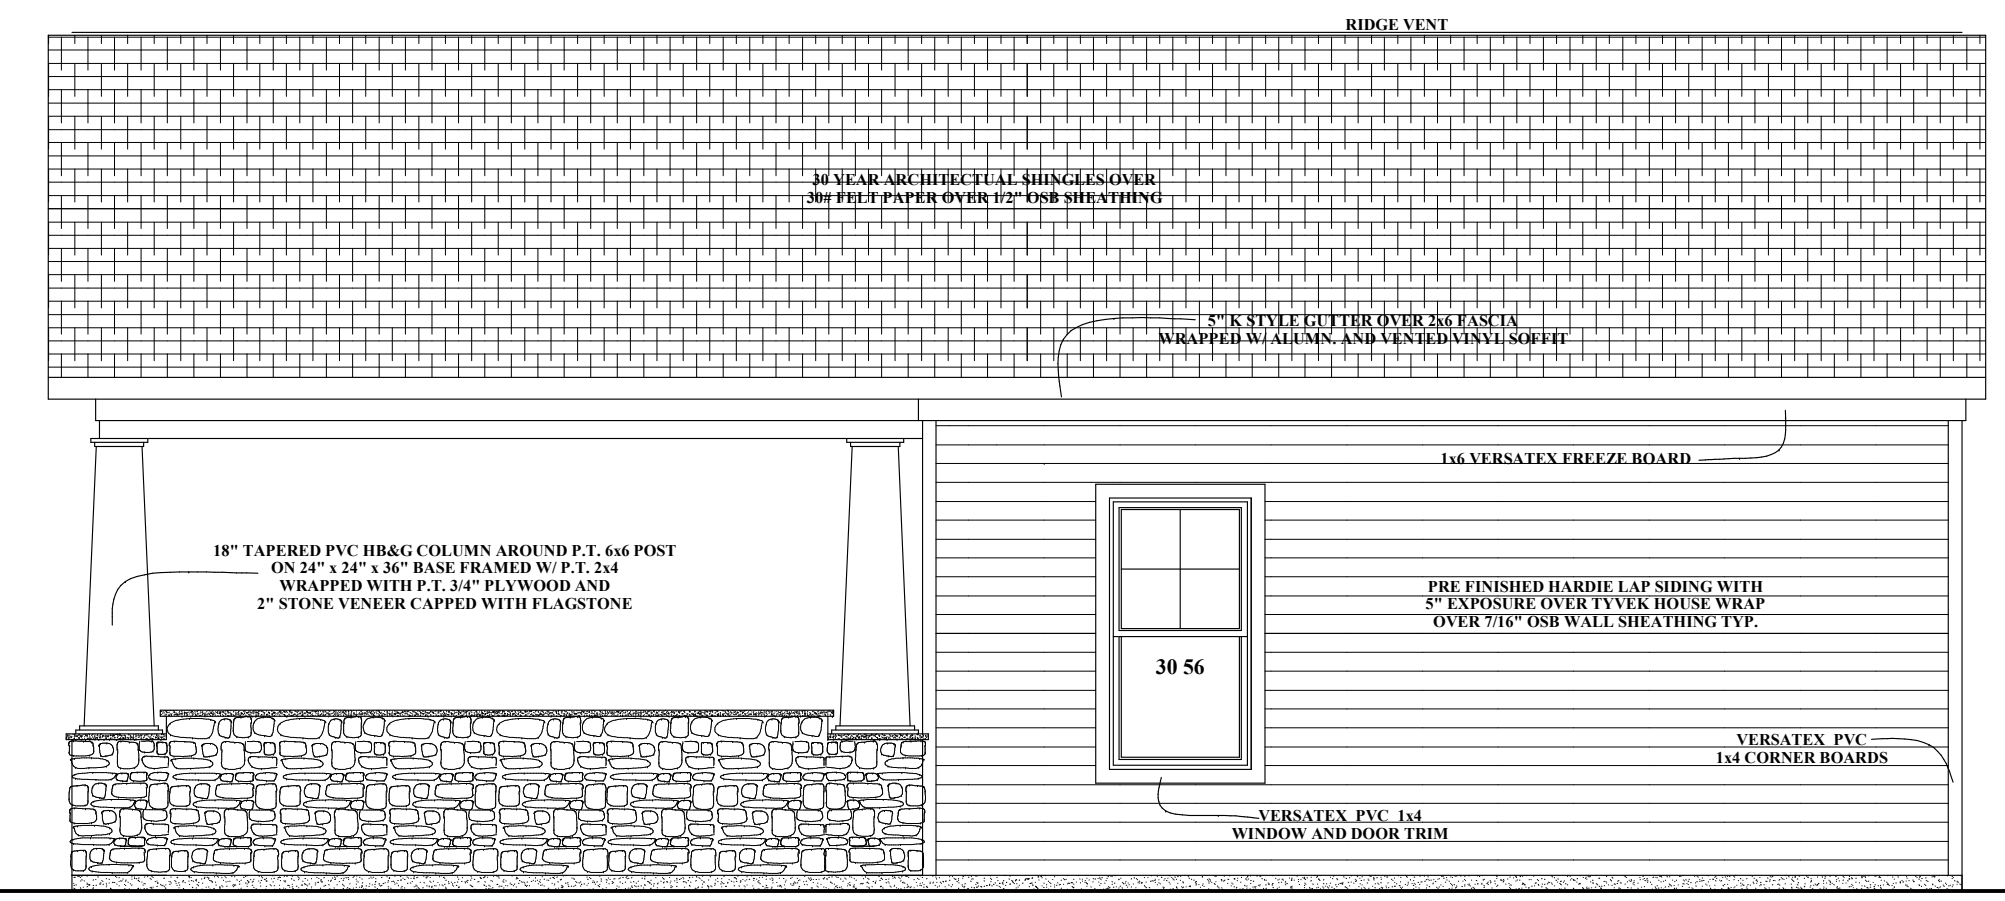

REAR ELEVATION

RB HOME DESIGN L.L.C
2061 D MOUNT HORE RD STREET MD 21154
RBHOMEDSIGN@HOTMAIL.COM
443-613-5115

THE CONTRACTOR IS RESPONSIBLE FOR DIMENSIONS TO BE CONFIRMED AND CORRELATED AT SITE FOR INFORMATION THAT PERTAINS SOLELY TO THE FABRICATION PROCESSES OR TO THE MEANS, METHODS, TECHNIQUES, SEQUENCES, AND PROCEDURES OF CONSTRUCTION OF THE WORK OF ALL TRADES

RB HOME DESIGNS

DATE :

SCALE : 1/4" = 1'

DRAWN : R. BREDLOW

POOL HOUSE PLANS

SHEET NO.

A-14