



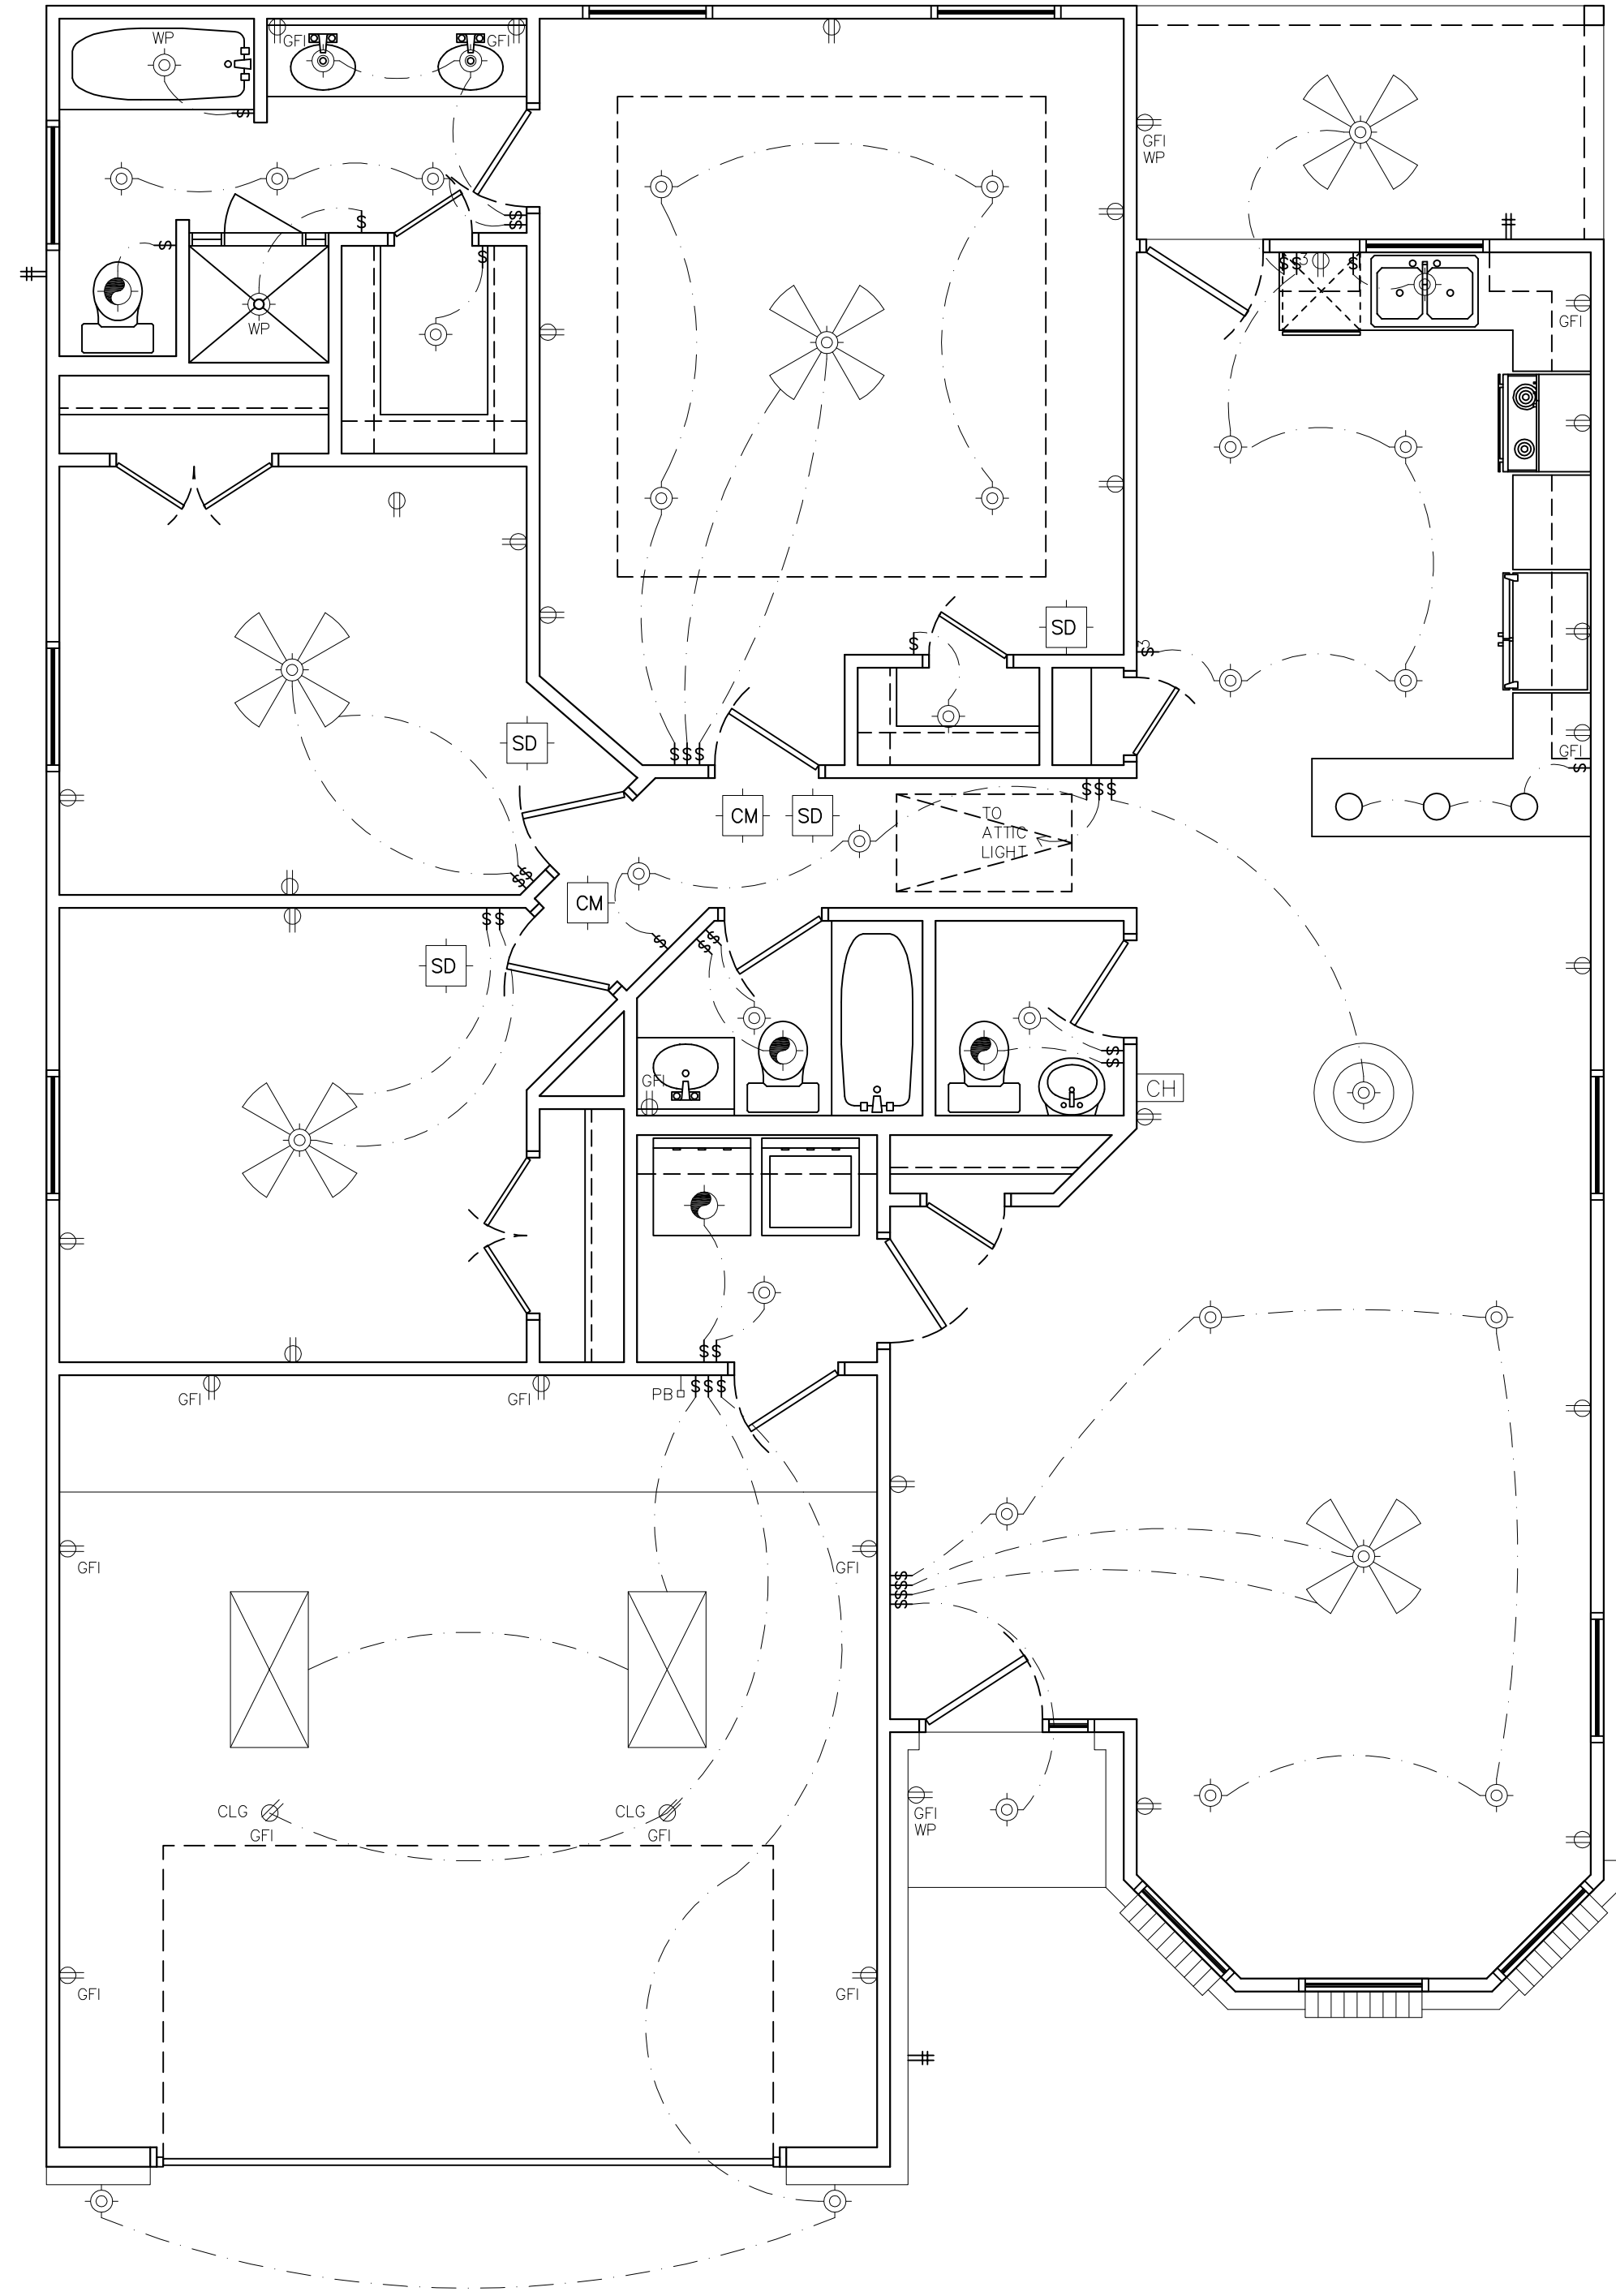

ELECTRICAL LAYOUT

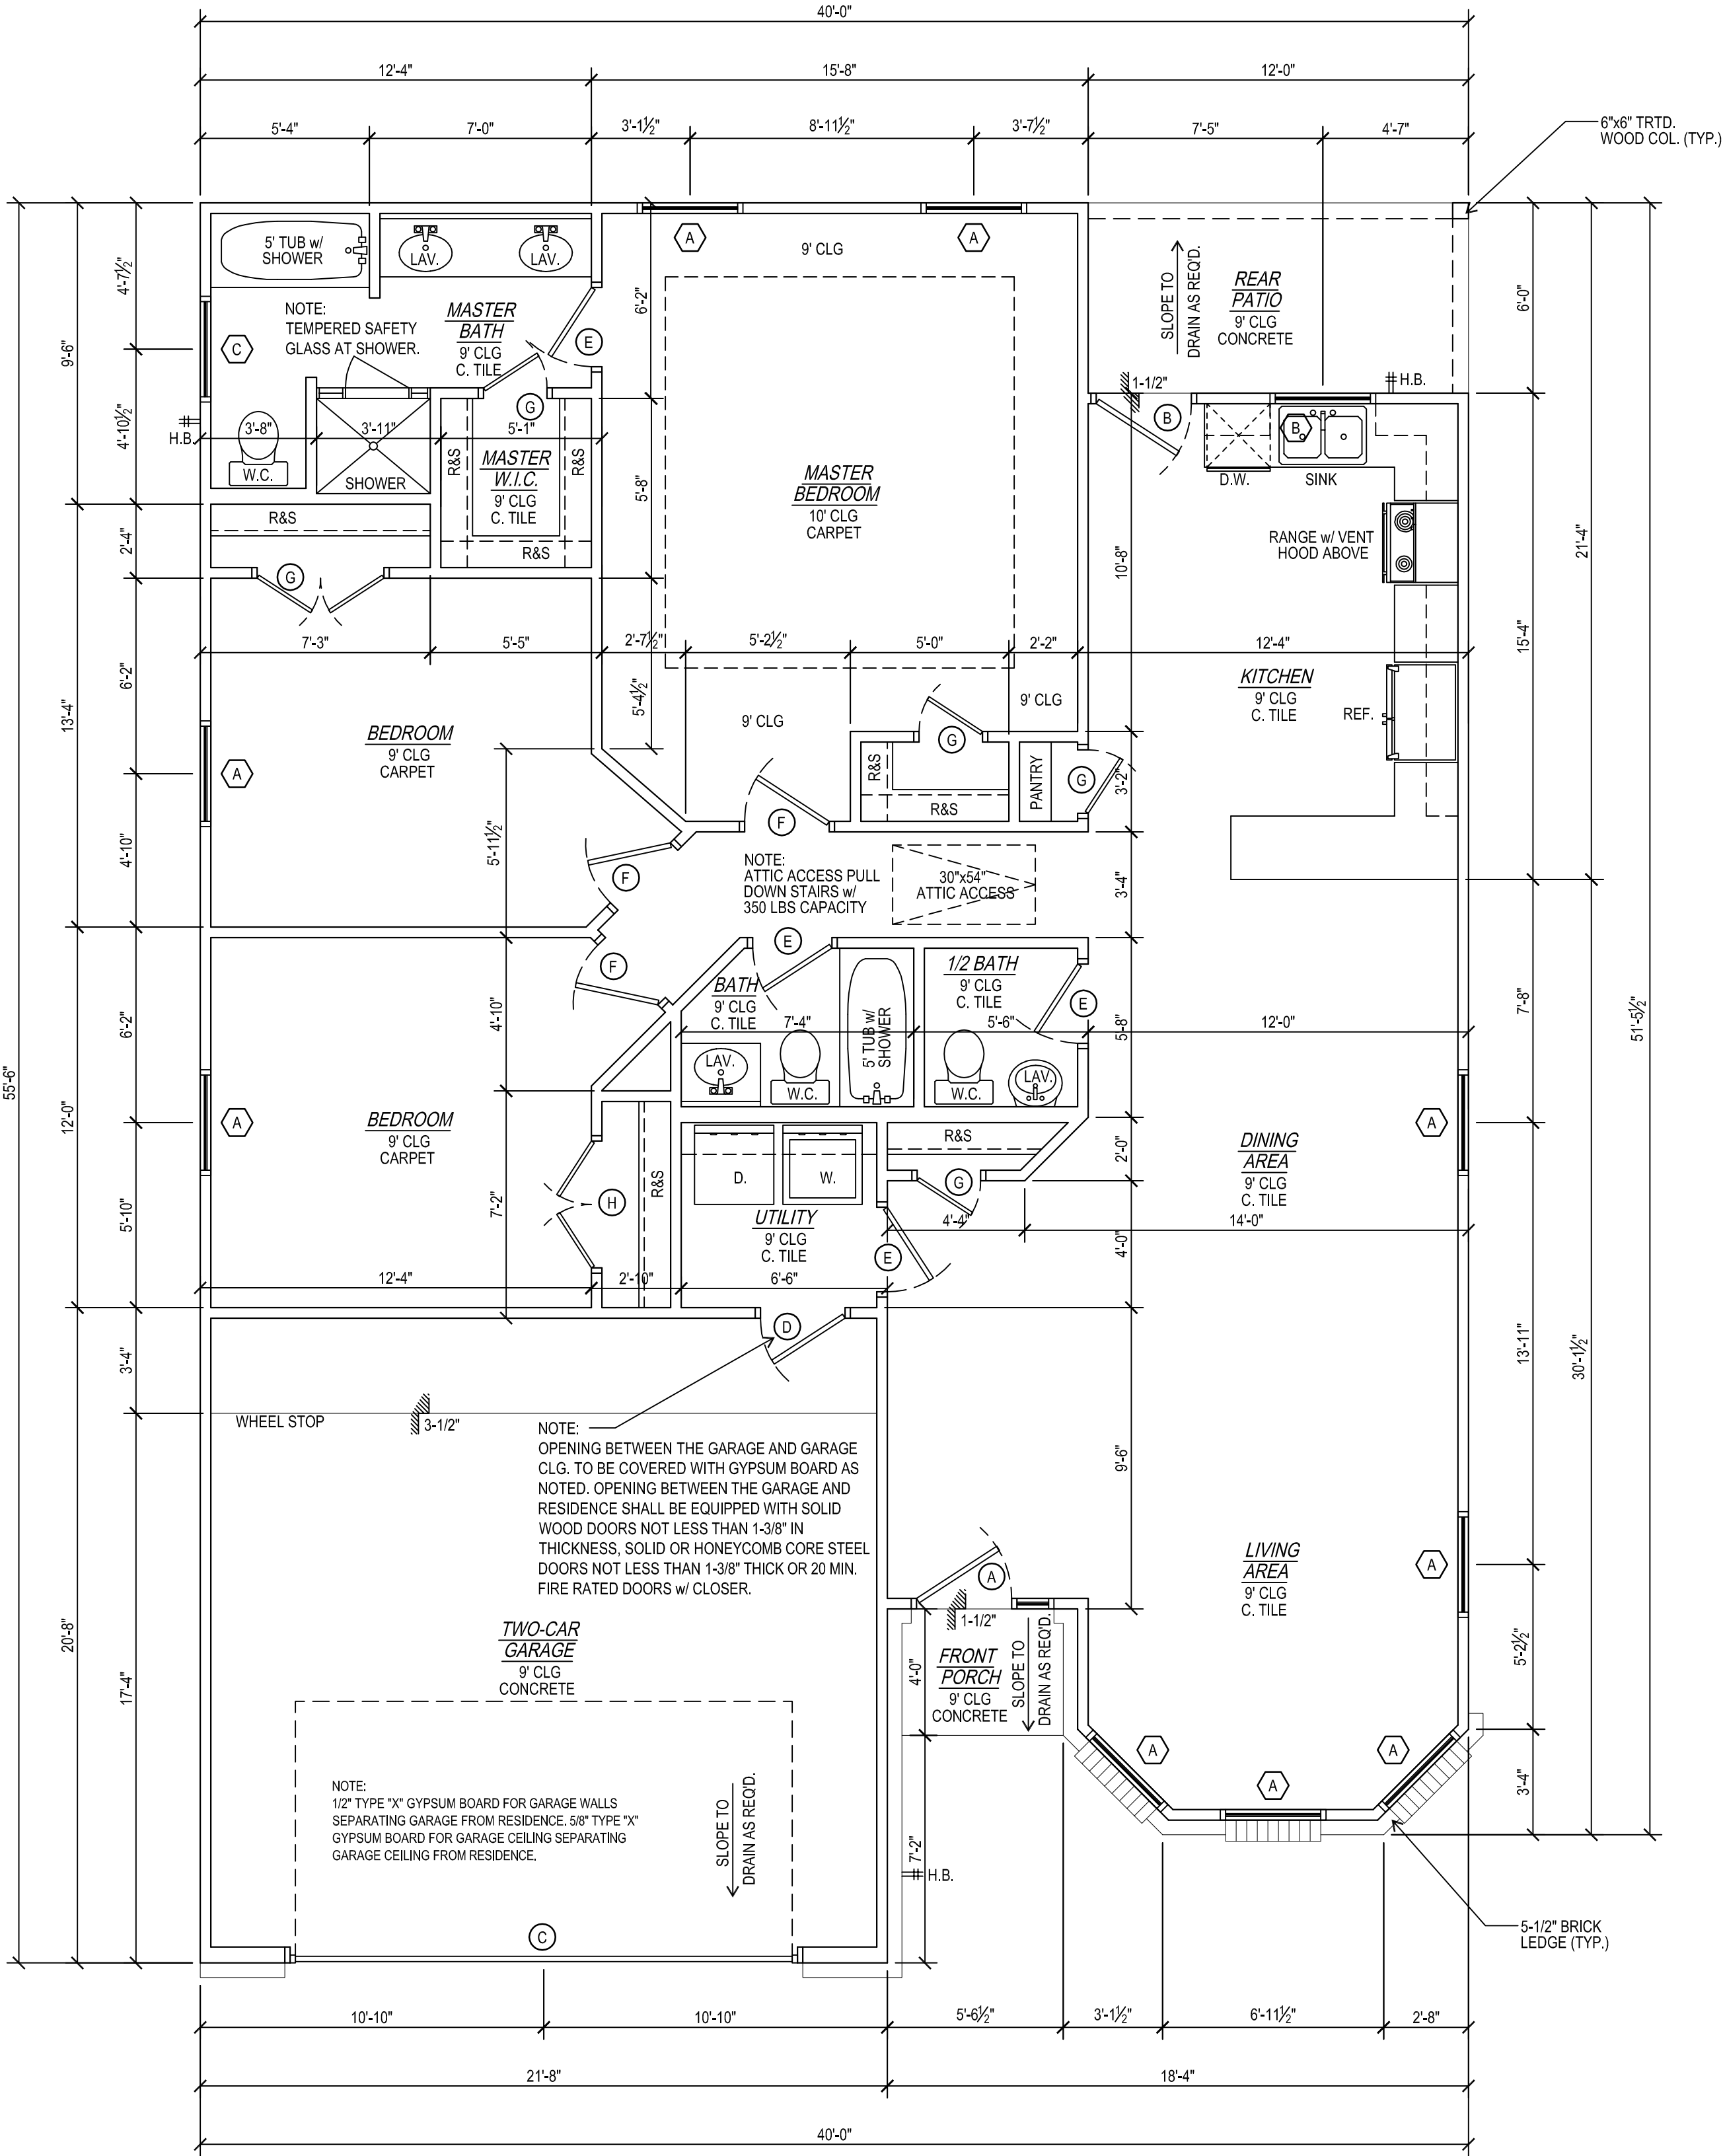

FLOOR PLAN

FLOOR PLAN
SCALE: 1/4" = 1'-0"



P.O. Box 165
Houston, Texas 77587
Ph: (832)407-4879
info@diazdesignbuild.com

copyright diaz design & build, llc, all rights reserved, the duplication, reproduction, copying, sale, rental, licensing, or other distribution or use of these drawings, any portion thereof, or the plans depicted hereon is strictly prohibited unless expressly authorized in writing by diaz design & build, llc. diaz design & build, llc is not to be held responsible for the architectural and structural design in any way or matter.

SINGLE-FAMILY RESIDENCE
AT
2826 Orion St
Houston, Texas 77088
A Project for:
Mr. Randy Diggs

PROFESSIONAL SEAL

DESIGNED BY: LRD		
DATE: 10/27/2021		
JOB NO: DDB-20211021		
REVISIONS		
NO.	DATE	DESCRIPTION

SHEET TITLE:
FLOOR PLAN
DRAWING NUMBER:
A1