

PAUL CARPENTER DAVIS
ARCHITECTURE, P.C.

DRAWING INDEX	
<u>GENERAL</u>	
G101	COVER SHEET WITH SITE PLAN
<u>STRUCTURAL</u>	
S1.0	FOUNDATION PLAN
S2.0	FRAMING & SHEARWALL PLAN
<u>ARCHITECTURAL</u>	
A101	FLOOR PLAN, CEILING PLAN, ROOF PLAN, ELEVATIONS, & DETAILS




ARCHITECTURAL SITE PLAN
SCALE: 1/8" = 1'-0"



ALL SETBACKS TO BE VERIFIED WITH OWNER - PARADISE RV



Paradise RV Pavilion

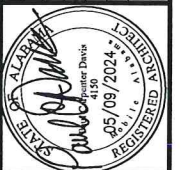[illegible]

Sheet Title:

COVER SHEET
WITH SITE PLAN

Project Number:

2023-58


Date: September 19, 2023

Drawn By:


Checked By:

Sheet No.


G101

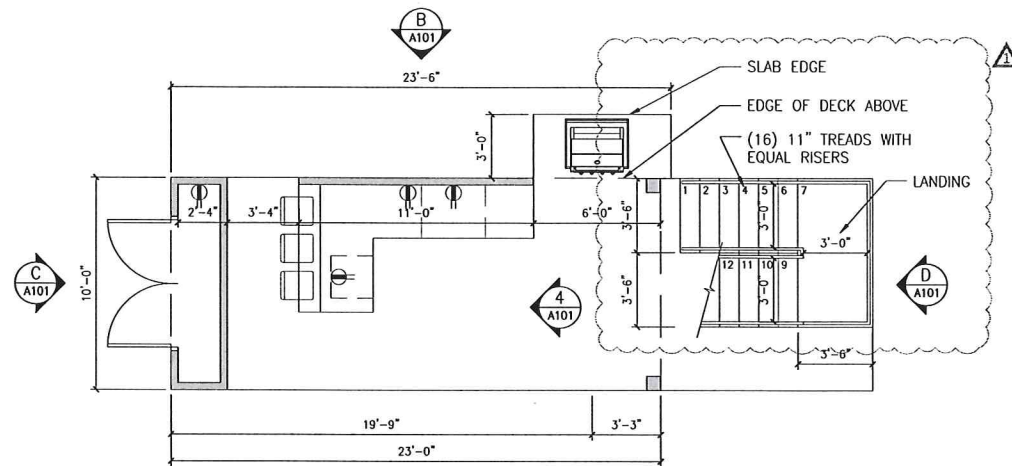


1 FLOOR PLAN
SCALE: 1/4" = 1'-0"

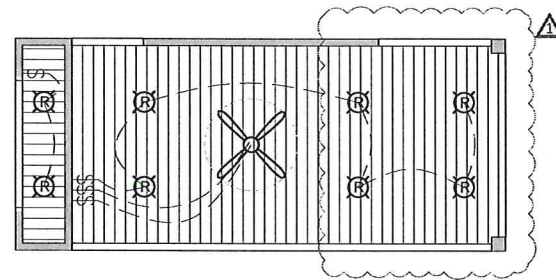

2 CEILING & ELECTRICAL PLAN
SCALE: 1/4" = 1'-0"

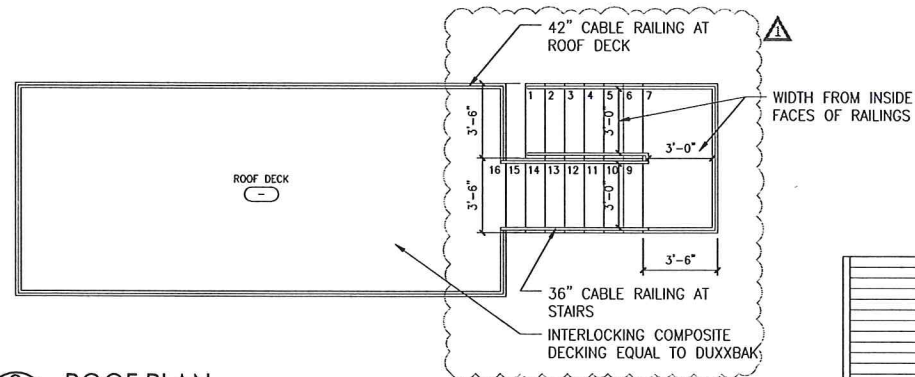


3 ROOF PLAN
SCALE: 1/4" = 1'-0"

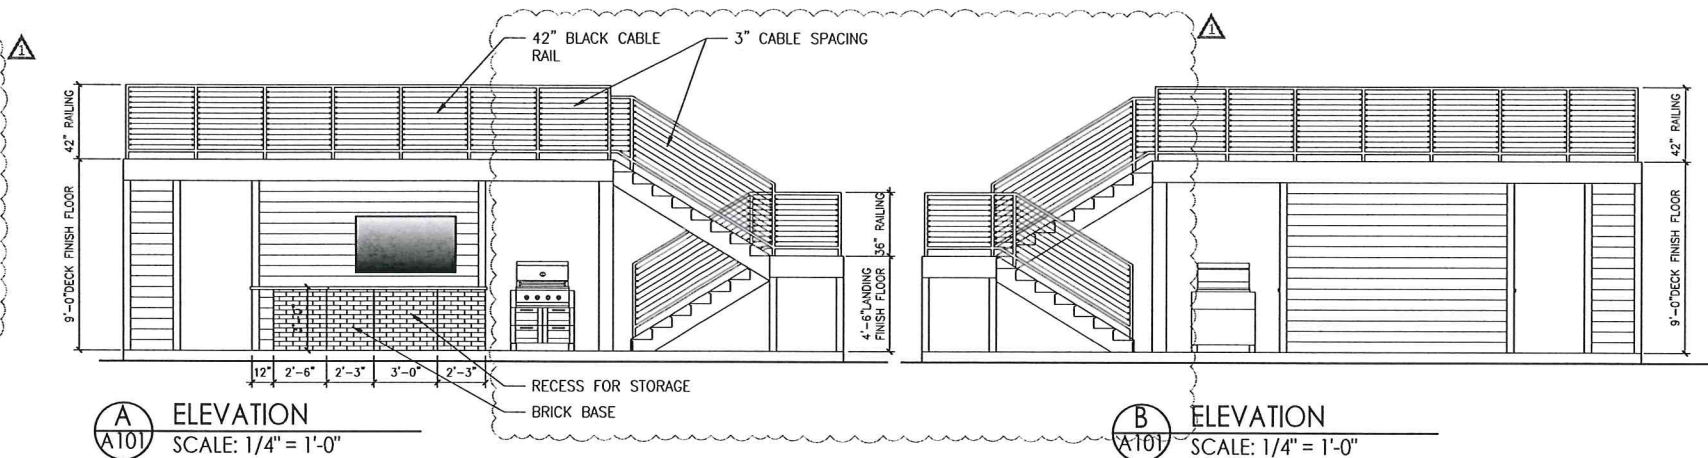


A ELEVATION
SCALE: 1/4" = 1'-0"


B ELEVATION
SCALE: 1/4" = 1'-0"

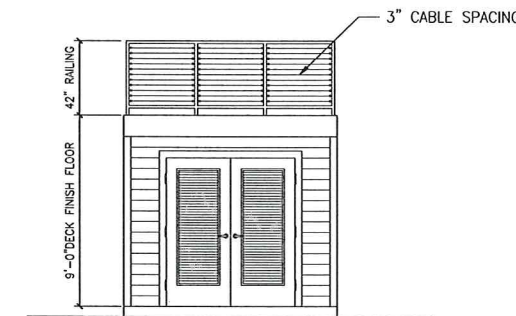


C ELEVATION
SCALE: 1/4" = 1'-0"

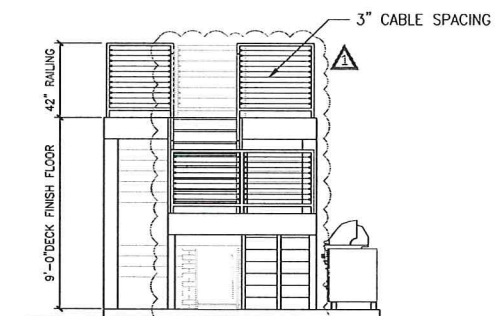



D ELEVATION
SCALE: 1/4" = 1'-0"

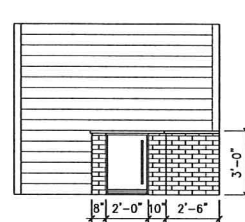

4 INTERIOR ELEVATION
SCALE: 1/4" = 1'-0"

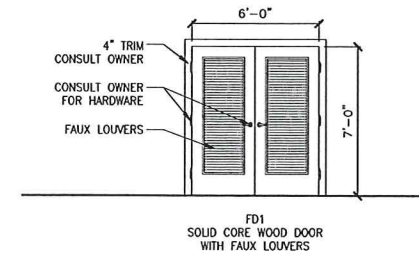


5 DOOR DETAIL
SCALE: 1/4" = 1'-0"

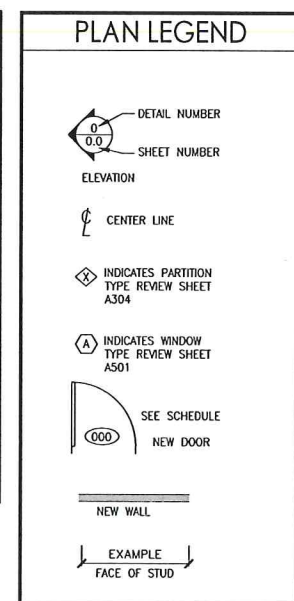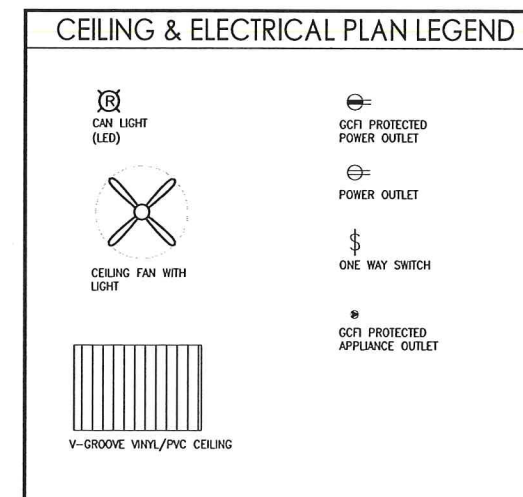

756 Saint Louis Street
Mobile, Alabama 36602
(251) 432-3480

Paradise RV Pavilion

REV	DATE	BY	DESCRIPTION	CHK	ENGR	APPR
1	07/16/24	JCB	CHANGES PER COMMENTS	PCD		PCD

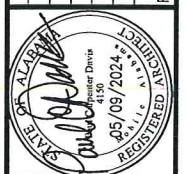

Sheet Title:	FLOOR PLAN, CEILING PLAN, ELEVATIONS
Project Number:	2023-58
Date:	September 19, 2023
Drawn By:	JCB
Checked By:	PCD
Sheet No.:	A101