


2 SECOND FL. MECHANICAL PLAN
SCALE: 1/4" = 1' - 0"

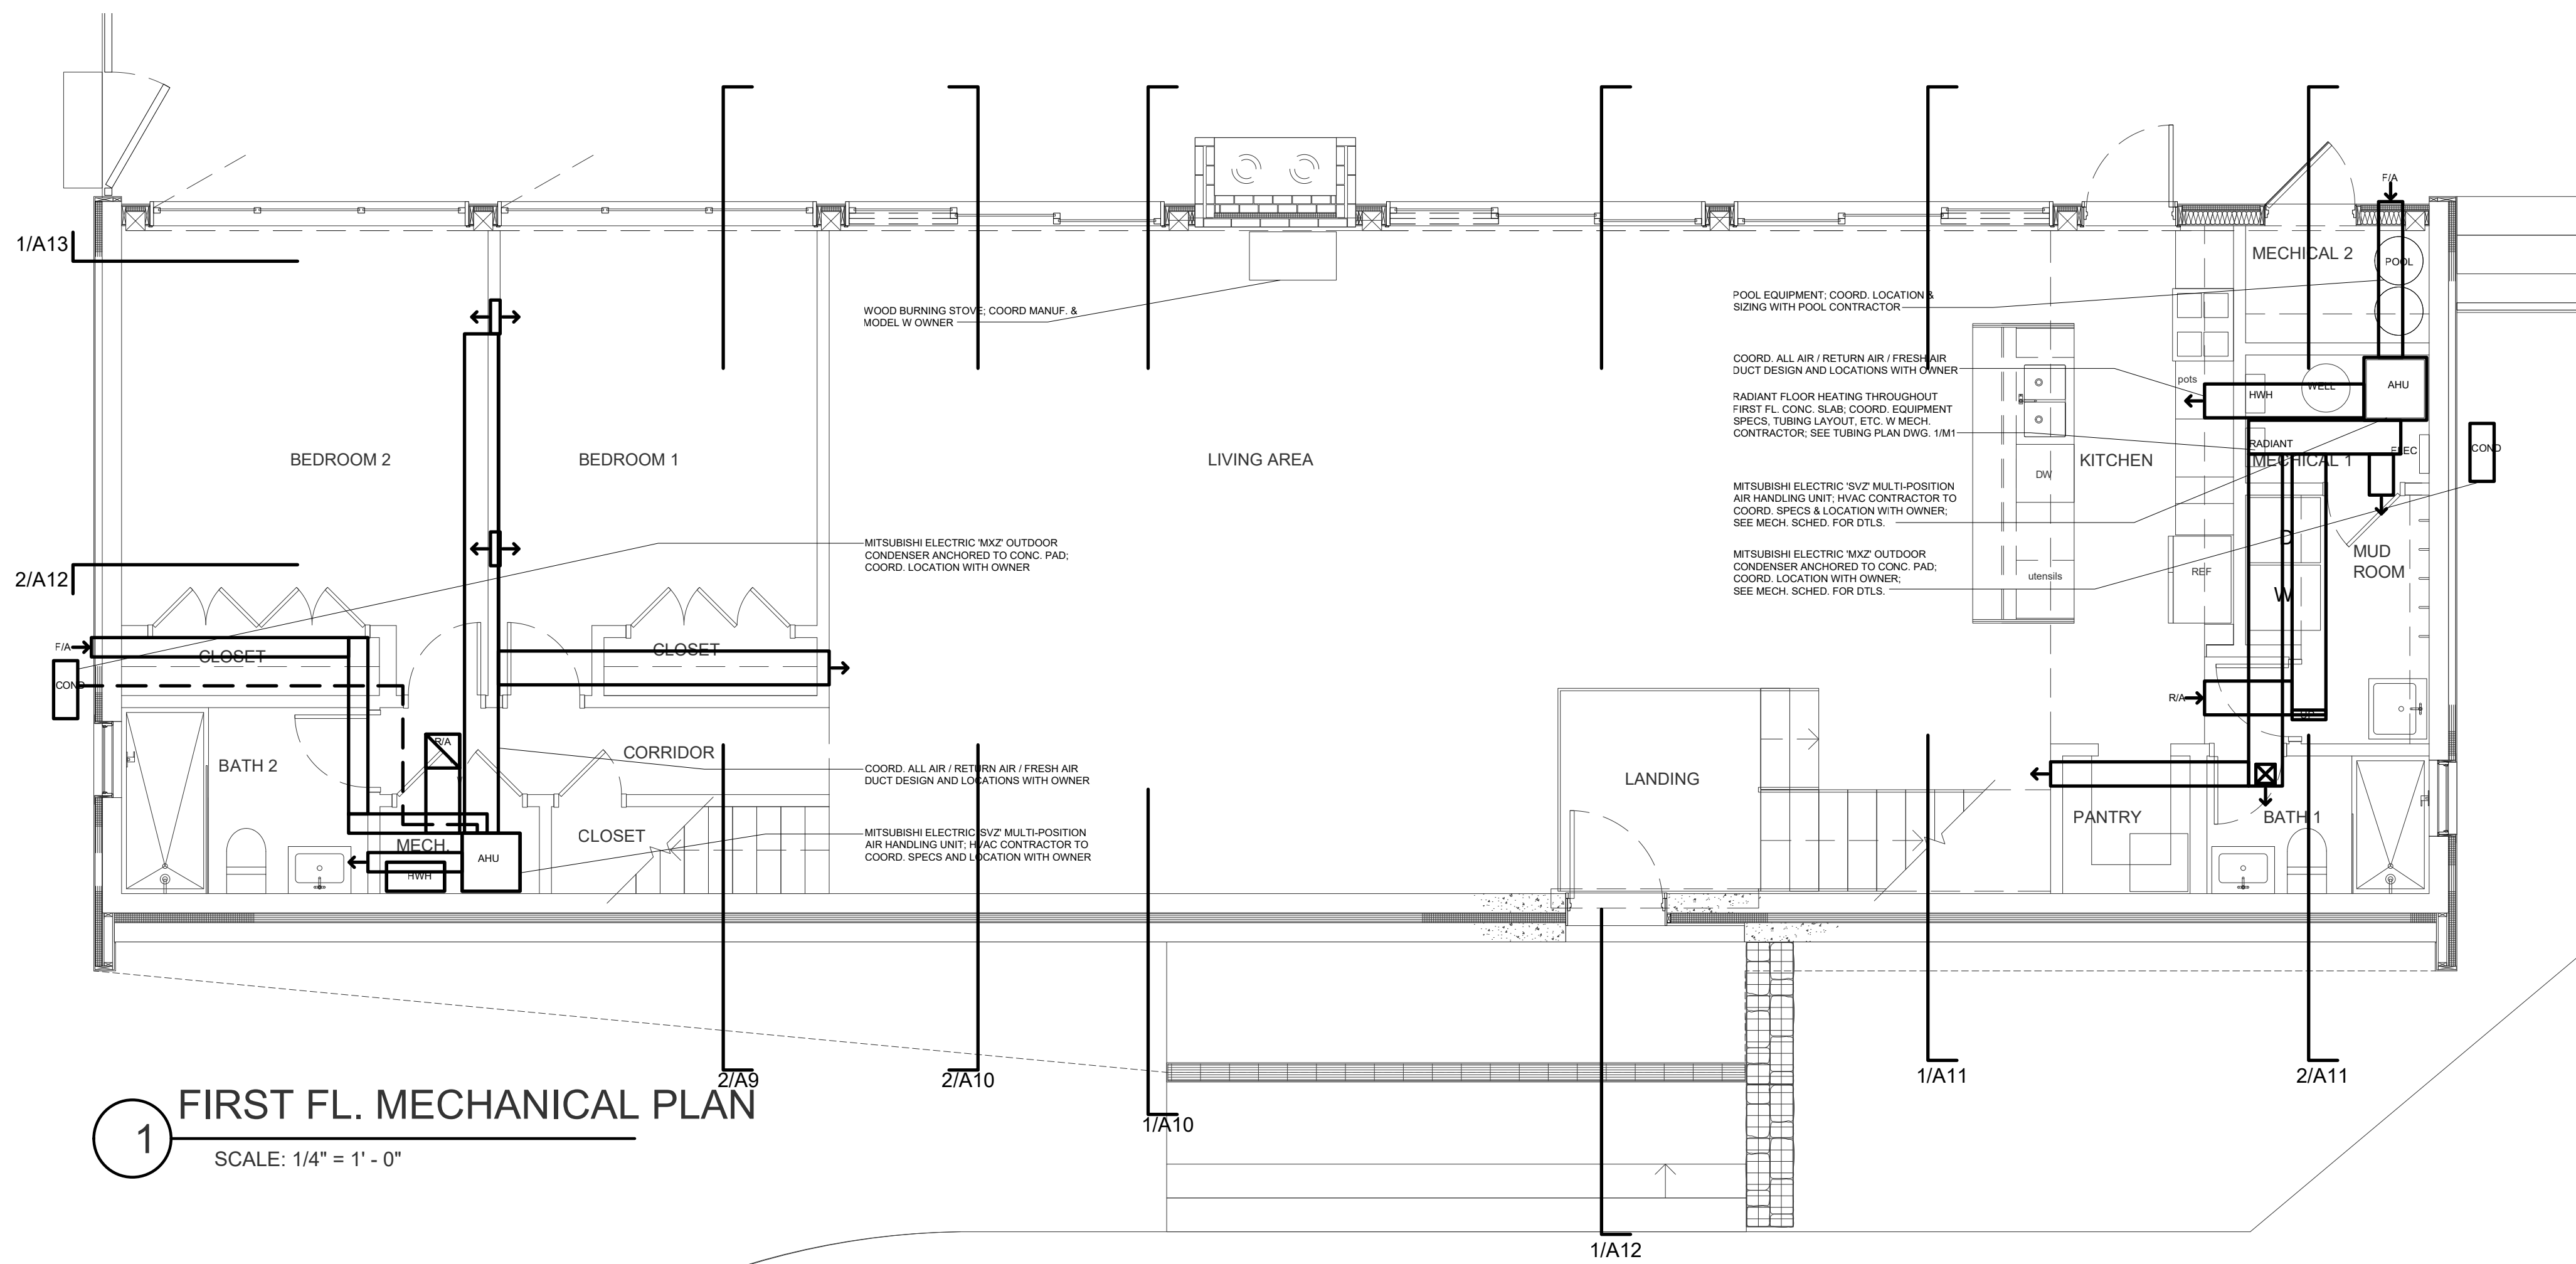

1 FIRST FL. MECHANICAL PLAN
SCALE: 1/4" = 1' - 0"

COORDINATE ALL MECHANICAL EQUIPMENT SIZING, LOCATIONS, DUCT SIZING, ETC. WITH MECH. CONTRACTOR

ARCHITECT:
P. 808. 206. 8883 E. ben@broadloomcreative.com
296 J. OLD YORK RD. BRIDGEWATER, NJ 08807
BENJAMIN WALKER - N.Y. LICENSE #031565
BROADLOOM ARCHITECTURE DPC

OWNER MAILING ADDRESS:
DEMIAN REPUGGI
265 RIVERSIDE DR #2F
NEW YORK, NY 10025

PROJECT:
REPUGGI RESIDENCE
DEMIAN REPUGGI
600 MILL ROAD
ELKA PARK, NY 12427
BLOCK: 182.00-3-33 LOT: 3
DRAWN BY: BW CHECKED BY: BW

DRAWING:
PROPOSED SECOND FLOOR PLAN &
ROOF PLAN

ISSUE:
PERMIT SUBMISSION
ISSUE FOR PRICING

DATE:
10.04.2021
12.02.2021