


2 SECOND FL. PLUMBING PLAN
SCALE: 1/4" = 1' - 0"

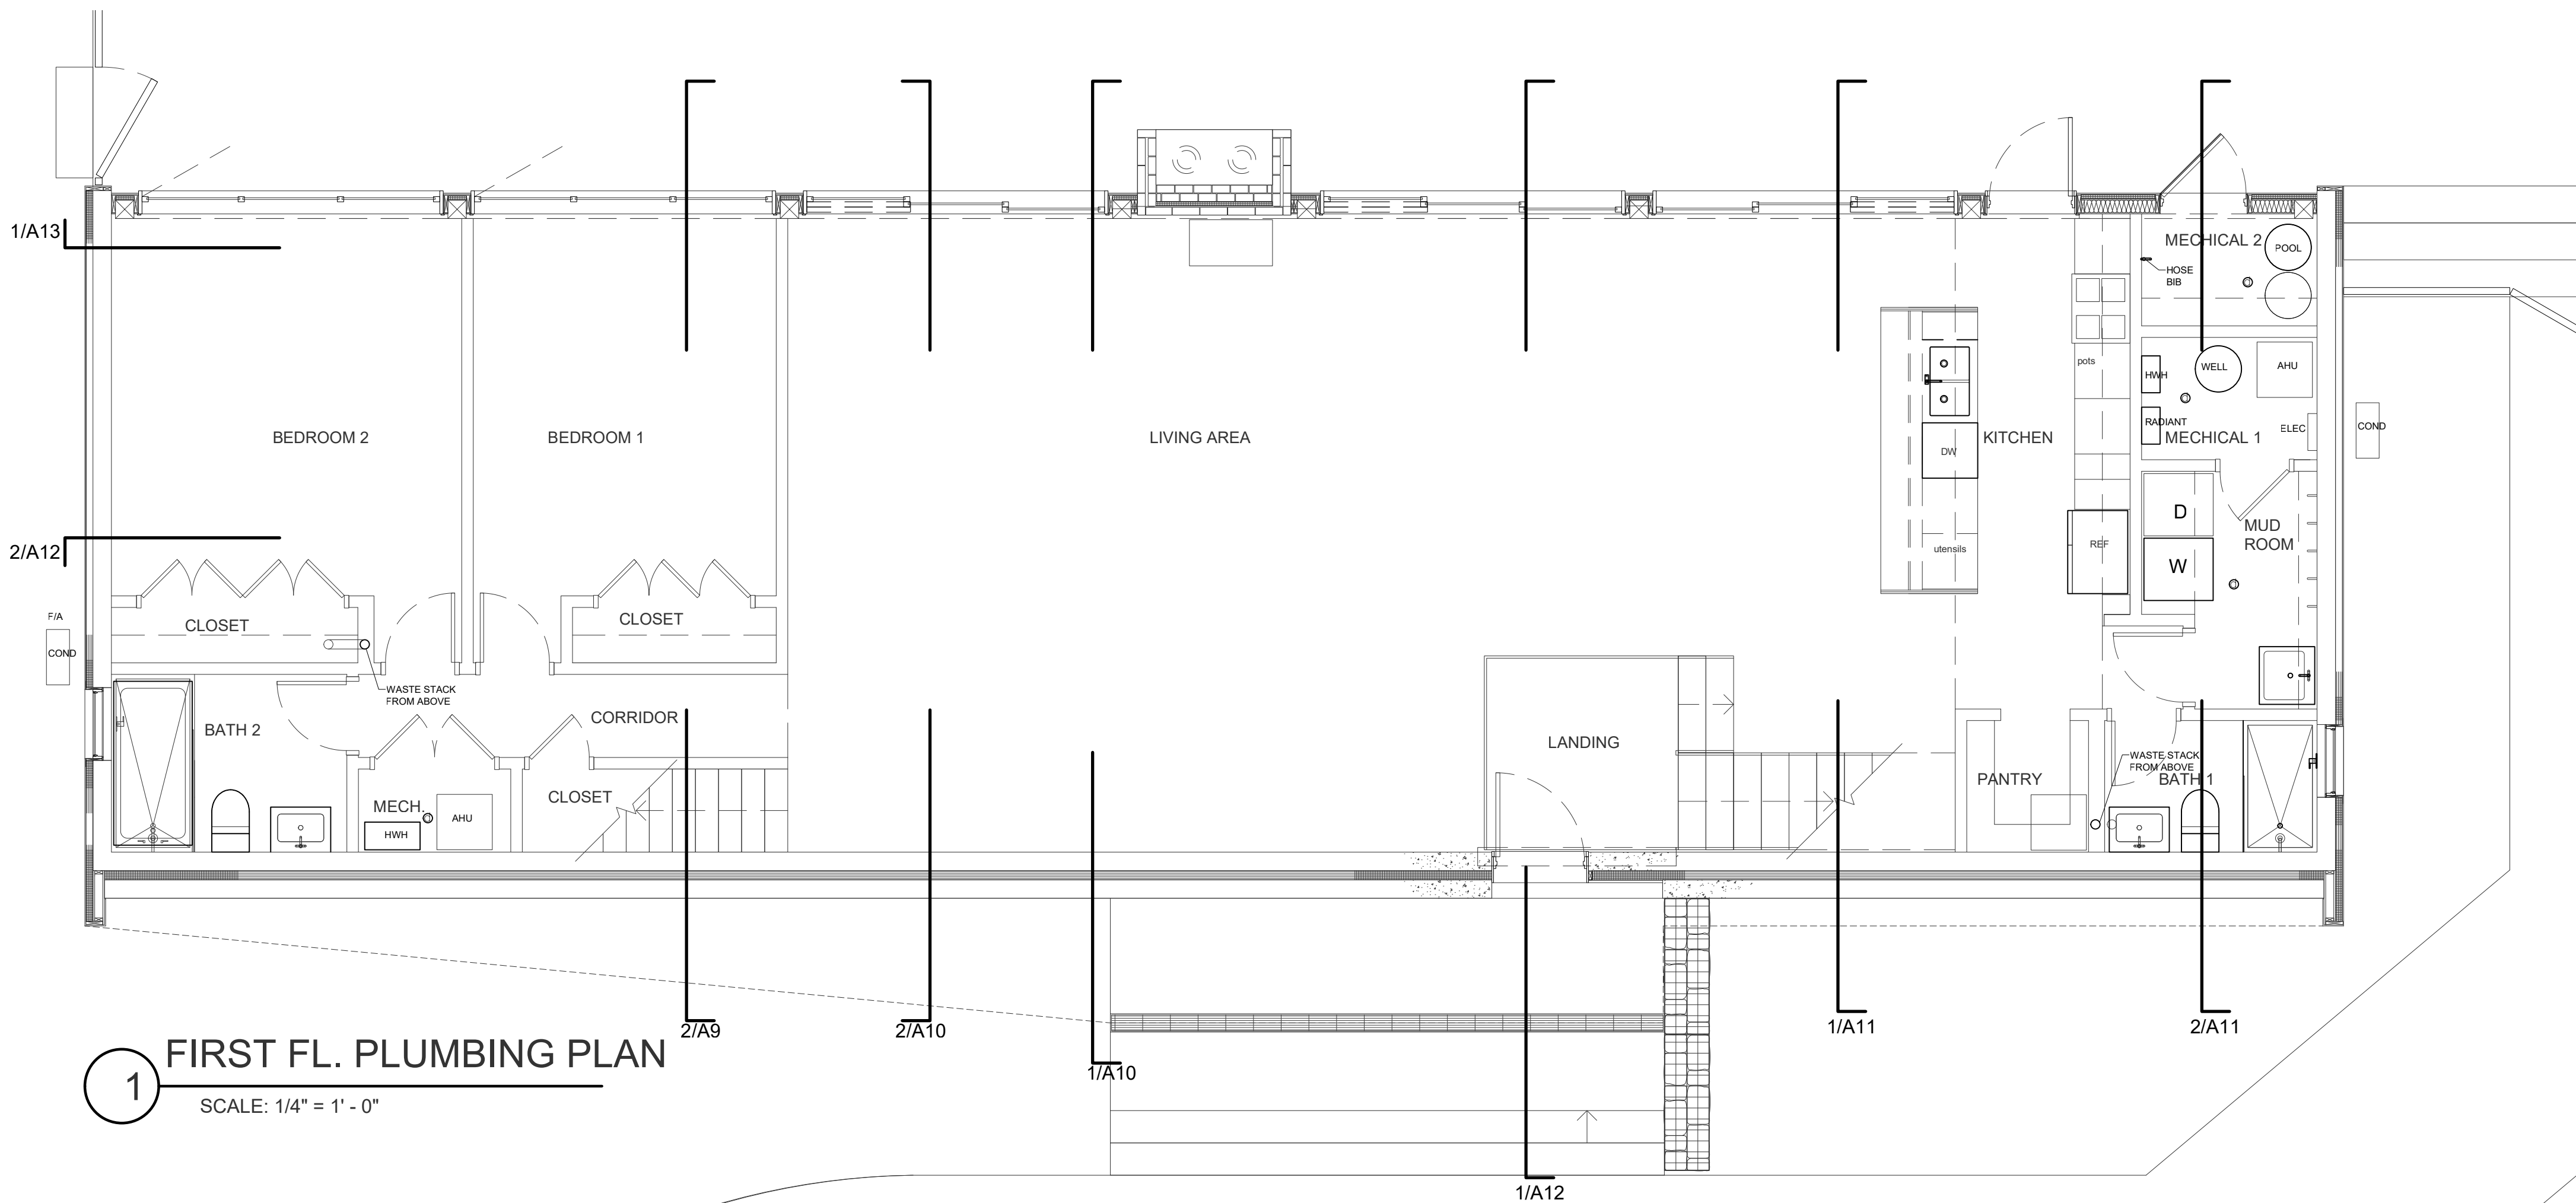

1 FIRST FL. PLUMBING PLAN
SCALE: 1/4" = 1' - 0"

COORDINATE ALL PLUMBING FIXTURES, SUPPLY AND DRAIN SIZING, LOCATIONS, ETC. WITH PLUMBING CONTRACTOR

ARCHITECT:	P. 908. 206. 8983 E. ben@broadloomcreative.com 286 J OLD YORK RD. BRIDGEWATER, NJ 08807 BENJAMIN WALKER - N.Y. LICENSE #031365 BROADLOOM ARCHITECTURE DPC
OWNER MAILING ADDRESS:	DEMIAN REPULCCI 285 RIVERSIDE DR #2F NEW YORK, NY 10025
PROJECT:	REPULCCI RESIDENCE DEMIAN REPULCCI, HILL ROAD ELKA PARK, NY 12427 BLOCK: 182.00-3-33 LOT: 3 DRAWN BY: BW CHECKED BY: BW
DRAWING:	PROPOSED SECOND FLOOR PLAN & ROOF PLAN
ISSUE:	FOUNDATION UPDATE
DATE:	05.12.2022