



BERGMANN HOTEL AS BUILT

For
for owner David D'Amato

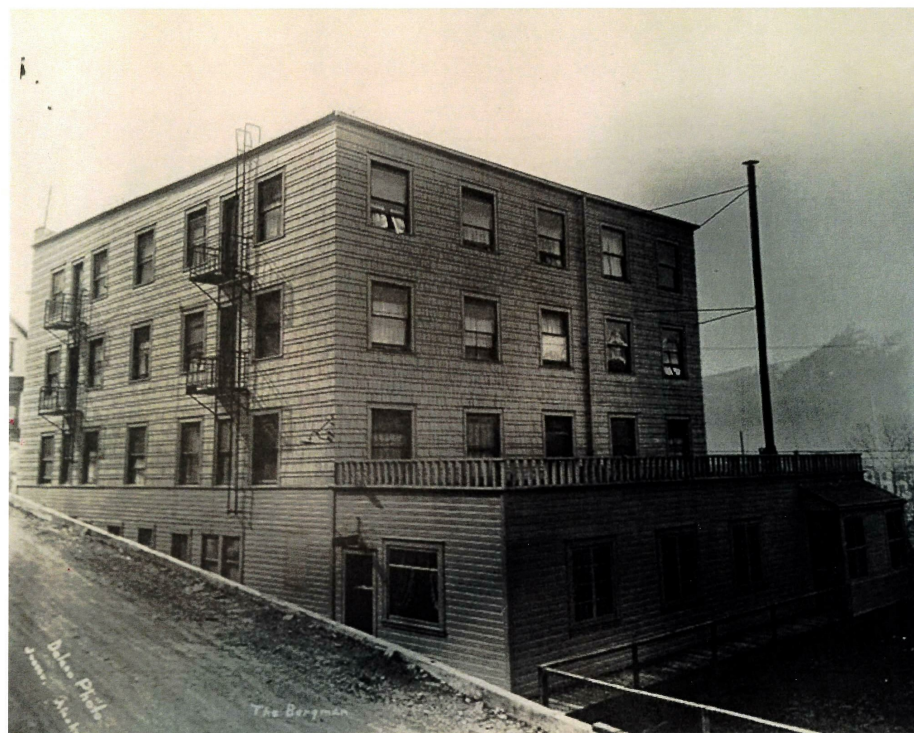


AUGUST 2021 MRV ARCHITECTS
AS-BUILT DRAWINGS

8/24/2021 5:16:32 PM C:\Users\MRV\Documents\BERGMAN HOTEL as_built_MRVcentral_HEATHER.rvt

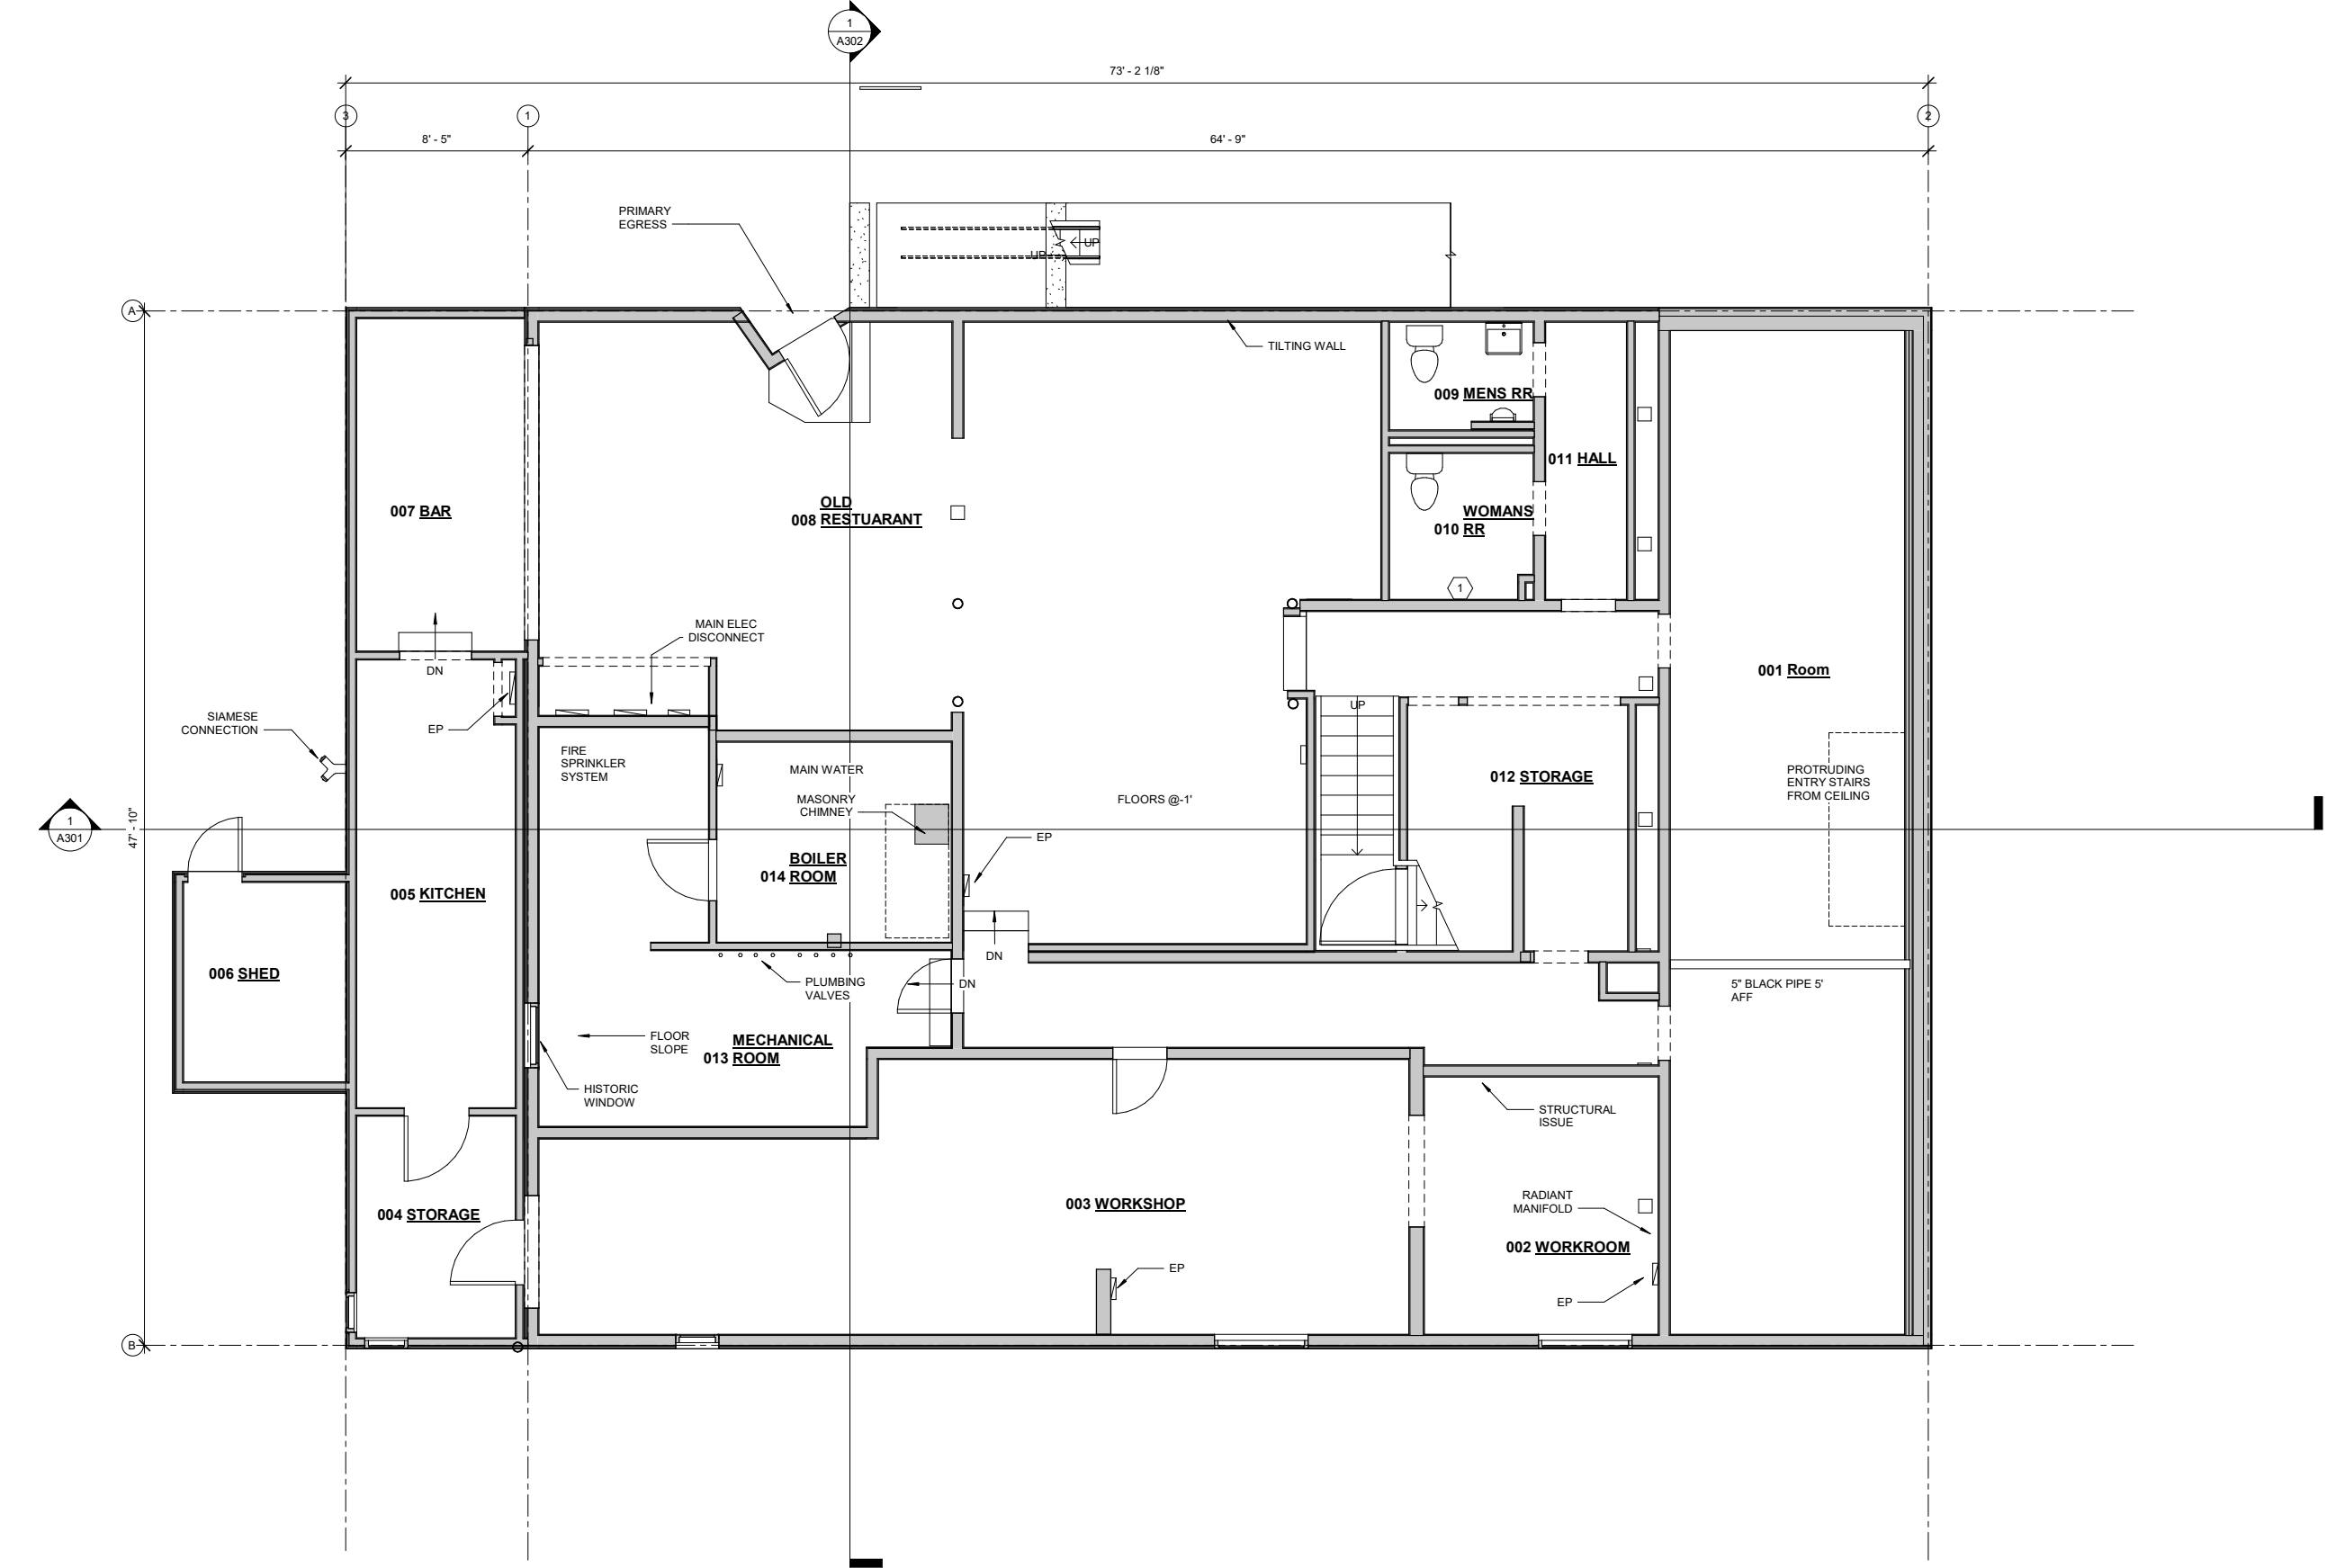

SHEET NOTES:
1 SINK PLUMBING HOOKUPS

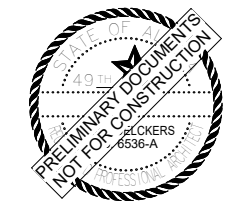

MRV
ARCHITECTS
ARCHITECTURE · PLANNING · INTERIORS

MRV ARCHITECTS
1420 GLACIER AVE. #101
JUNEAU, AK 99801
907-586-1371
FAX 907-463-5544
mrv@mrvarchitects.com

MRV #2113

AS-BUILT DRAWINGS 2021
BERGMANN HOTEL AS BUILT
for owner David D'Amato

No.	Description	Date

SHEET TITLE:
BASEMENT

 
DATE: 08.19.2021

DRAWN: HB
CHECKED: ZJ

SHEET NO.


A201

1 GROUND FLOOR
1/4" = 1'-0"



ACTUAL NORTH
PROJECT NORTH
NOTE: 11"x 17" PRINT IS HALF SIZE


C:\Users\MRV\Documents\BERGMAN HOTEL as_built_MRVcentral_HEATHER.rvt 8/24/2021 5:16:36 PM

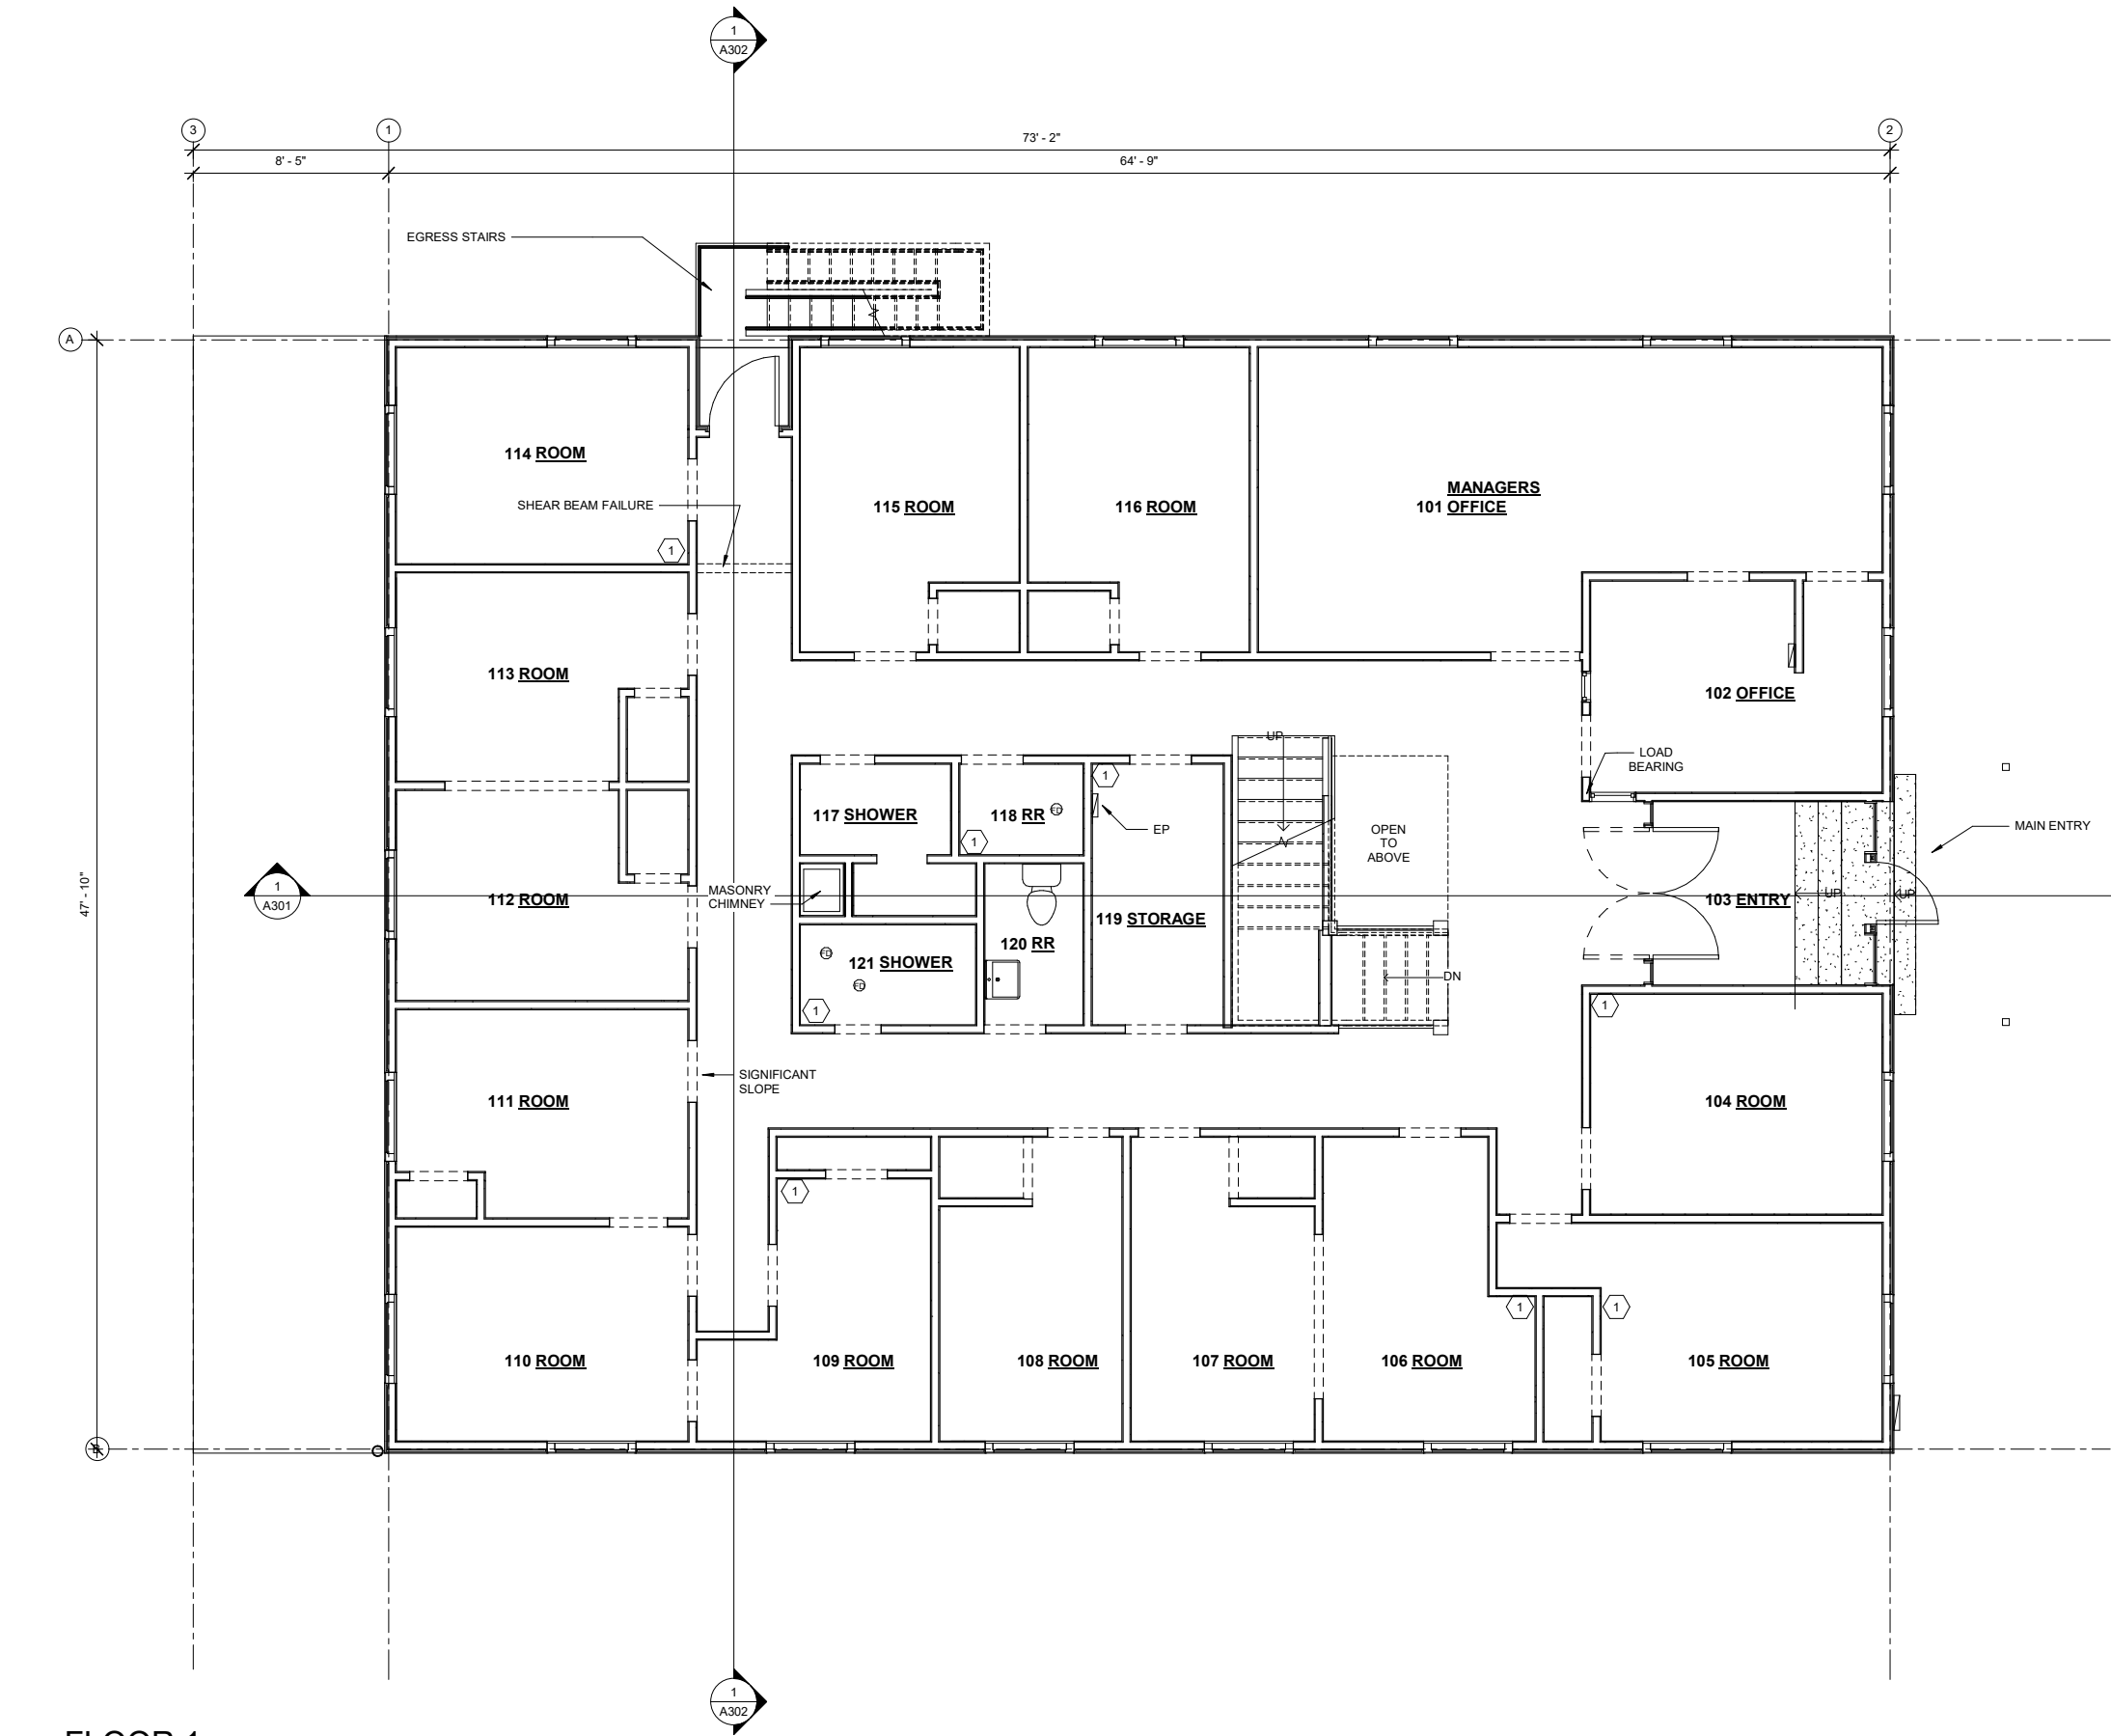

1 FLOOR 1
1/4" = 1'-0"

0' 2' 4' 8'

GENERAL NOTES
1 SINK PLUMBING HOOKUPS

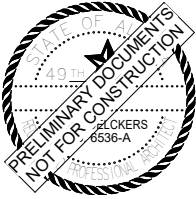

MRV
ARCHITECTS
ARCHITECTURE · PLANNING · INTERIORS

MRV ARCHITECTS
1420 GLACIER AVE. #101
JUNEAU, AK 99801
907-586-1371
FAX 907-463-5544
mrv@mrvarchitects.com

AS-BUILT DRAWINGS 2021
BERGMANN HOTEL AS BUILT

for owner David D'Amato

MRV #2113

No.	Description	Date

SHEET TITLE:
FLOOR 1

DATE: 08.19.2021

DRAWN: HB
CHECKED: ZJ


SHEET NO.

A202

ACTUAL NORTH
PROJECT NORTH

NOTE: 11"x 17" PRINT IS HALF SIZE


8/24/2021 5:16:39 PM C:\Users\MRV\Documents\BERGMAN HOTEL as built_MRVcentral_HEATHER.rvt

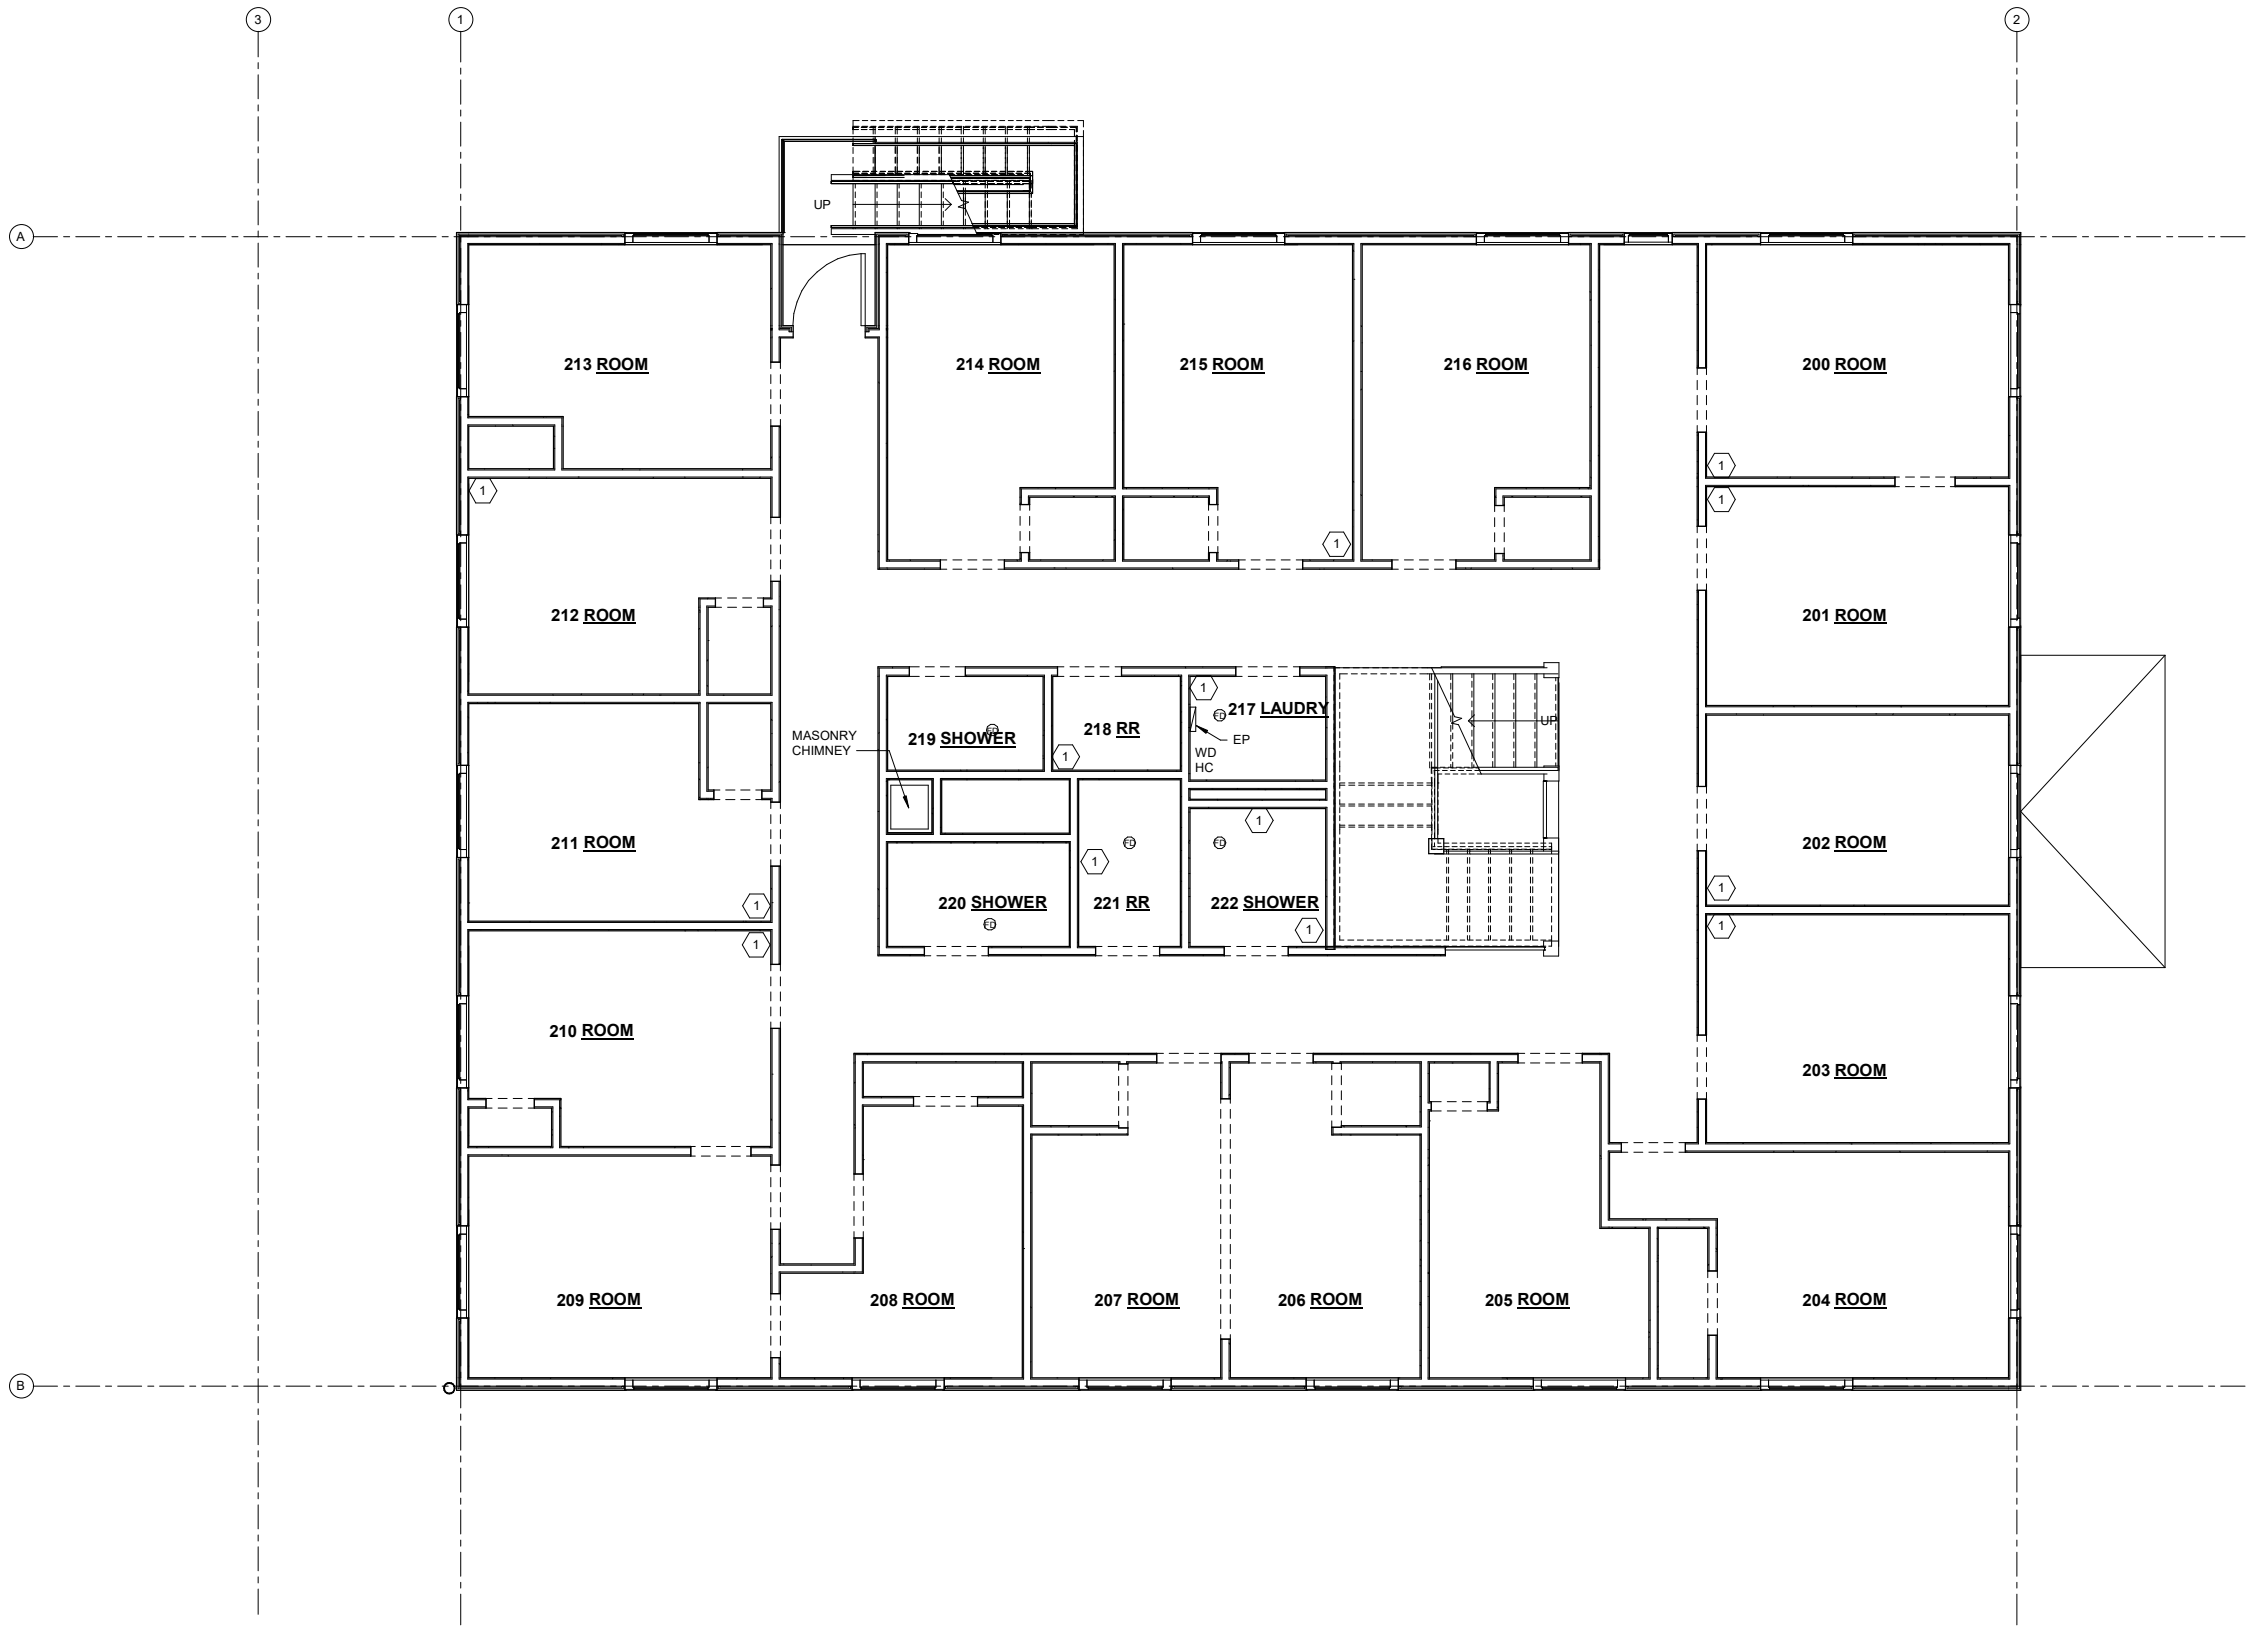

1 FLOOR 2
1/4" = 1'-0"
0' 2' 4' 8'

SHEET NOTES
1 SINK PLUMBING FIXTURE

ACTUAL NORTH PROJECT NORTH
NOTE: 11"x 17" PRINT IS HALF SIZE

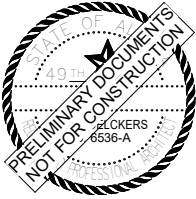

MRV ARCHITECTS
1420 GLACIER AVE. #101
JUNEAU, AK 99801
907-586-1371
FAX 907-463-5544
mrv@mrvarchitects.com

AS-BUILT DRAWINGS 2021
BERGMANN HOTEL AS BUILT
for owner David D'Amato
MRV #2113

No.	Description	Date


SHEET TITLE:
FLOOR 2

DATE: 08.19.2021

DRAWN: HB
CHECKED: ZJ

SHEET NO.
A203

C:\Users\MRV\Documents\BERGMAN HOTEL as built_MRVcentral_HEATHER.rvt 8/24/2021 5:16:41 PM

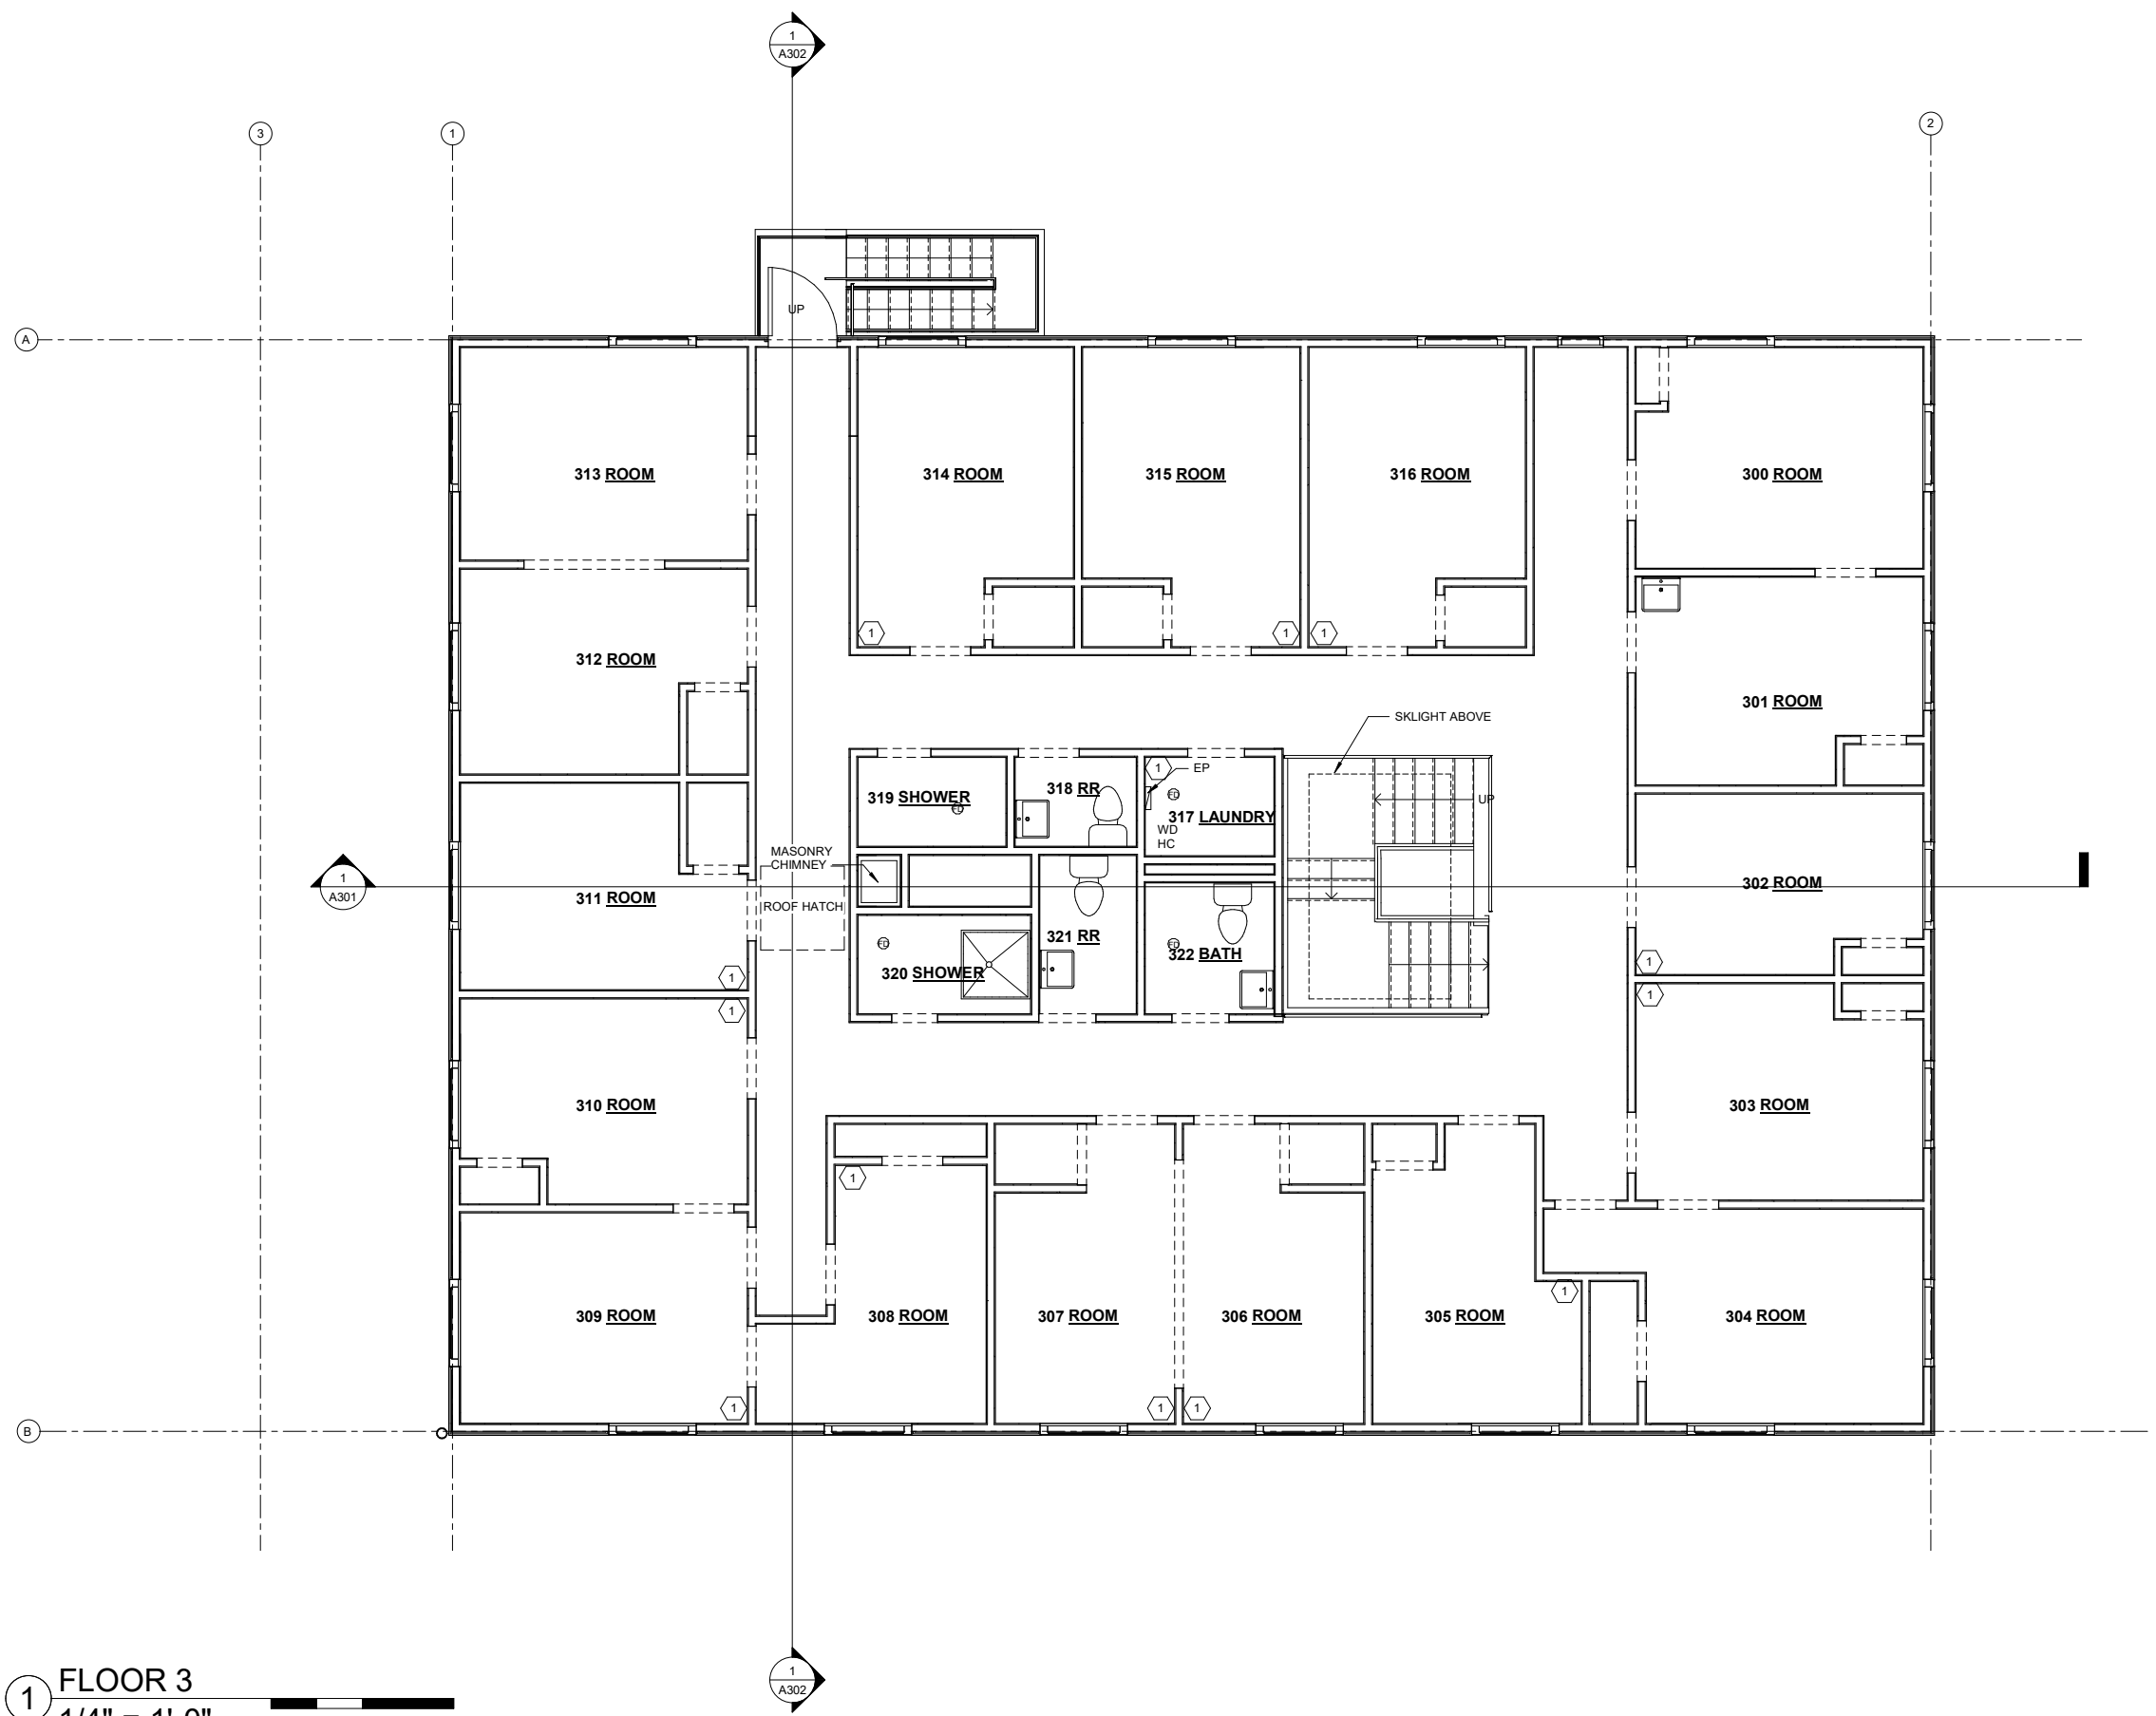

1

FLOOR 3

1/4" = 1'-0"

0'

2'

4'

8'

SHEET NOTES

1

SINK PLUMBING HOOKUPS

ACTUAL NORTH

PROJECT NORTH

NOTE: 11"x 17" PRINT IS HALF SIZE

STATE OF ALASKA

49th

REGISTERED PROFESSIONAL ARCHITECTS

6536-A

PRELIMINARY DOCUMENTS

NOT FOR CONSTRUCTION

MRV

ARCHITECTS

ARCHITECTURE · PLANNING · INTERIORS

MRV ARCHITECTS

1420 GLACIER AVE. #101

JUNEAU, AK 99801

907-586-1371

FAX 907-463-5544

mrv@mrvarchitects.com

AS-BUILT DRAWINGS 2021

BERGMANN HOTEL AS BUILT

for owner David D'Amato

MRV #2113

No.	Description	Date

SHEET TITLE:

FLOOR 3

DATE:

08.19.2021

DRAWN:

HB


CHECKED:

ZJ


SHEET NO.

A204

C:\Users\MRV\Documents\BERGMAN HOTEL as built_MRVcentral_HEATHER.rvt 8/24/2021 5:16:43 PM

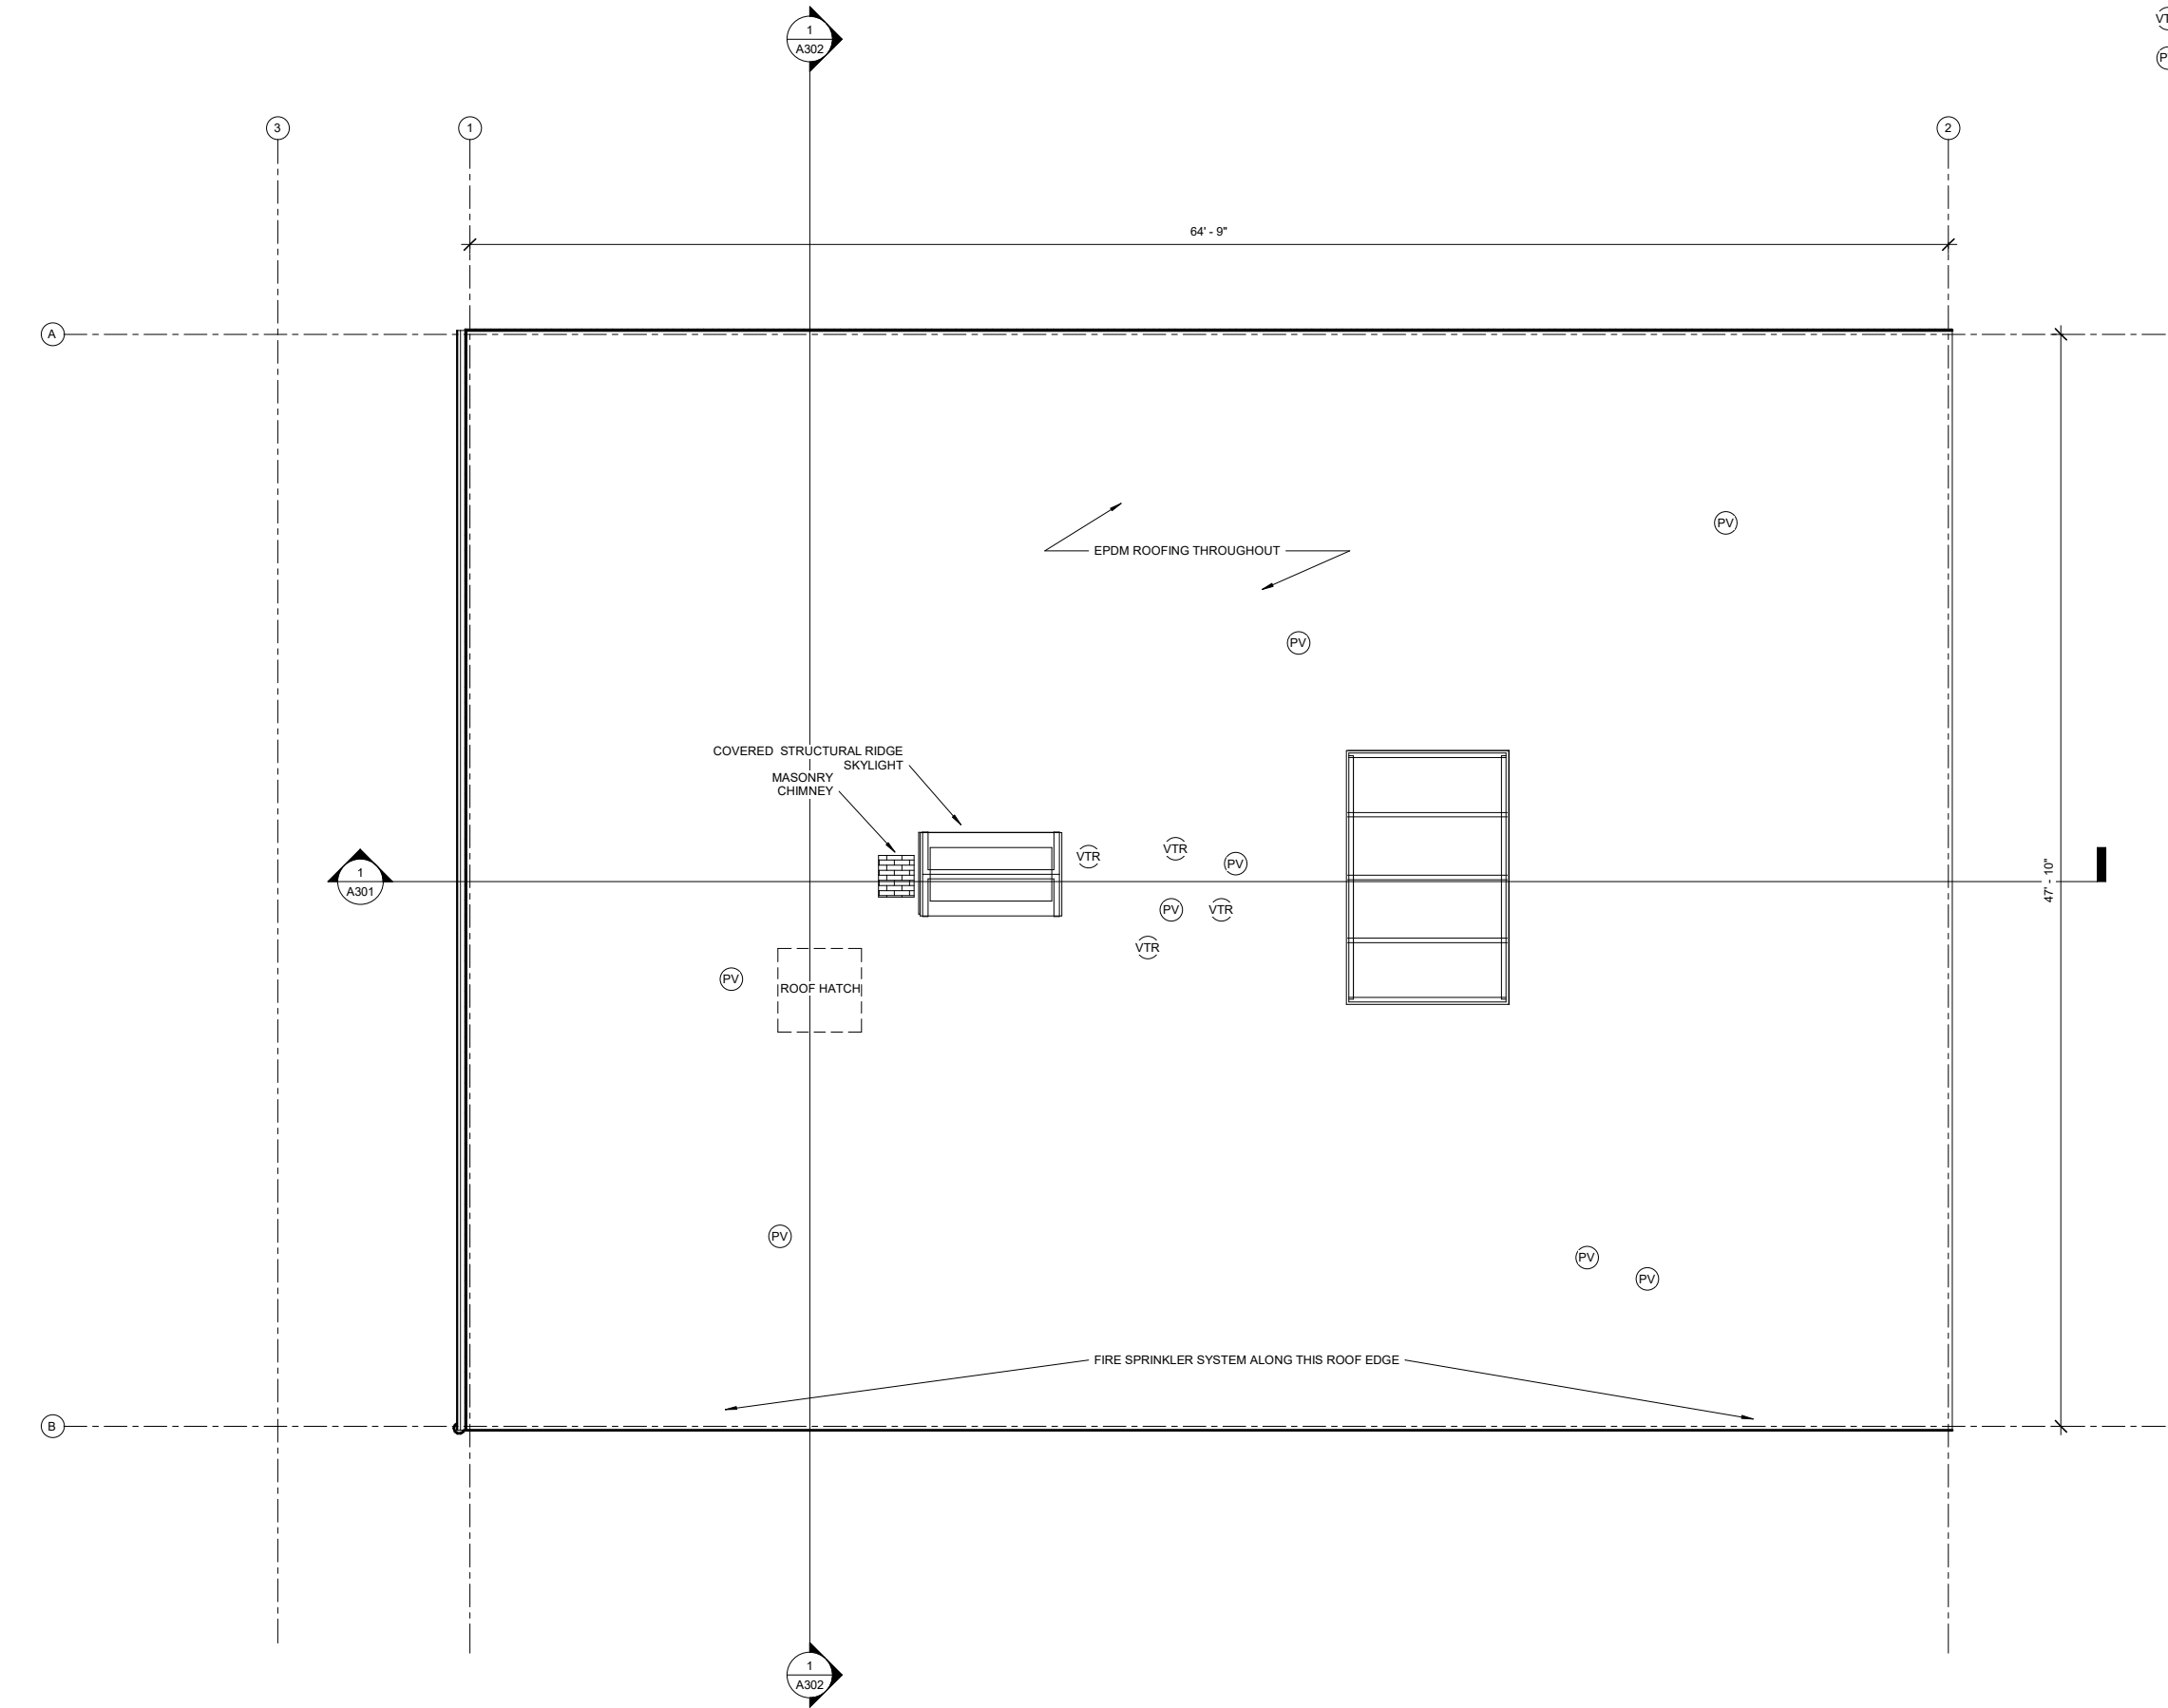

- SHEET NOTES:
- VTR VENT THROUGH ROOF
 - PV PLUMBING VENT PIPE

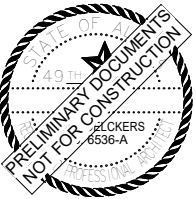

MRV ARCHITECTS
1420 GLACIER AVE. #101
JUNEAU, AK 99801
907-586-1371
FAX 907-463-5544
mrv@mrvarchitects.com

AS-BUILT DRAWINGS 2021
BERGMANN HOTEL AS BUILT

for owner David D'Amato

MRV #2113

No.	Description	Date

SHEET TITLE:
ROOF PLAN

DATE: 08.19.2021

DRAWN: HB
CHECKED: ZJ

SHEET NO.

A205


ACTUAL NORTH PROJECT NORTH

NOTE: 11"x 17" PRINT IS HALF SIZE

1 ROOF PLAN
1/4" = 1'-0"
0' 2' 4' 8'

8/24/2021 5:16:44 PM C:\Users\MRV\Documents\BERGMAN HOTEL as_built_MRVcentral_HEATHER.rvt


1 FLOOR 1 FRAMING PLAN
1/4" = 1'-0"

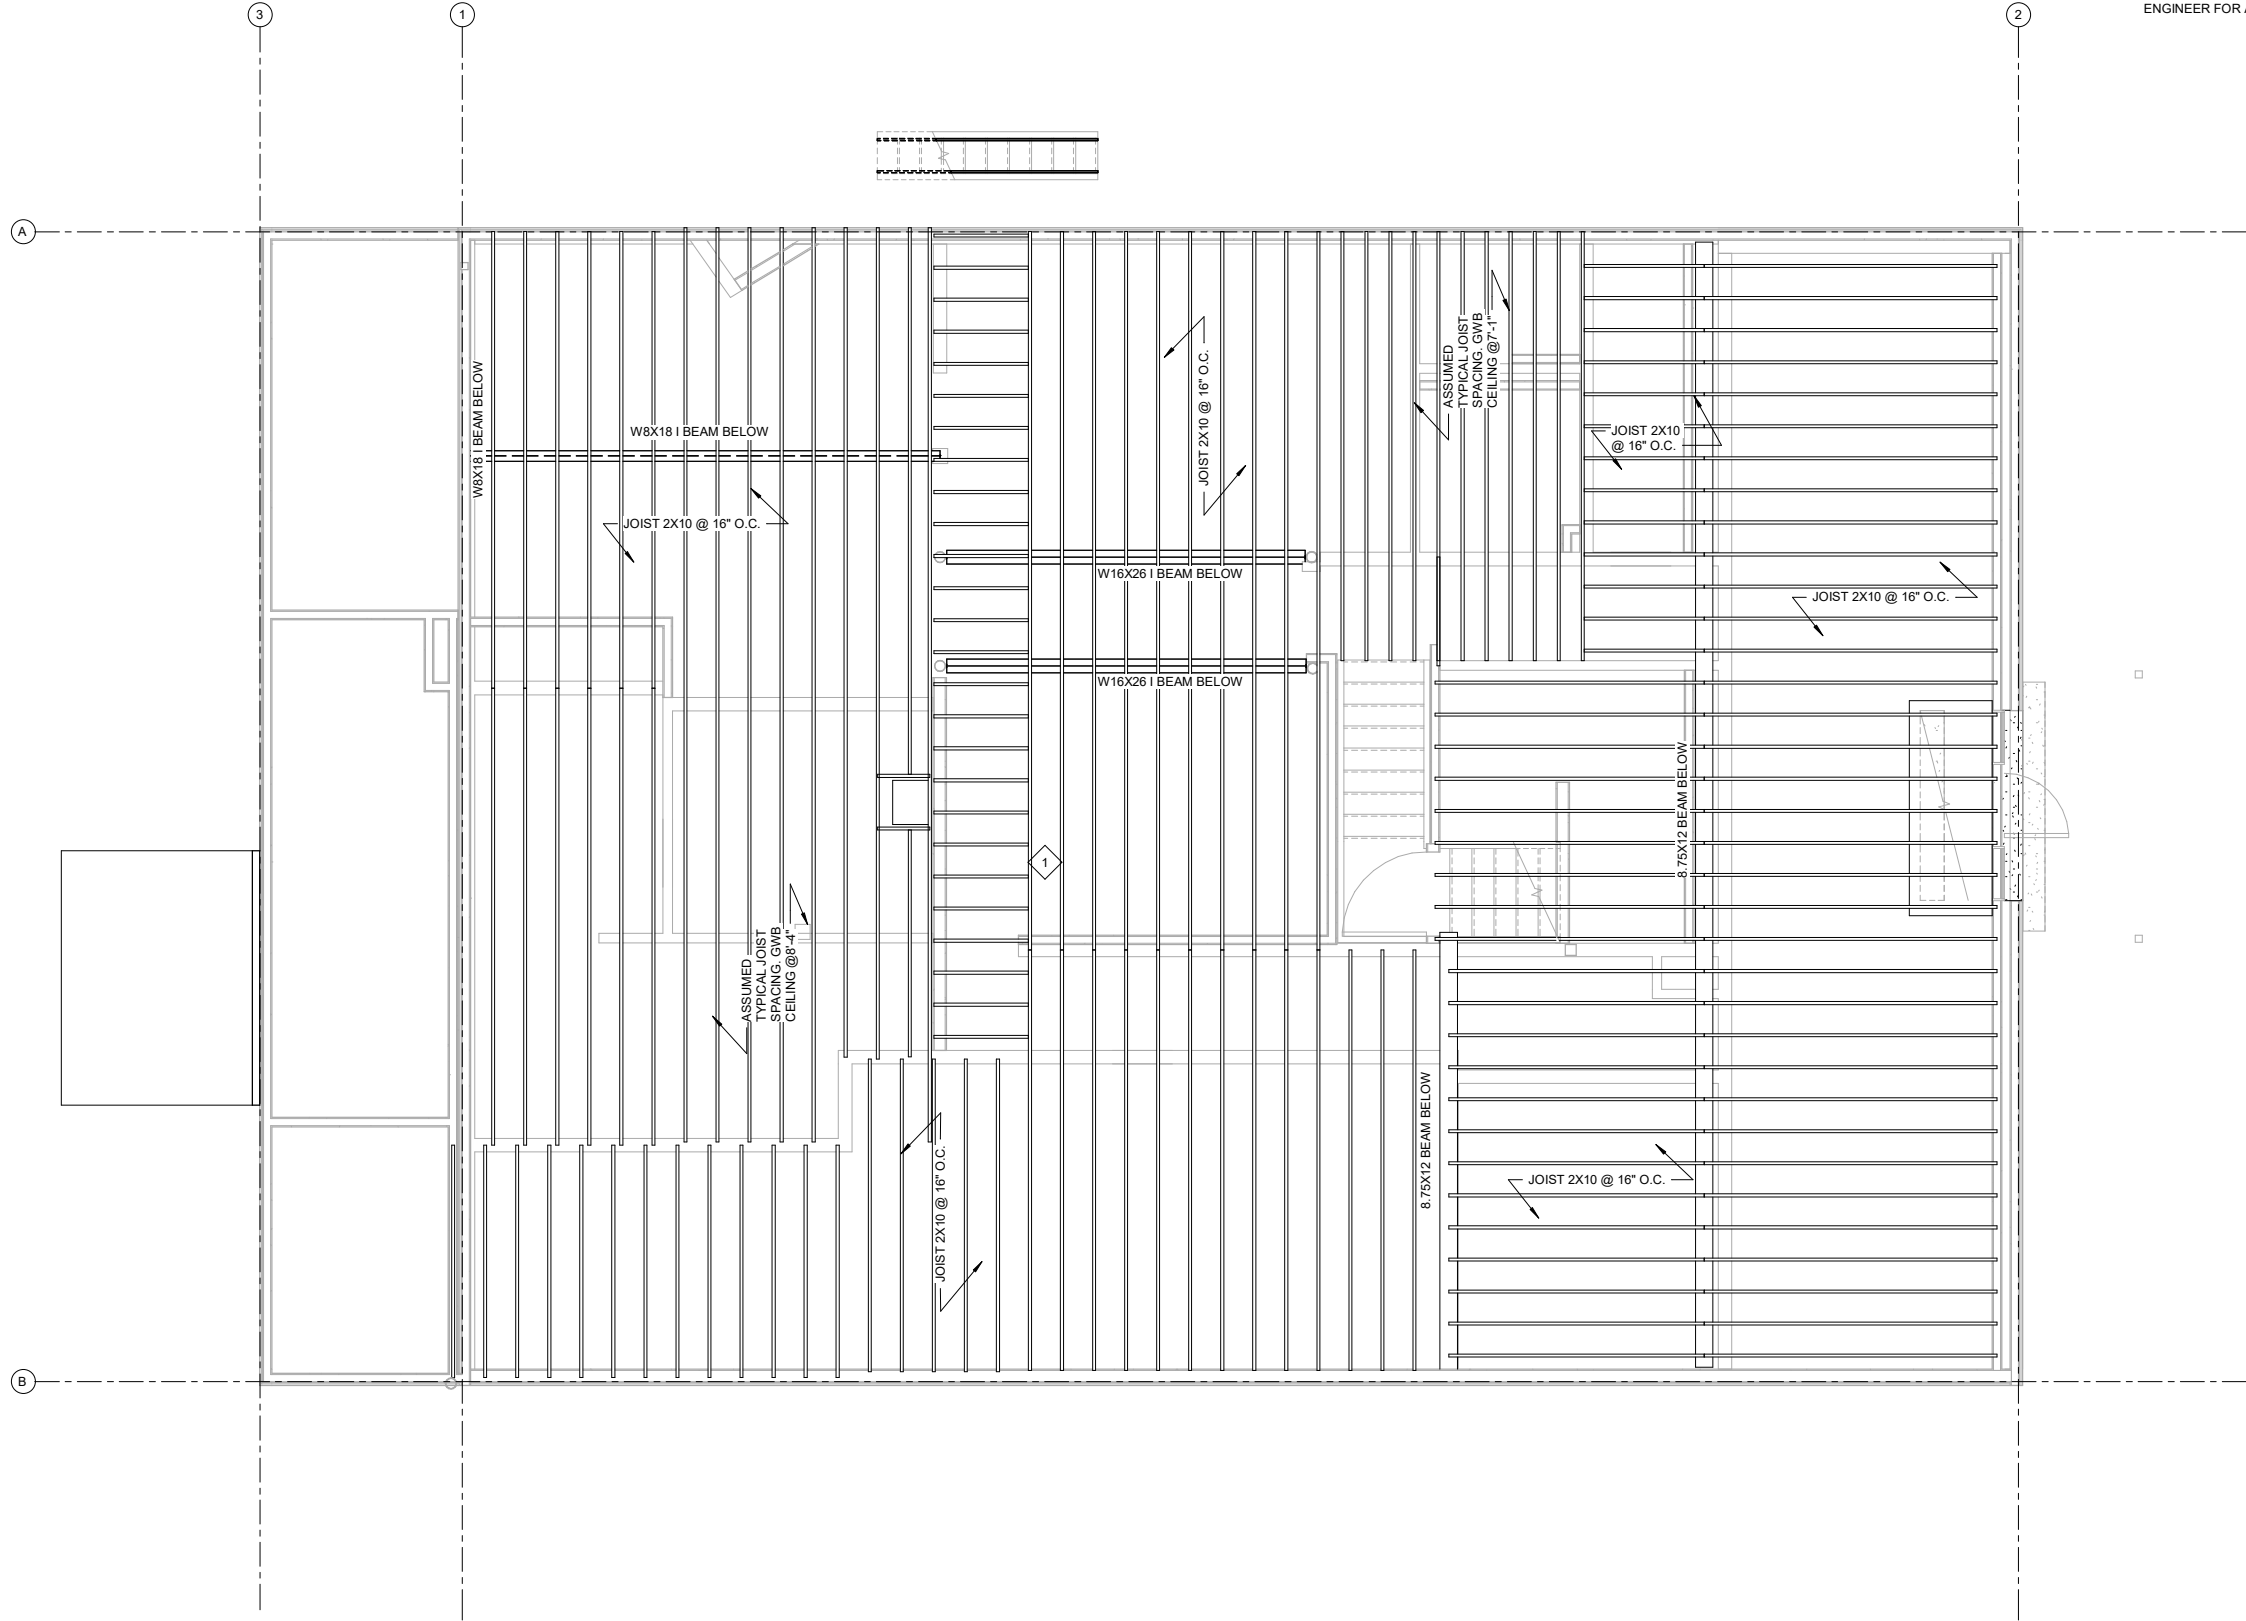

SHEET NOTES

1 JOIST SPANSE TAKING THREE TIMES THE LOAD OF A TYP JOIST

FRAMING PLANS ARE BASED ON ARCHITECT AS-BUILT OBSERVATIONS. CONSULT A STRUCTURAL ENGINEER FOR ANALYSIS.

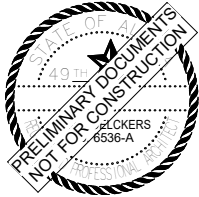

MRV ARCHITECTS
1420 GLACIER AVE. #101
JUNEAU, AK 99801
907-586-1371
FAX 907-463-5544
mrv@mrvarchitects.com

AS-BUILT DRAWINGS 2021
BERGMANN HOTEL AS BUILT

for owner David D'Amato

MRV #2113

No.	Description	Date

SHEET TITLE:
FLOOR 1
FRAMING

DATE: 08.19.2021


DRAWN: HB

CHECKED: ZJ


SHEET NO.

A250


NOTE: 11"x 17" PRINT IS HALF SIZE

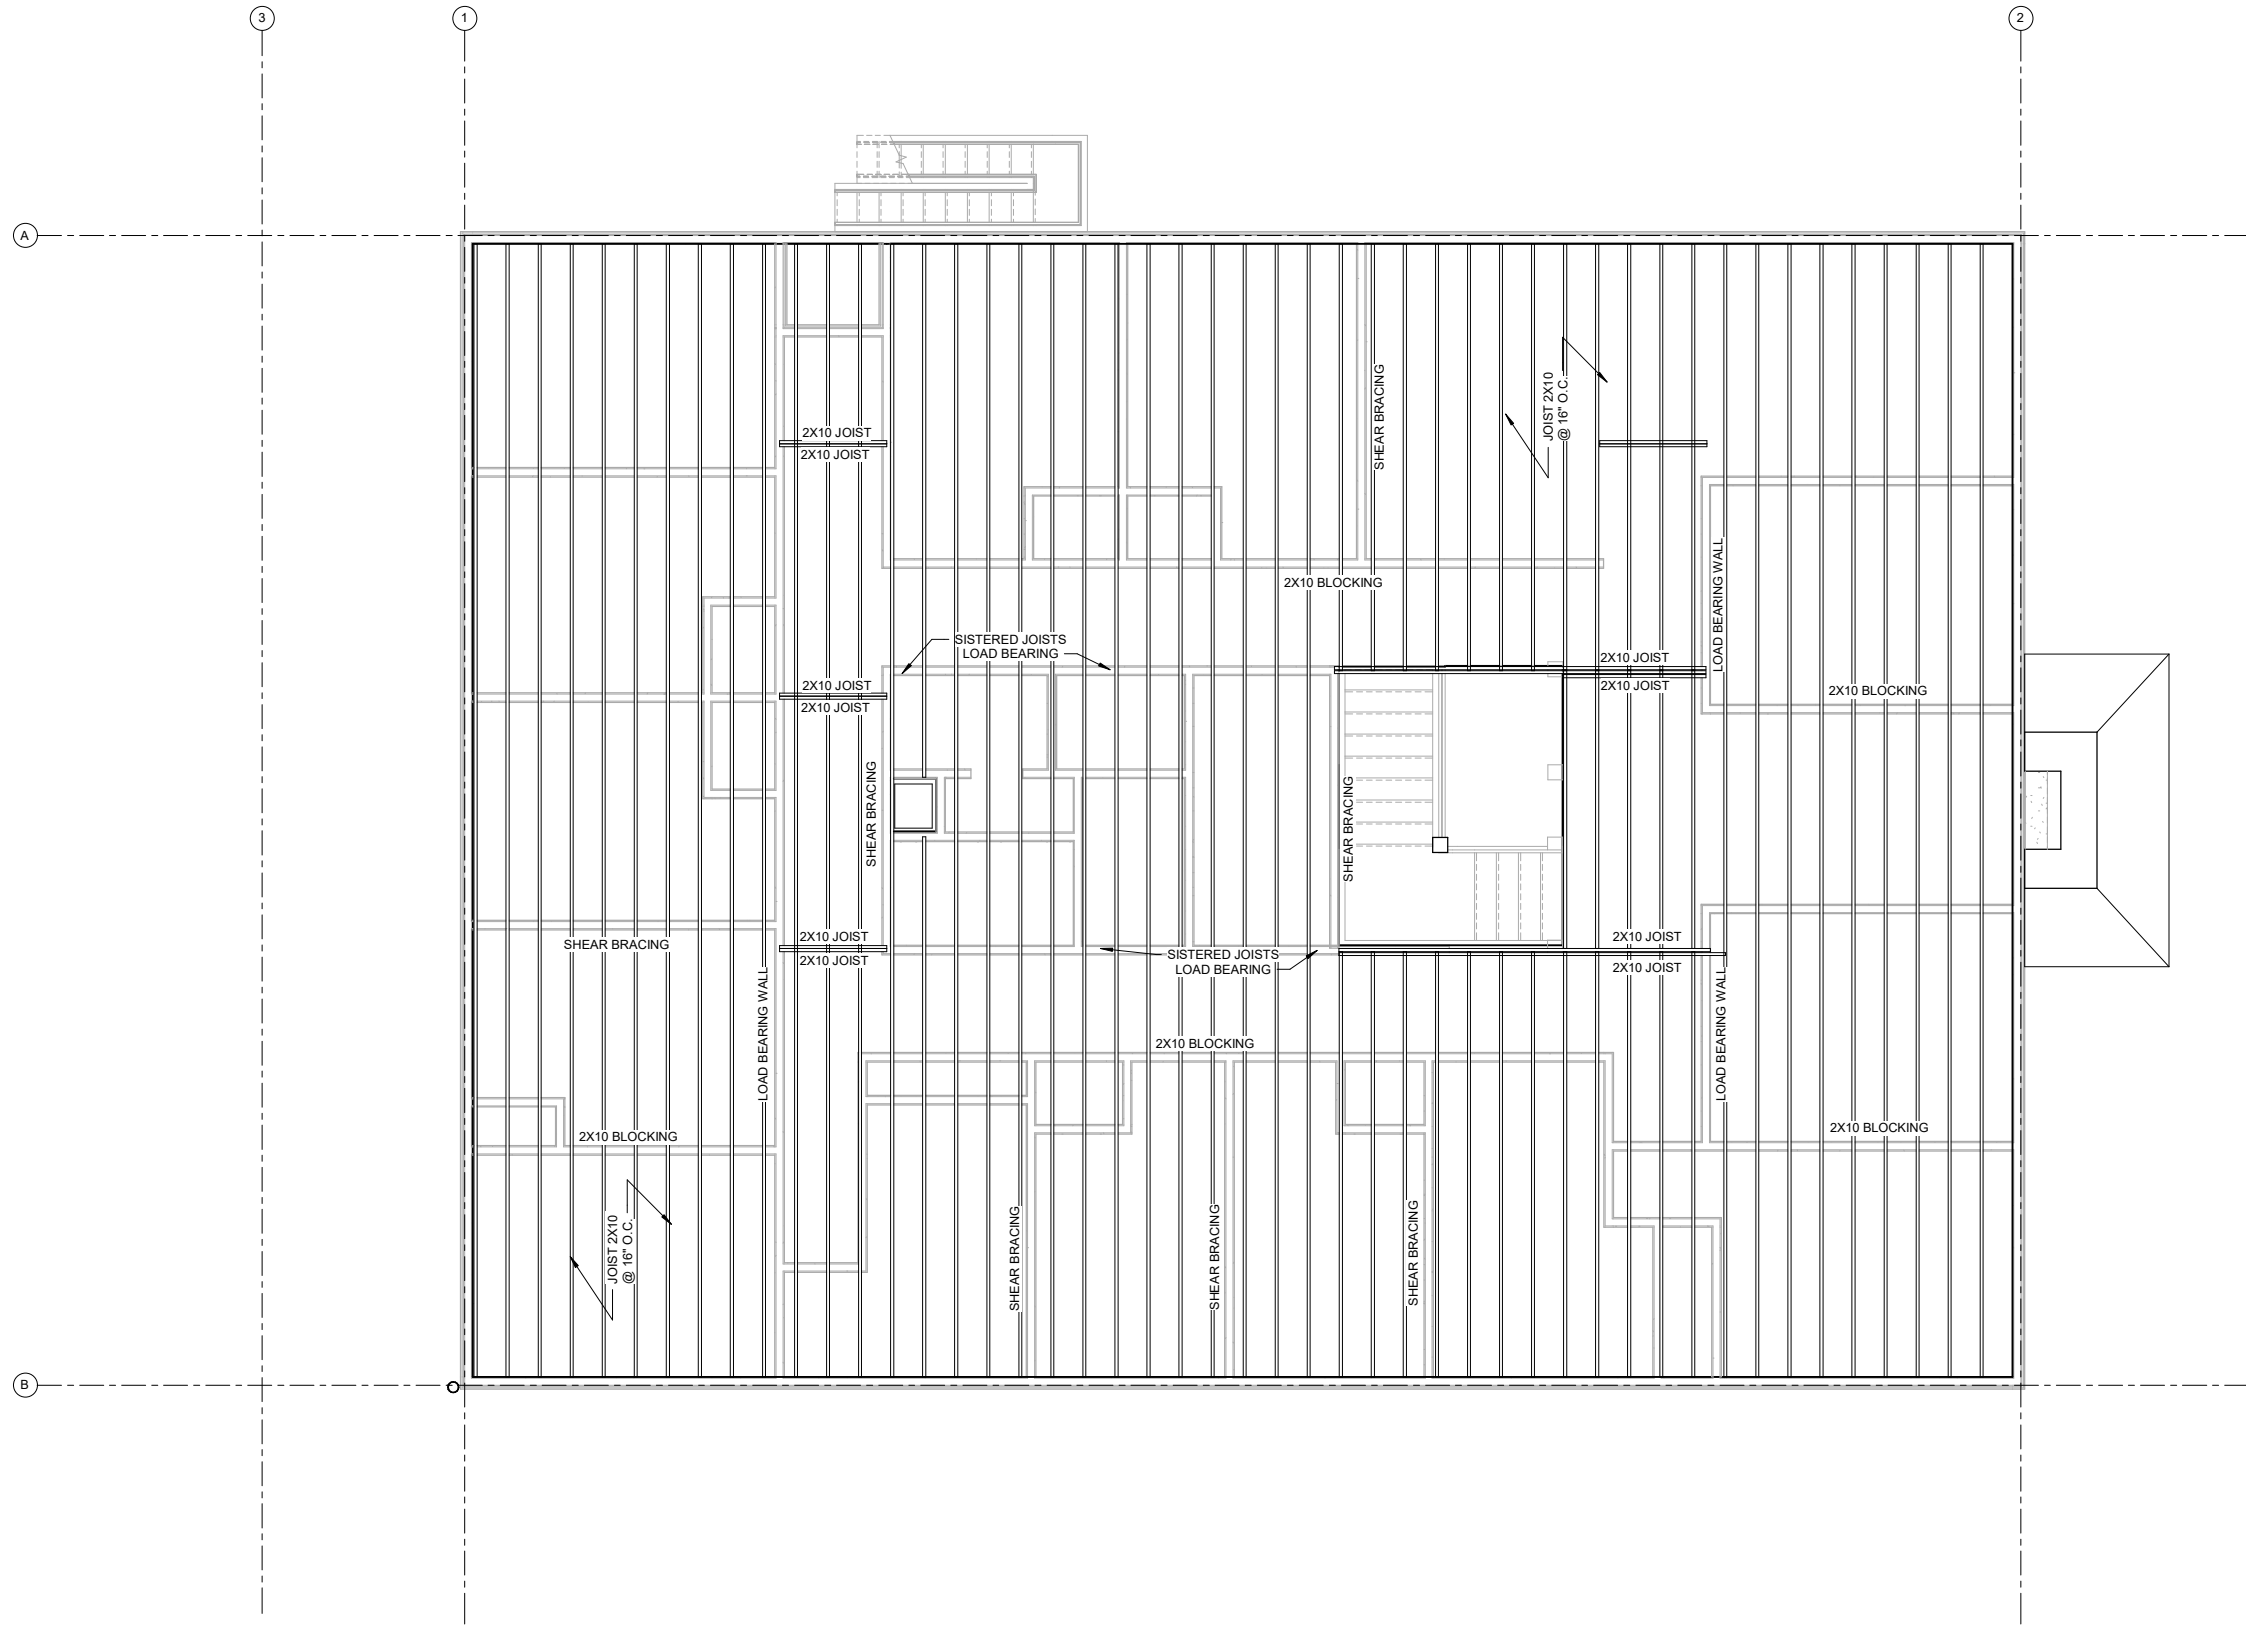

1 FLOOR 2 FRAMING PLAN
1/4" = 1'-0"

 

NOTE: 11"x 17" PRINT IS HALF SIZE

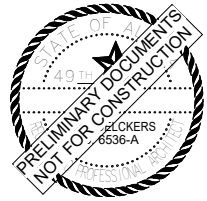

MRV ARCHITECTS
1420 GLACIER AVE. #101
JUNEAU, AK 99801
907-586-1371
FAX 907-463-5544
mrv@mrvarchitects.com

AS-BUILT DRAWINGS 2021
BERGMANN HOTEL AS BUILT


for owner David D'Amato

MRV #2113

No.	Description	Date

SHEET TITLE:	
FLOOR 2 STRUCTURAL FRAMING	
DATE:	08.19.2021
DRAWN:	HB
CHECKED:	ZJ


SHEET NO.
A251

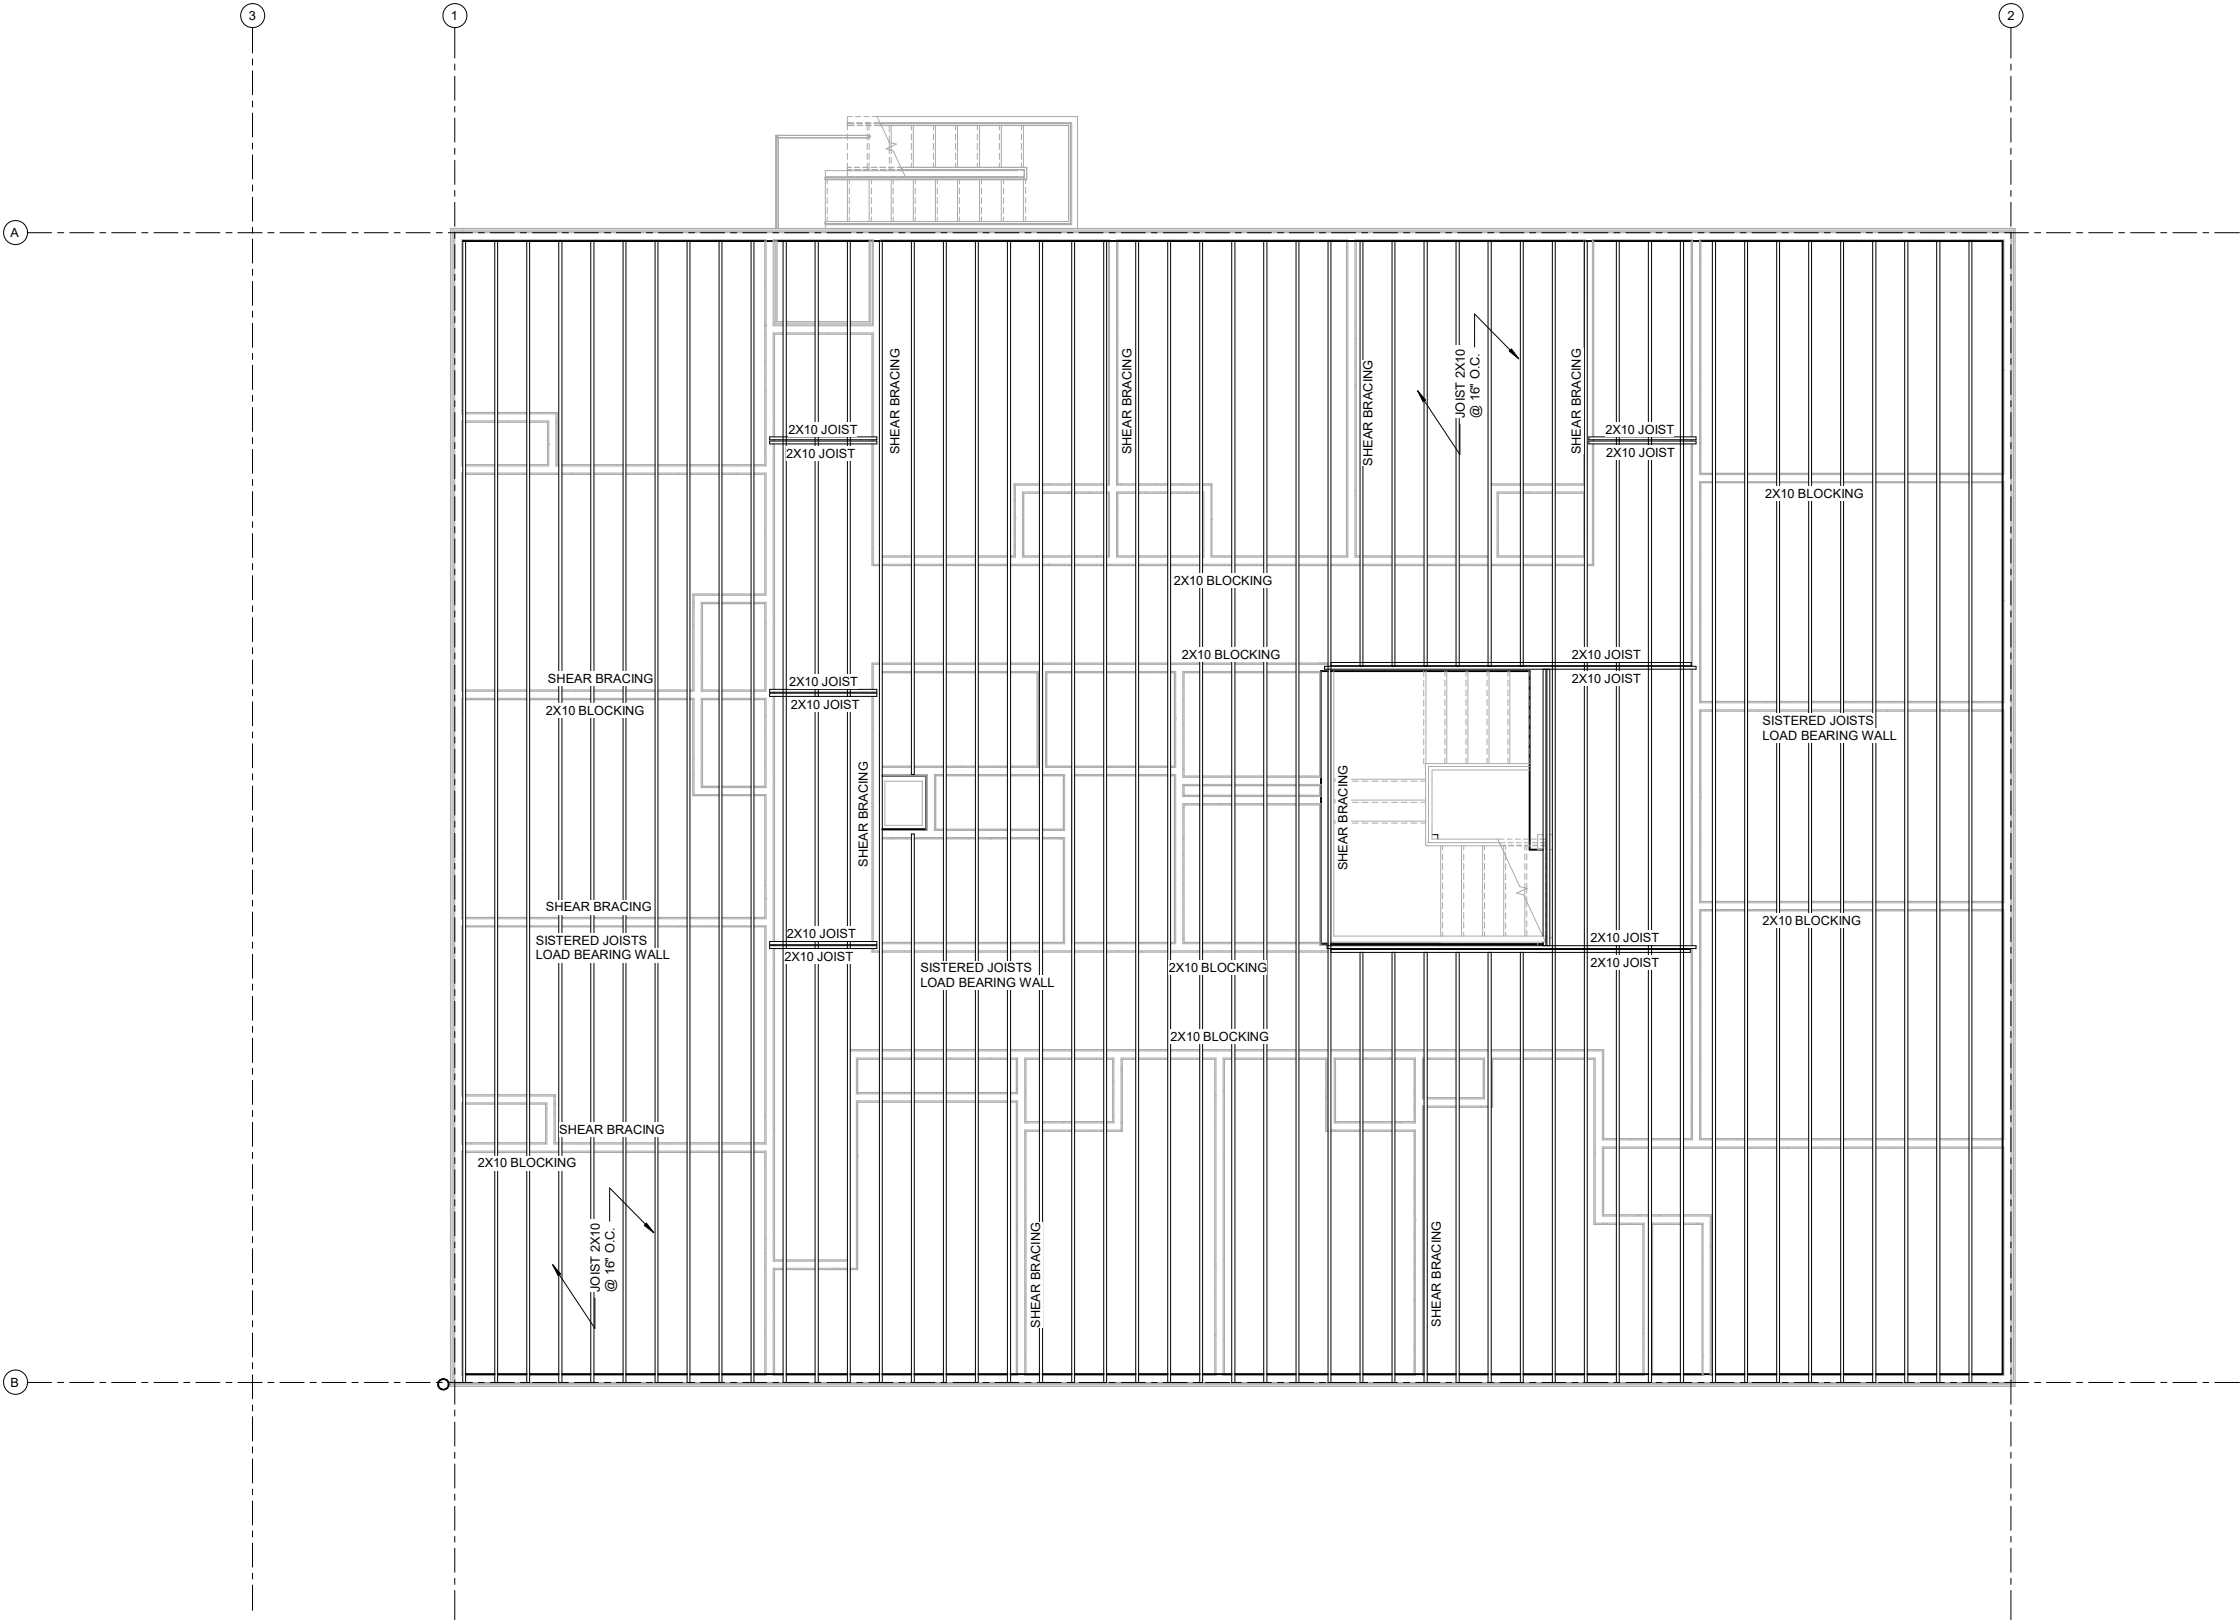

1 FLOOR 3 FRAMING PLAN
1/4" = 1'-0"

0' 2' 4' 8'

NOTE: 11"x 17" PRINT IS HALF SIZE

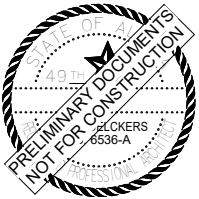

MRV ARCHITECTS
1420 GLACIER AVE. #101
JUNEAU, AK 99801
907-586-1371
FAX 907-463-5544
mrv@mrvarchitects.com

AS-BUILT DRAWINGS 2021
BERGMANN HOTEL AS BUILT

for owner David D'Amato


MRV #2113

No.	Description	Date

SHEET TITLE:
FLOOR 3
STRUCTURAL
FRAMING
DATE: 08.19.2021
DRAWN: HB
CHECKED: ZJ


SHEET NO.
A252

8/24/2021 5:16:49 PM C:\Users\MRV\Documents\BERGMAN HOTEL as_built_MRVcentral_HEATHER.rvt

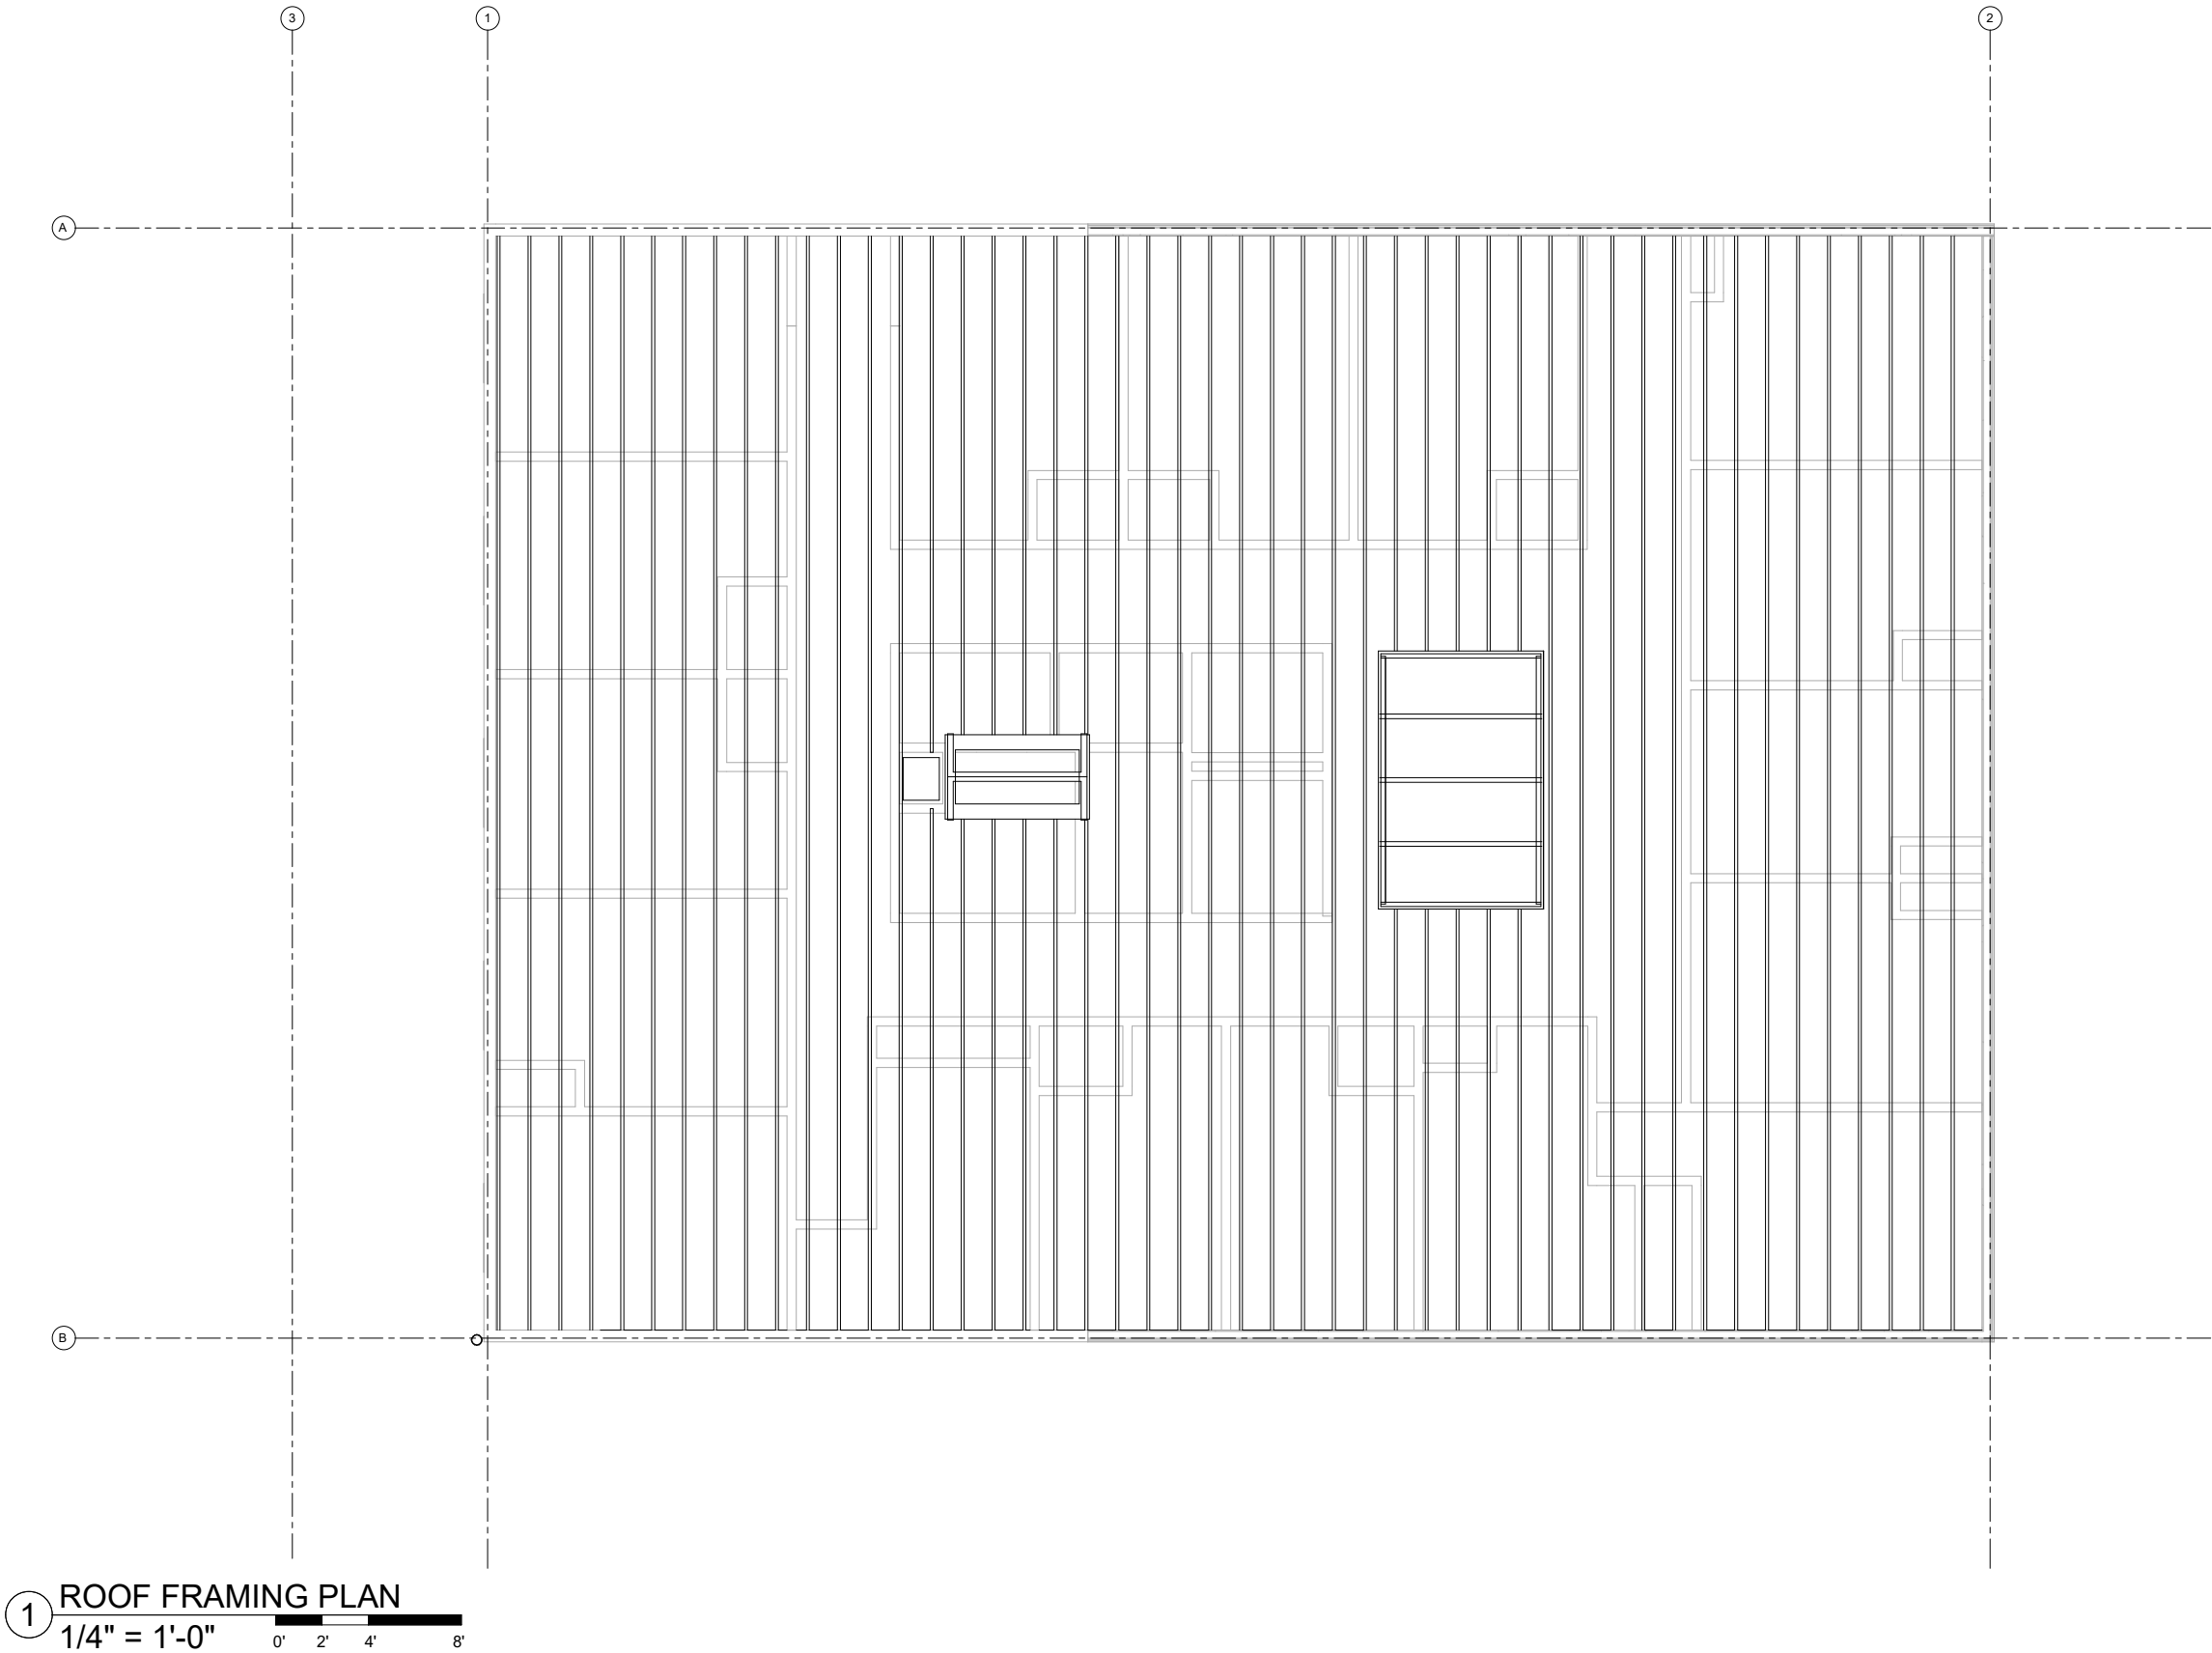

1 ROOF FRAMING PLAN
1/4" = 1'-0"

NOTE: 11"x 17" PRINT IS HALF SIZE

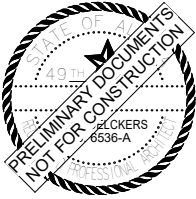

MRV ARCHITECTS
1420 GLACIER AVE. #101
JUNEAU, AK 99801
907-586-1371
FAX 907-463-5544
mrv@mrvarchitects.com

AS-BUILT DRAWINGS 2021
BERGMANN HOTEL AS BUILT

for owner David D'Amato

MRV #2113


No.	Description	Date

SHEET TITLE:
ROOF
STRUCTURAL
FRAMING
DATE: 08.19.2021

DRAWN: HB
CHECKED: ZJ

SHEET NO.
A253

8/24/2021 5:16:50 PM C:\Users\MRV\Documents\BERGMAN HOTEL as_built_MRVcentral_HEATHER.rvt

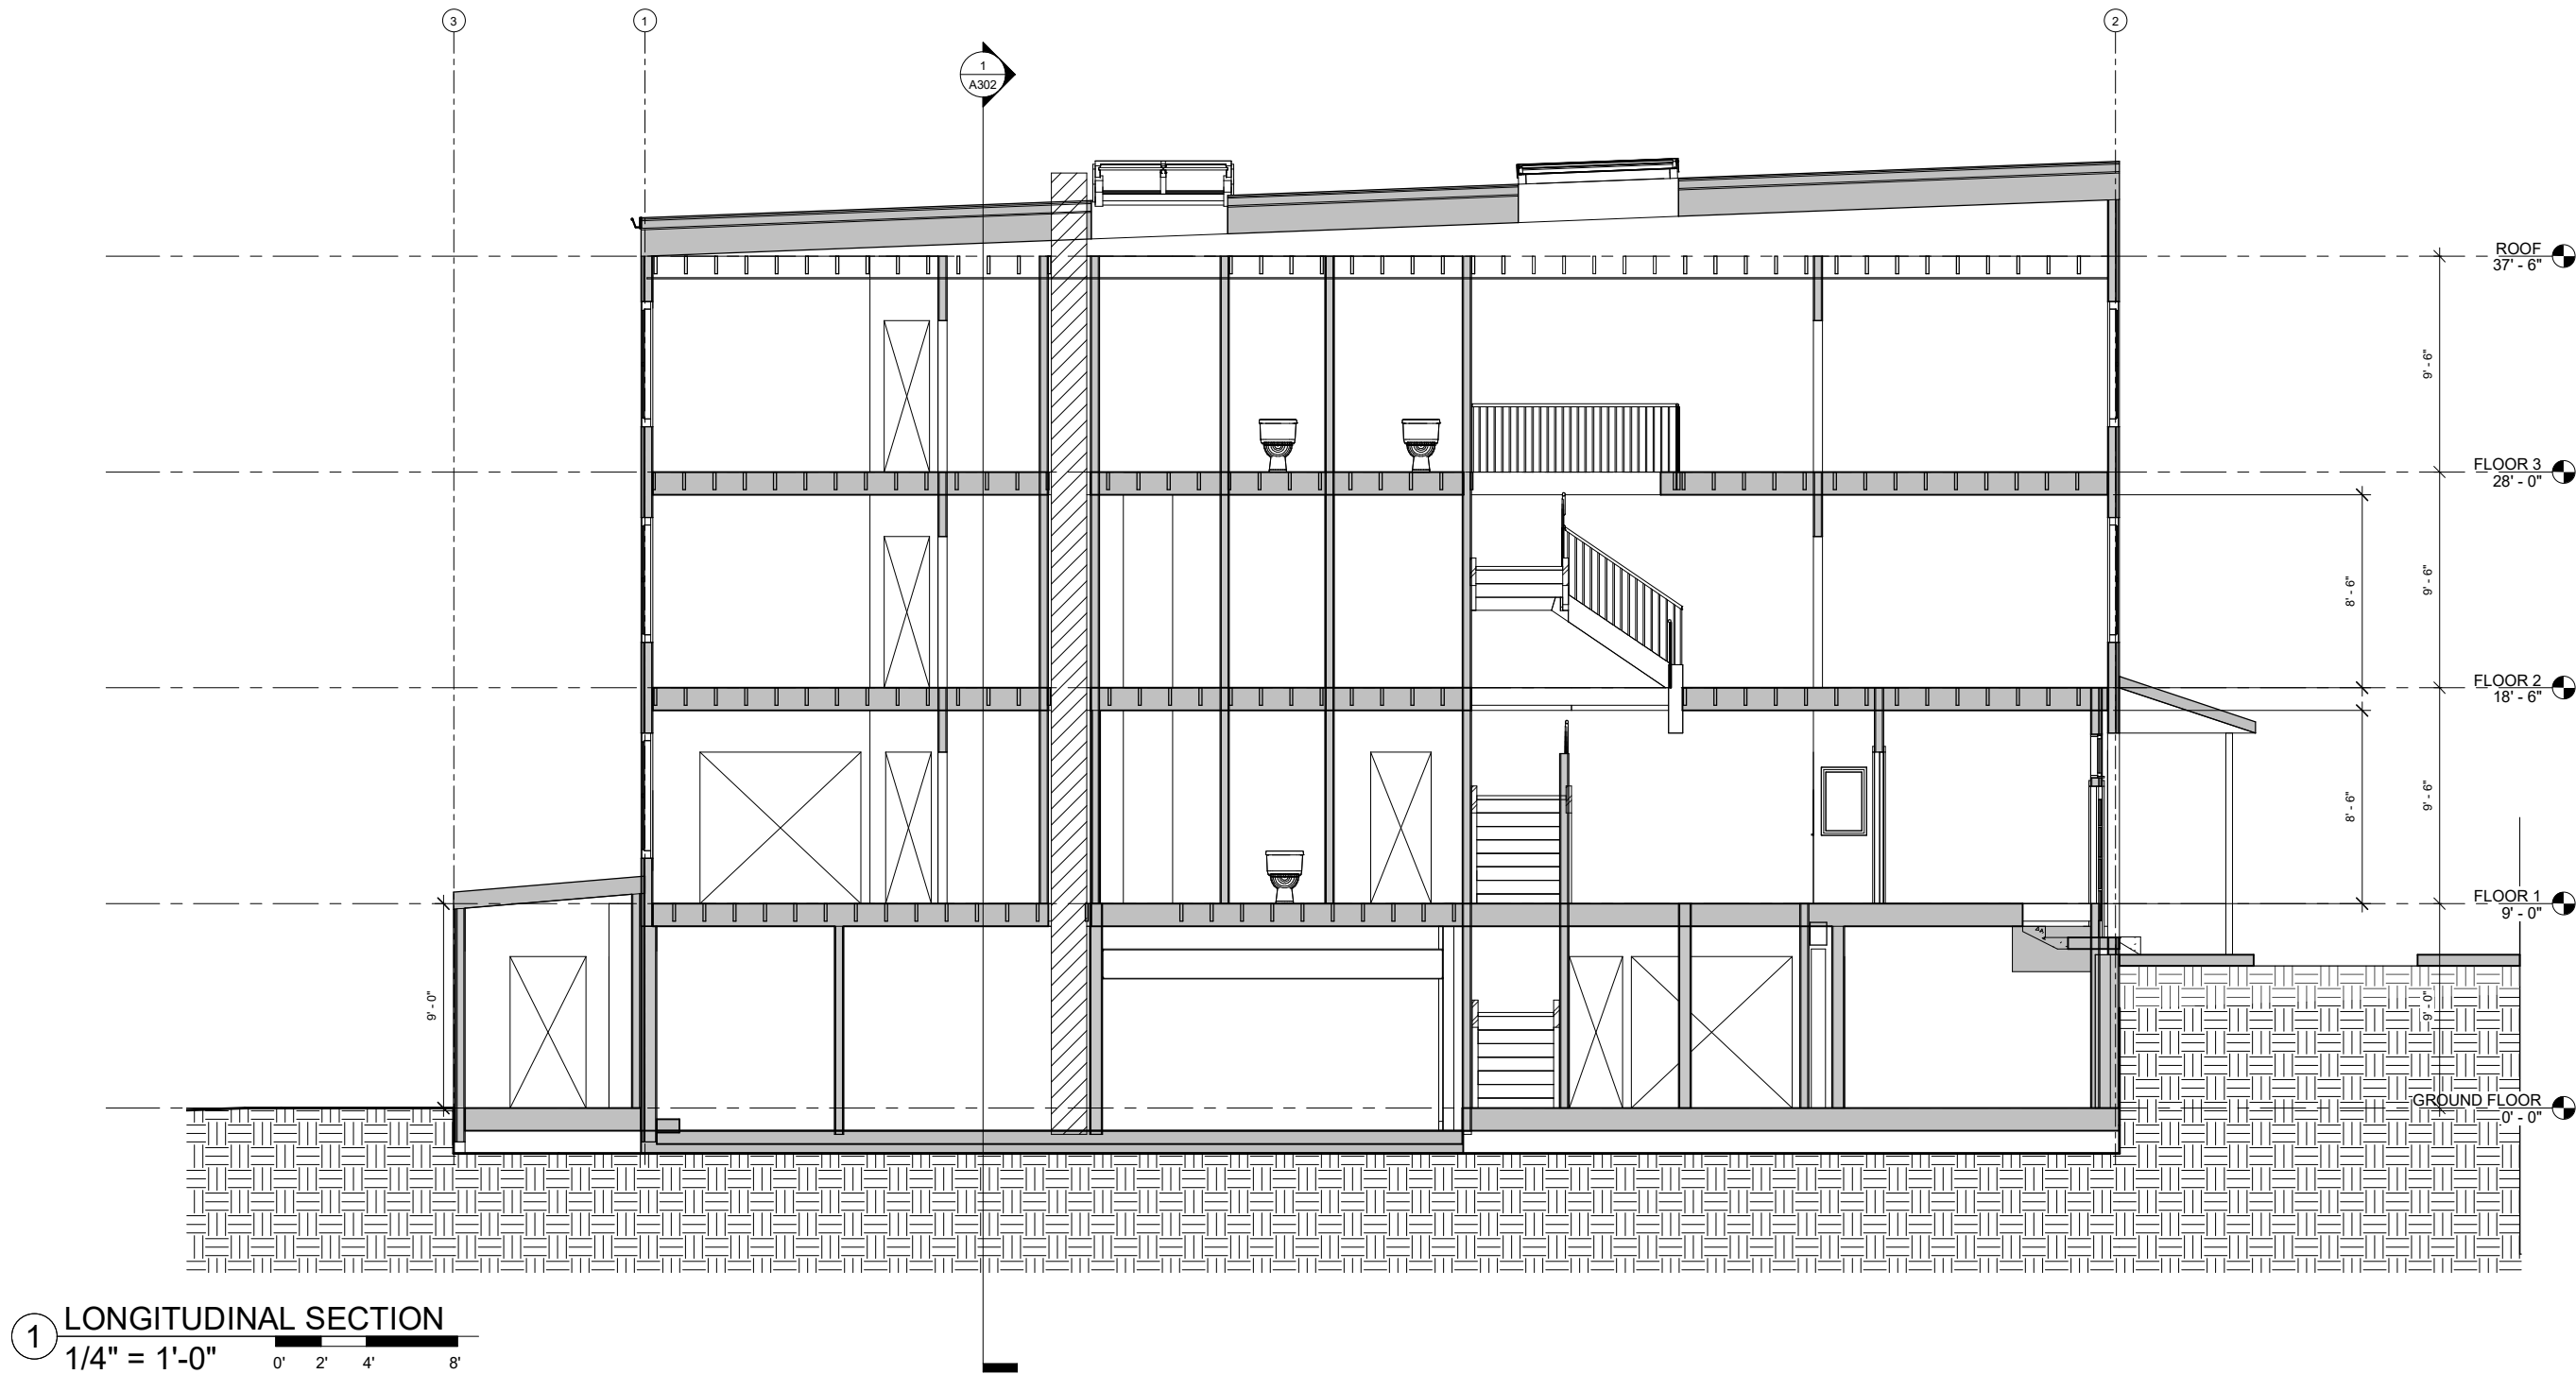

1 LONGITUDINAL SECTION
1/4" = 1'-0"

NOTE: 11"x 17" PRINT IS HALF SIZE



MRV ARCHITECTS
1420 GLACIER AVE. #101
JUNEAU, AK 99801
907-586-1371
FAX 907-463-5544
mrv@mrvarchitects.com

AS-BUILT DRAWINGS 2021
BERGMANN HOTEL AS BUILT

for owner David D'Amato

MRV #2113

No.	Description	Date


SHEET TITLE:
BUILDING
SECTION

DATE: 08.19.2021

DRAWN: HB
CHECKED: ZJ


SHEET NO.
A301

8/24/2021 5:16:52 PM C:\Users\MRV\Documents\BERGMAN HOTEL as_built_MRVcentral_HEATHER.nc

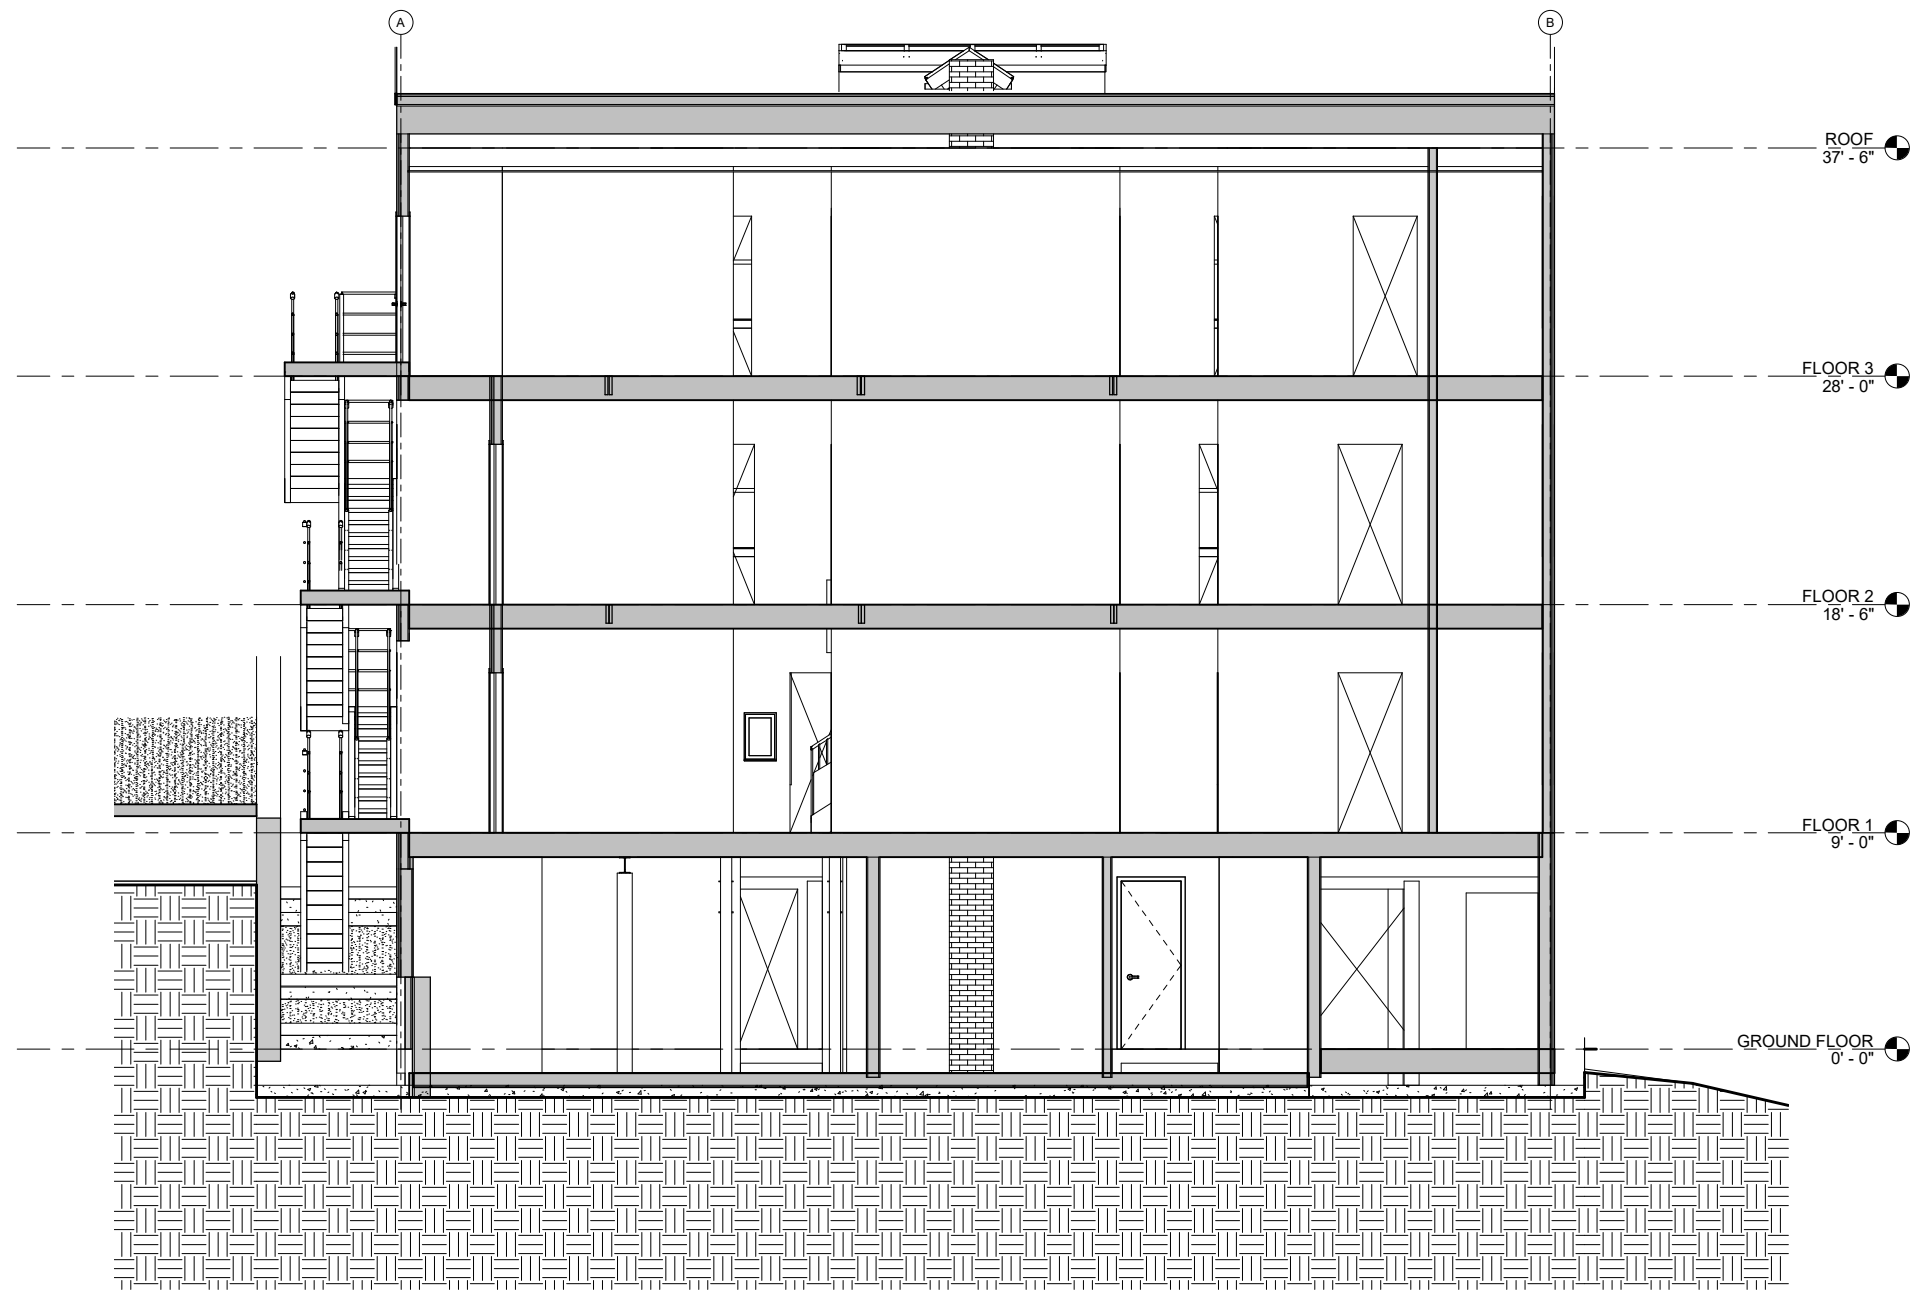

1 TRANSVERSE SECTION
1/4" = 1'-0"

NOTE: 11"x 17" PRINT IS HALF SIZE

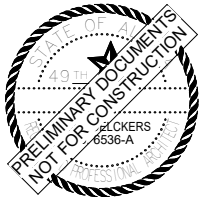

MRV ARCHITECTS
1420 GLACIER AVE. #101
JUNEAU, AK 99801
907-586-1371
FAX 907-463-5544
mrv@mrvarchitects.com

AS-BUILT DRAWINGS 2021

BERGMANN HOTEL AS BUILT

for owner David D'Amato

MRV #2113

No.	Description	Date

SHEET TITLE:
BUILDING
SECTION


DATE: 08.19.2021

DRAWN: HB

CHECKED: ZJ

SHEET NO.

A302

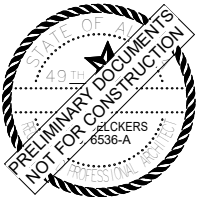

MRV
ARCHITECTS
ARCHITECTURE · PLANNING · INTERIORS

MRV ARCHITECTS
1420 GLACIER AVE. #101
JUNEAU, AK 99801
907-586-1371
FAX 907-463-5544
mrv@mrvarchitects.com

AS-BUILT DRAWINGS 2021

BERGMANN HOTEL AS BUILT

for owner David D'Amato

No.	Description	Date

SHEET TITLE:
BUILDING
ELEVATIONS

DATE: 08.19.2021


DRAWN: HB
CHECKED: ZJ

SHEET NO.


A401



3 ELEVATION EAST
1/8" = 1'-0"

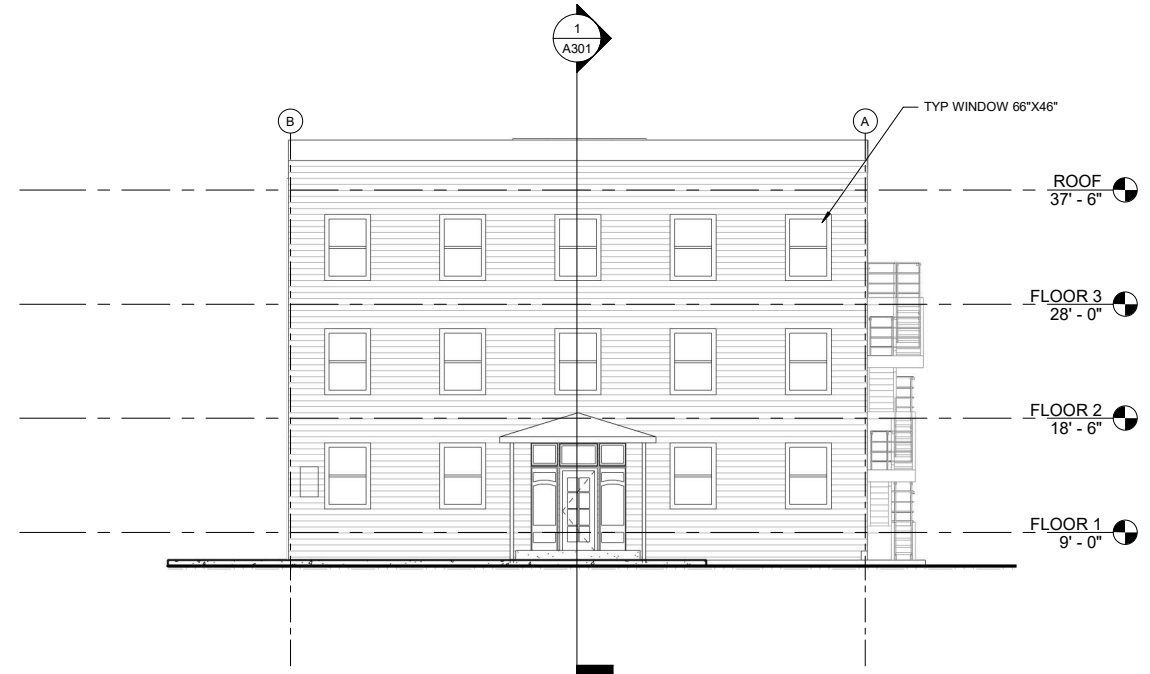

1 ELEVATION NORTH
1/8" = 1'-0"

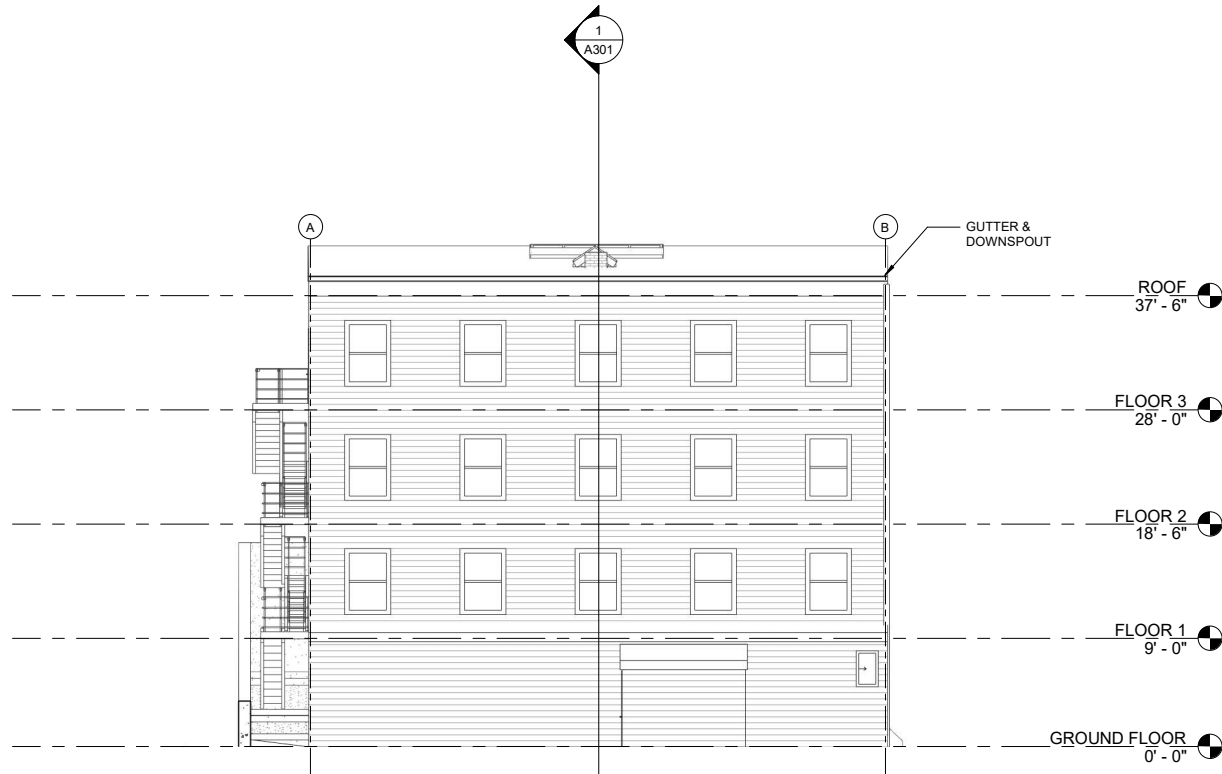

4 ELEVATION SOUTH
1/8" = 1'-0"



2 ELEVATION WEST
1/8" = 1'-0"

NOTE: 11"x 17" PRINT IS HALF SIZE