




PUMP SYMBOLS

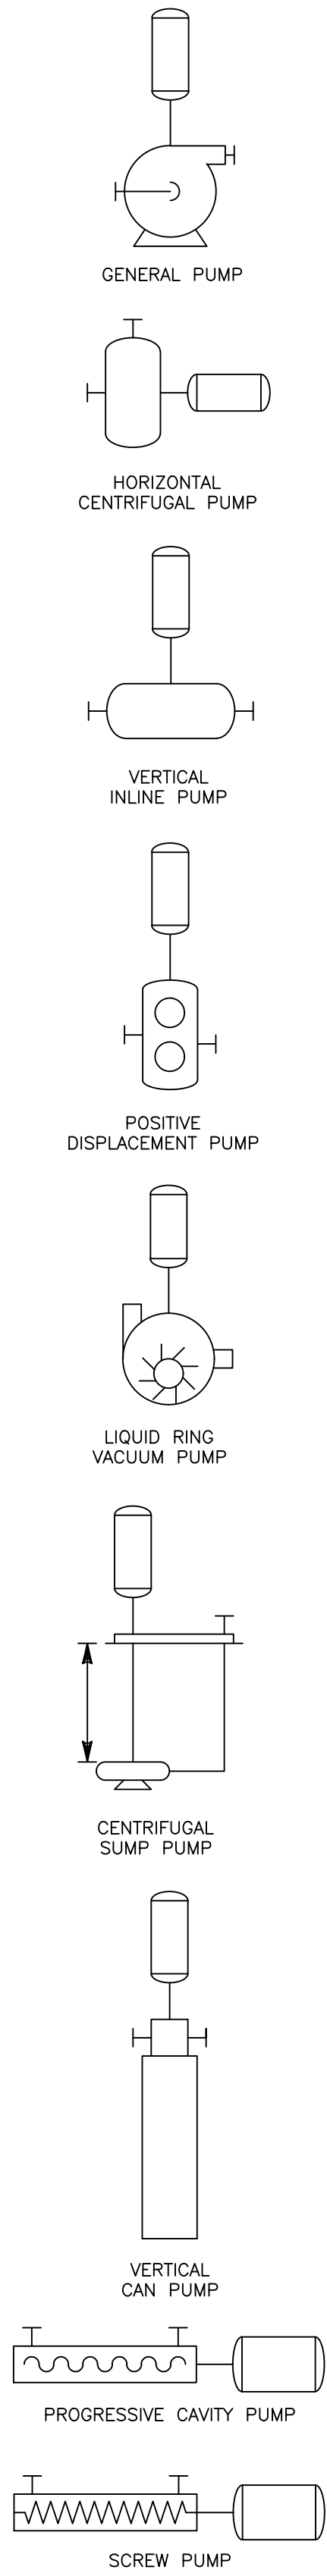


BLOWER SYMBOLS

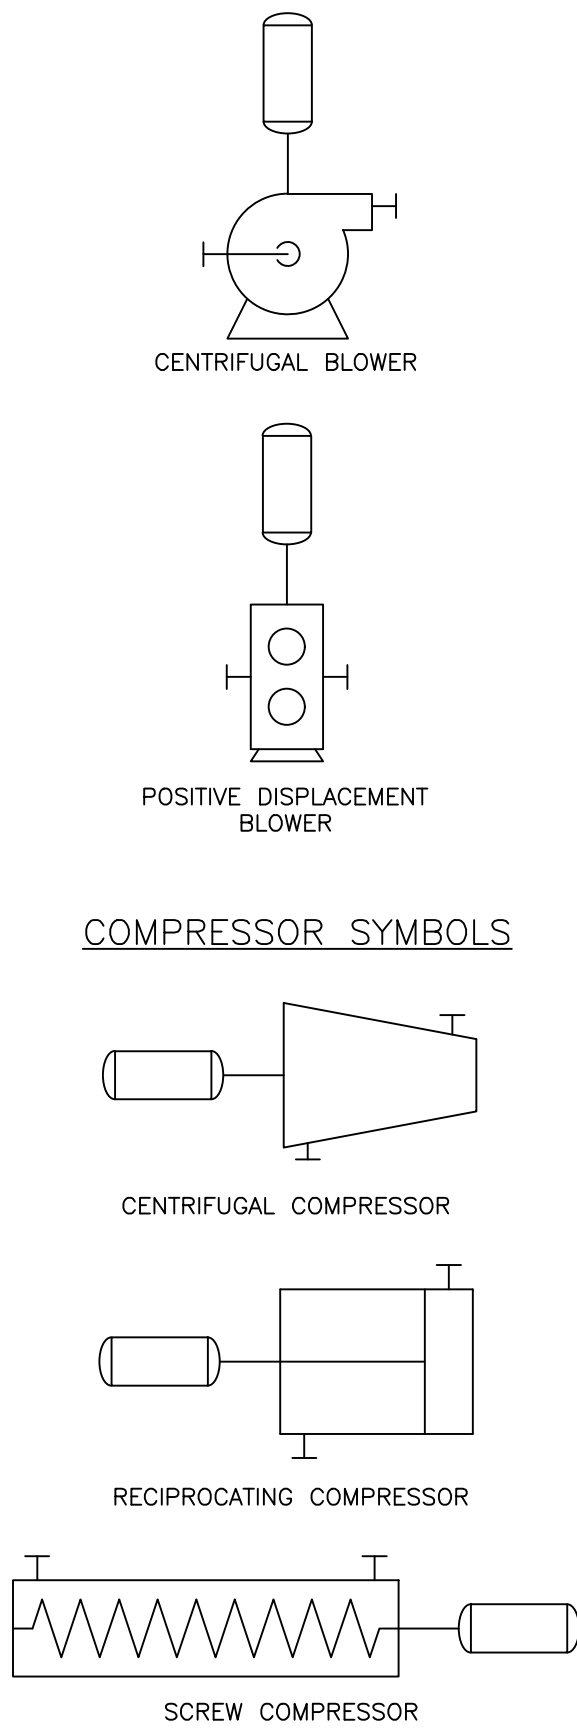


COMPRESSOR SYMBOLS

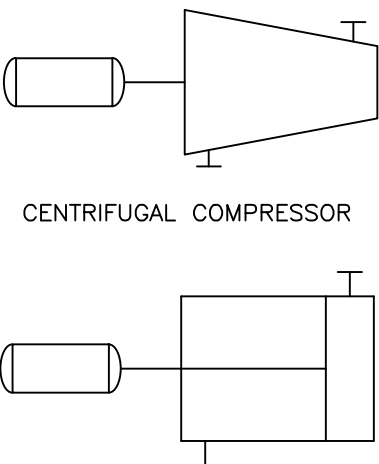


DRIVER SYMBOLS

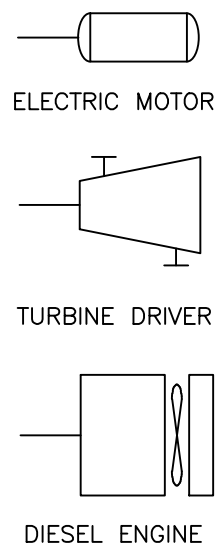


MISCELLANEOUS SYMBOLS

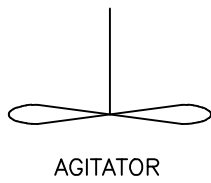


HEAT EXCHANGER SYMBOLS

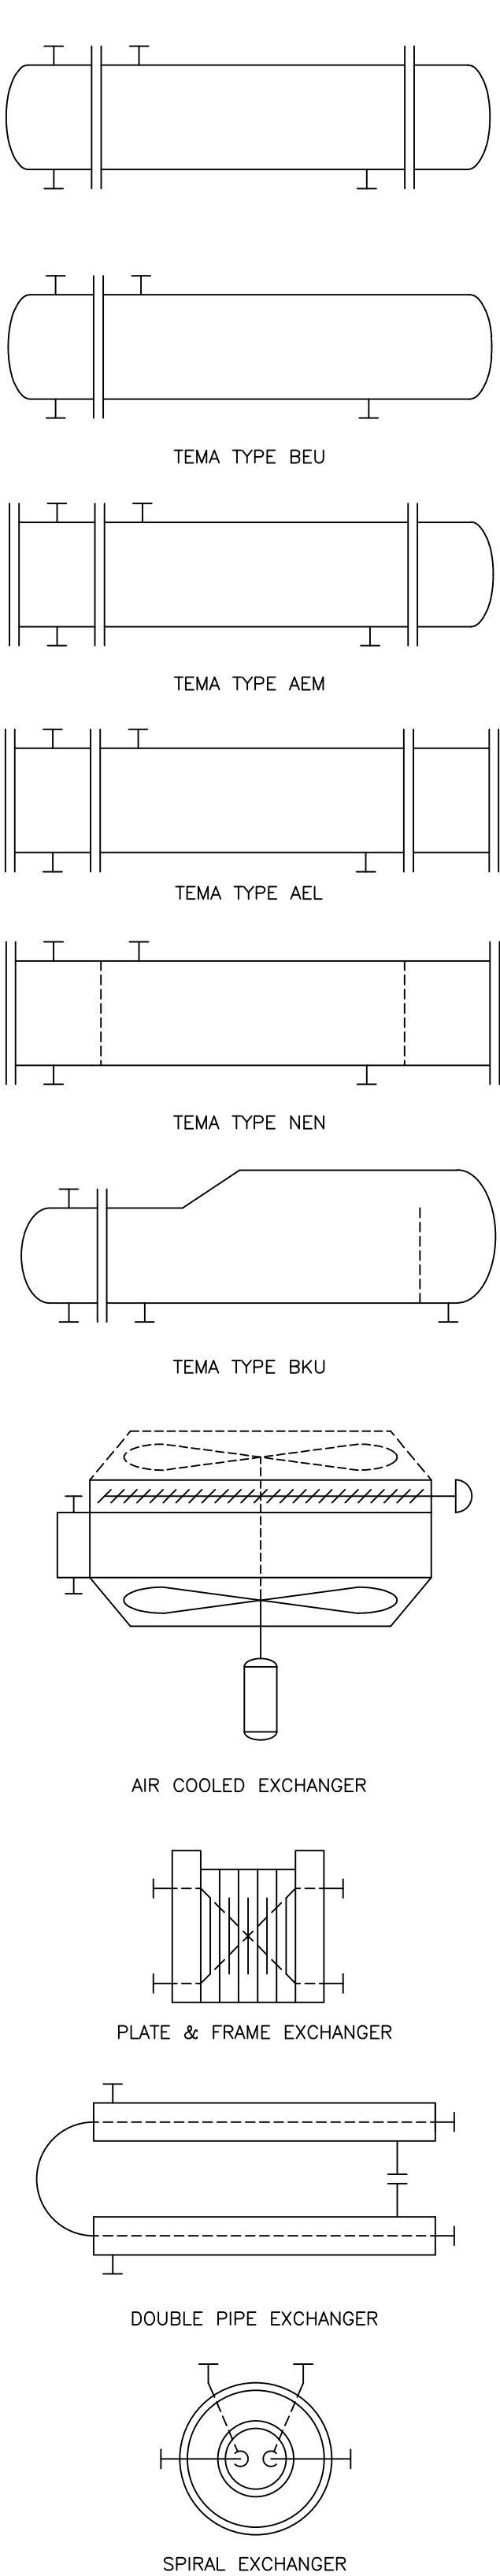

TANK SYMBOLS

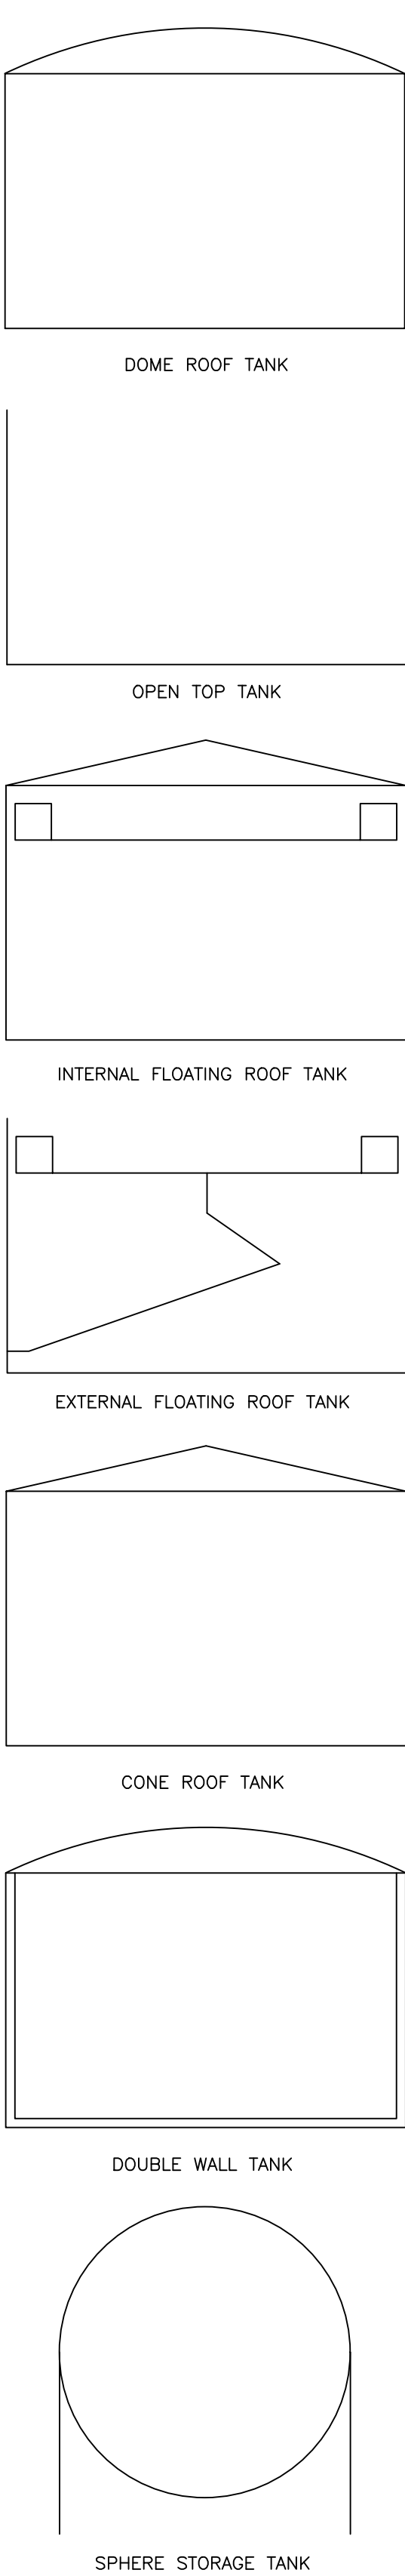

TANK SYMBOLS

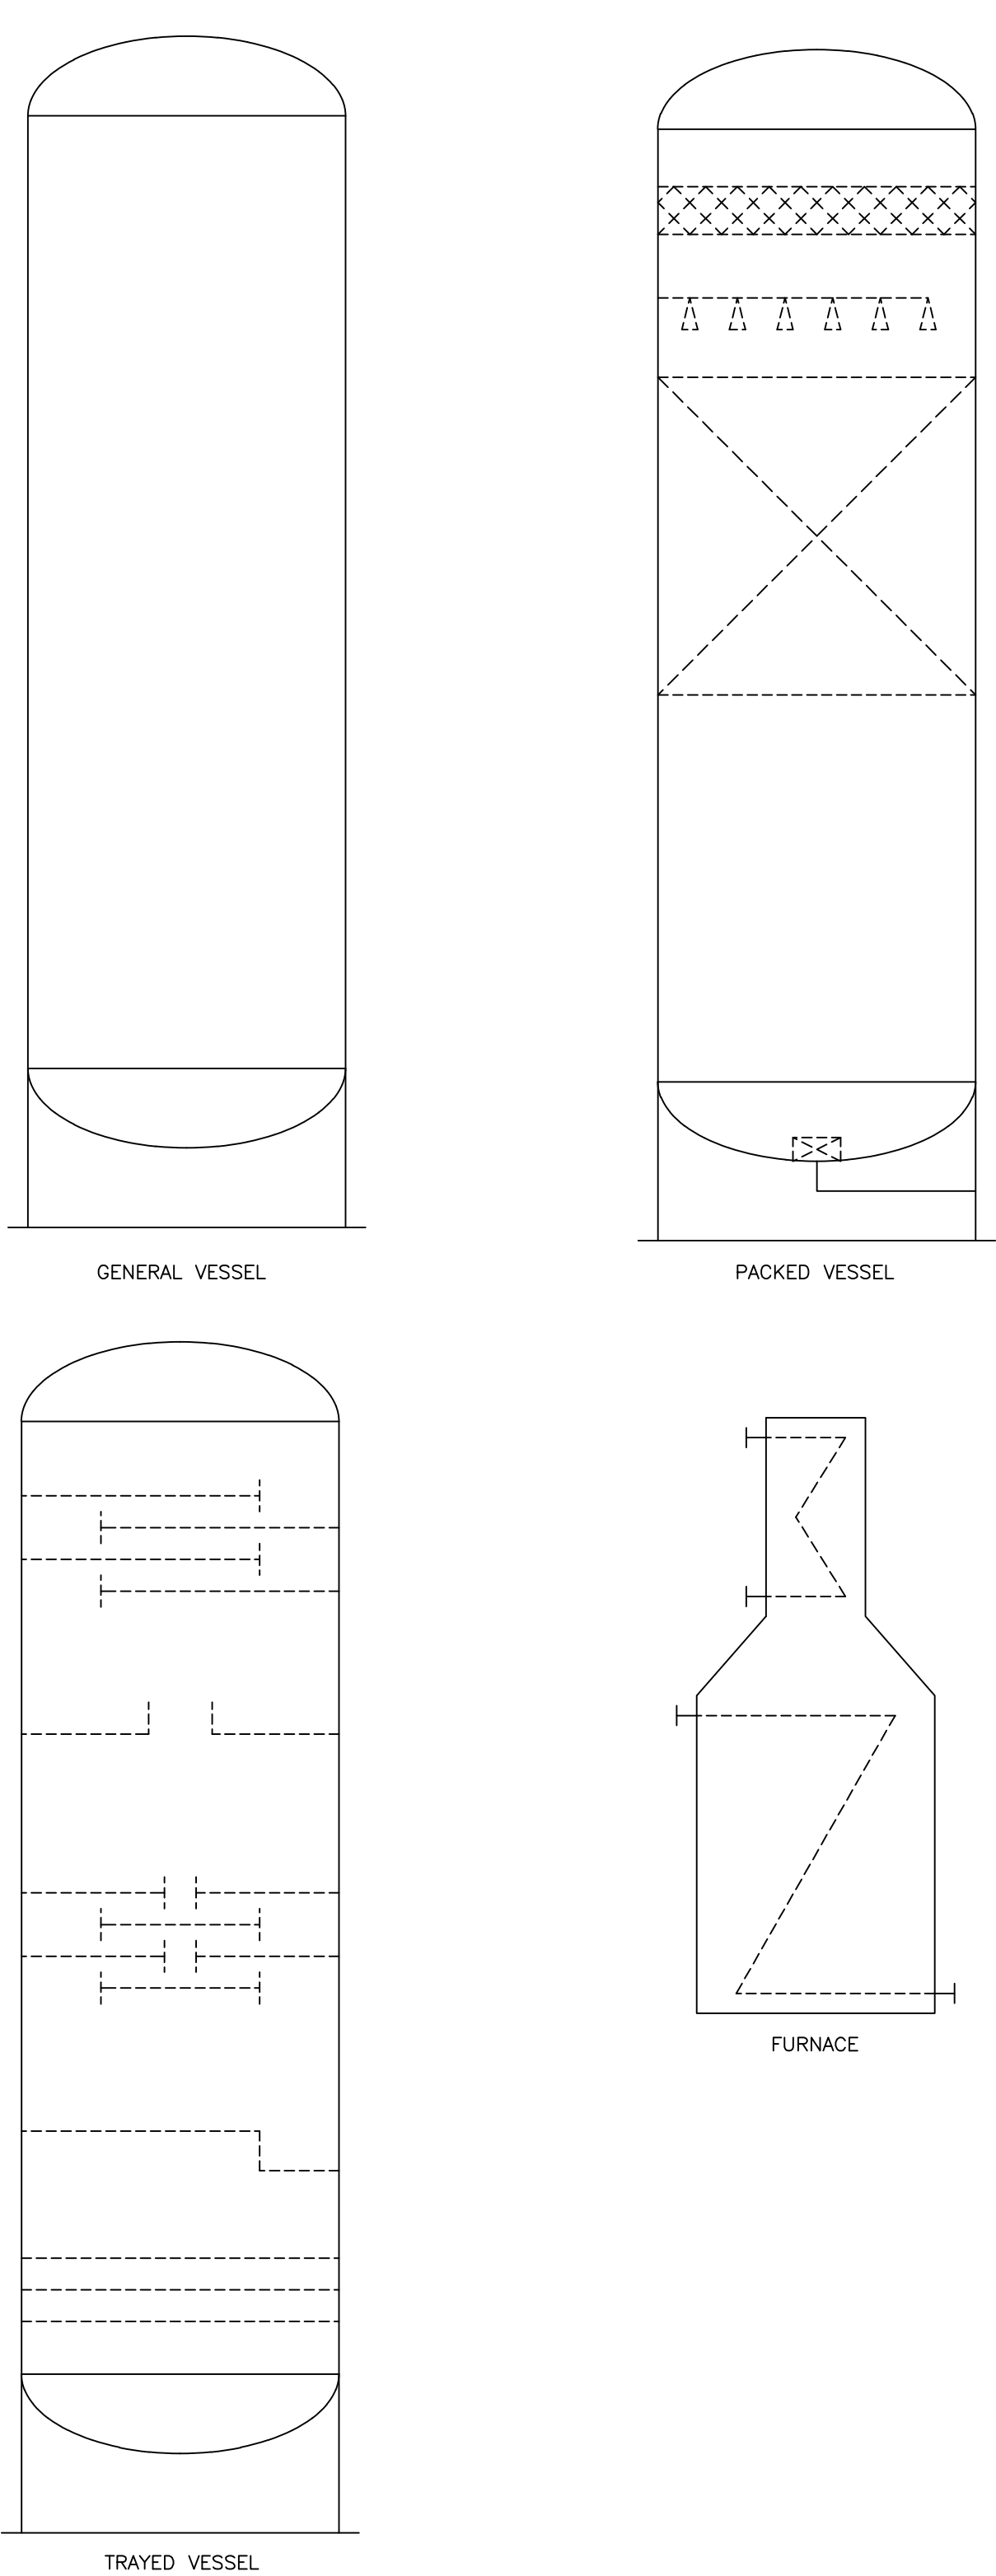

General Notes

00	INITIAL ISSUE, FOR PRELIMINARY COMMENTS	J.ANDRUS
		BY DATE
REV NO	REVISION DESCRIPTION	BY DATE



ANDRUS DRAFTING & DESIGN, LLC
1025 ASSISI LANE, #607
ATLANTIC BEACH, FLORIDA 32233
ANDRUS.DRAFTING.DESIGN@GMAIL.COM
(904) 426-4899

PROJECT INFORMATION
CLIENT: ANDRUS DRAFTING & DESIGN, LLC
CLIENT PROJECT NUMBER: 18000
ADD PROJECT NUMBER: 18000

PROJECT DESCRIPTION
ANDRUS DRAFTING & DESIGN, LLC. PLANT 3D TEMPLATE PROJECT

DRAWING INFORMATION
DRAWING TYPE: PROCESS & INSTRUMENT DIAGRAM
FLUE GAS SCRUBBING SYSTEM
P&ID LEGEND SHEET 2

DIVISION OF WORK AREA:	00	DRAWING STATUS
DRAWING NUMBER: 18000-PID-00-002-02		ISSUED FOR PRELIMINARY COMMENTS ONLY
DRAWN BY: J.ANDRUS		
DRAWN DATE: 9/7/2018		
APPROVED BY:		
APPROVED DATE:		