


BENNETT BATHROOM & WALK-IN CLOSET REMODELING PROJECT


DRAWING INDEX

SHEET NUMBER	TITLE
1	AS-BUILT AND DEMOLITION PLANS
2	PROPOSED FLOOR PLANS
3	PERSPECTIVE OVERVIEWS
4	WALL ELEVATIONS (1 OF 2)
5	WALL ELEVATIONS (2 OF 2)
6	DESIGN SPECIFICATIONS
7-13	RENDERINGS




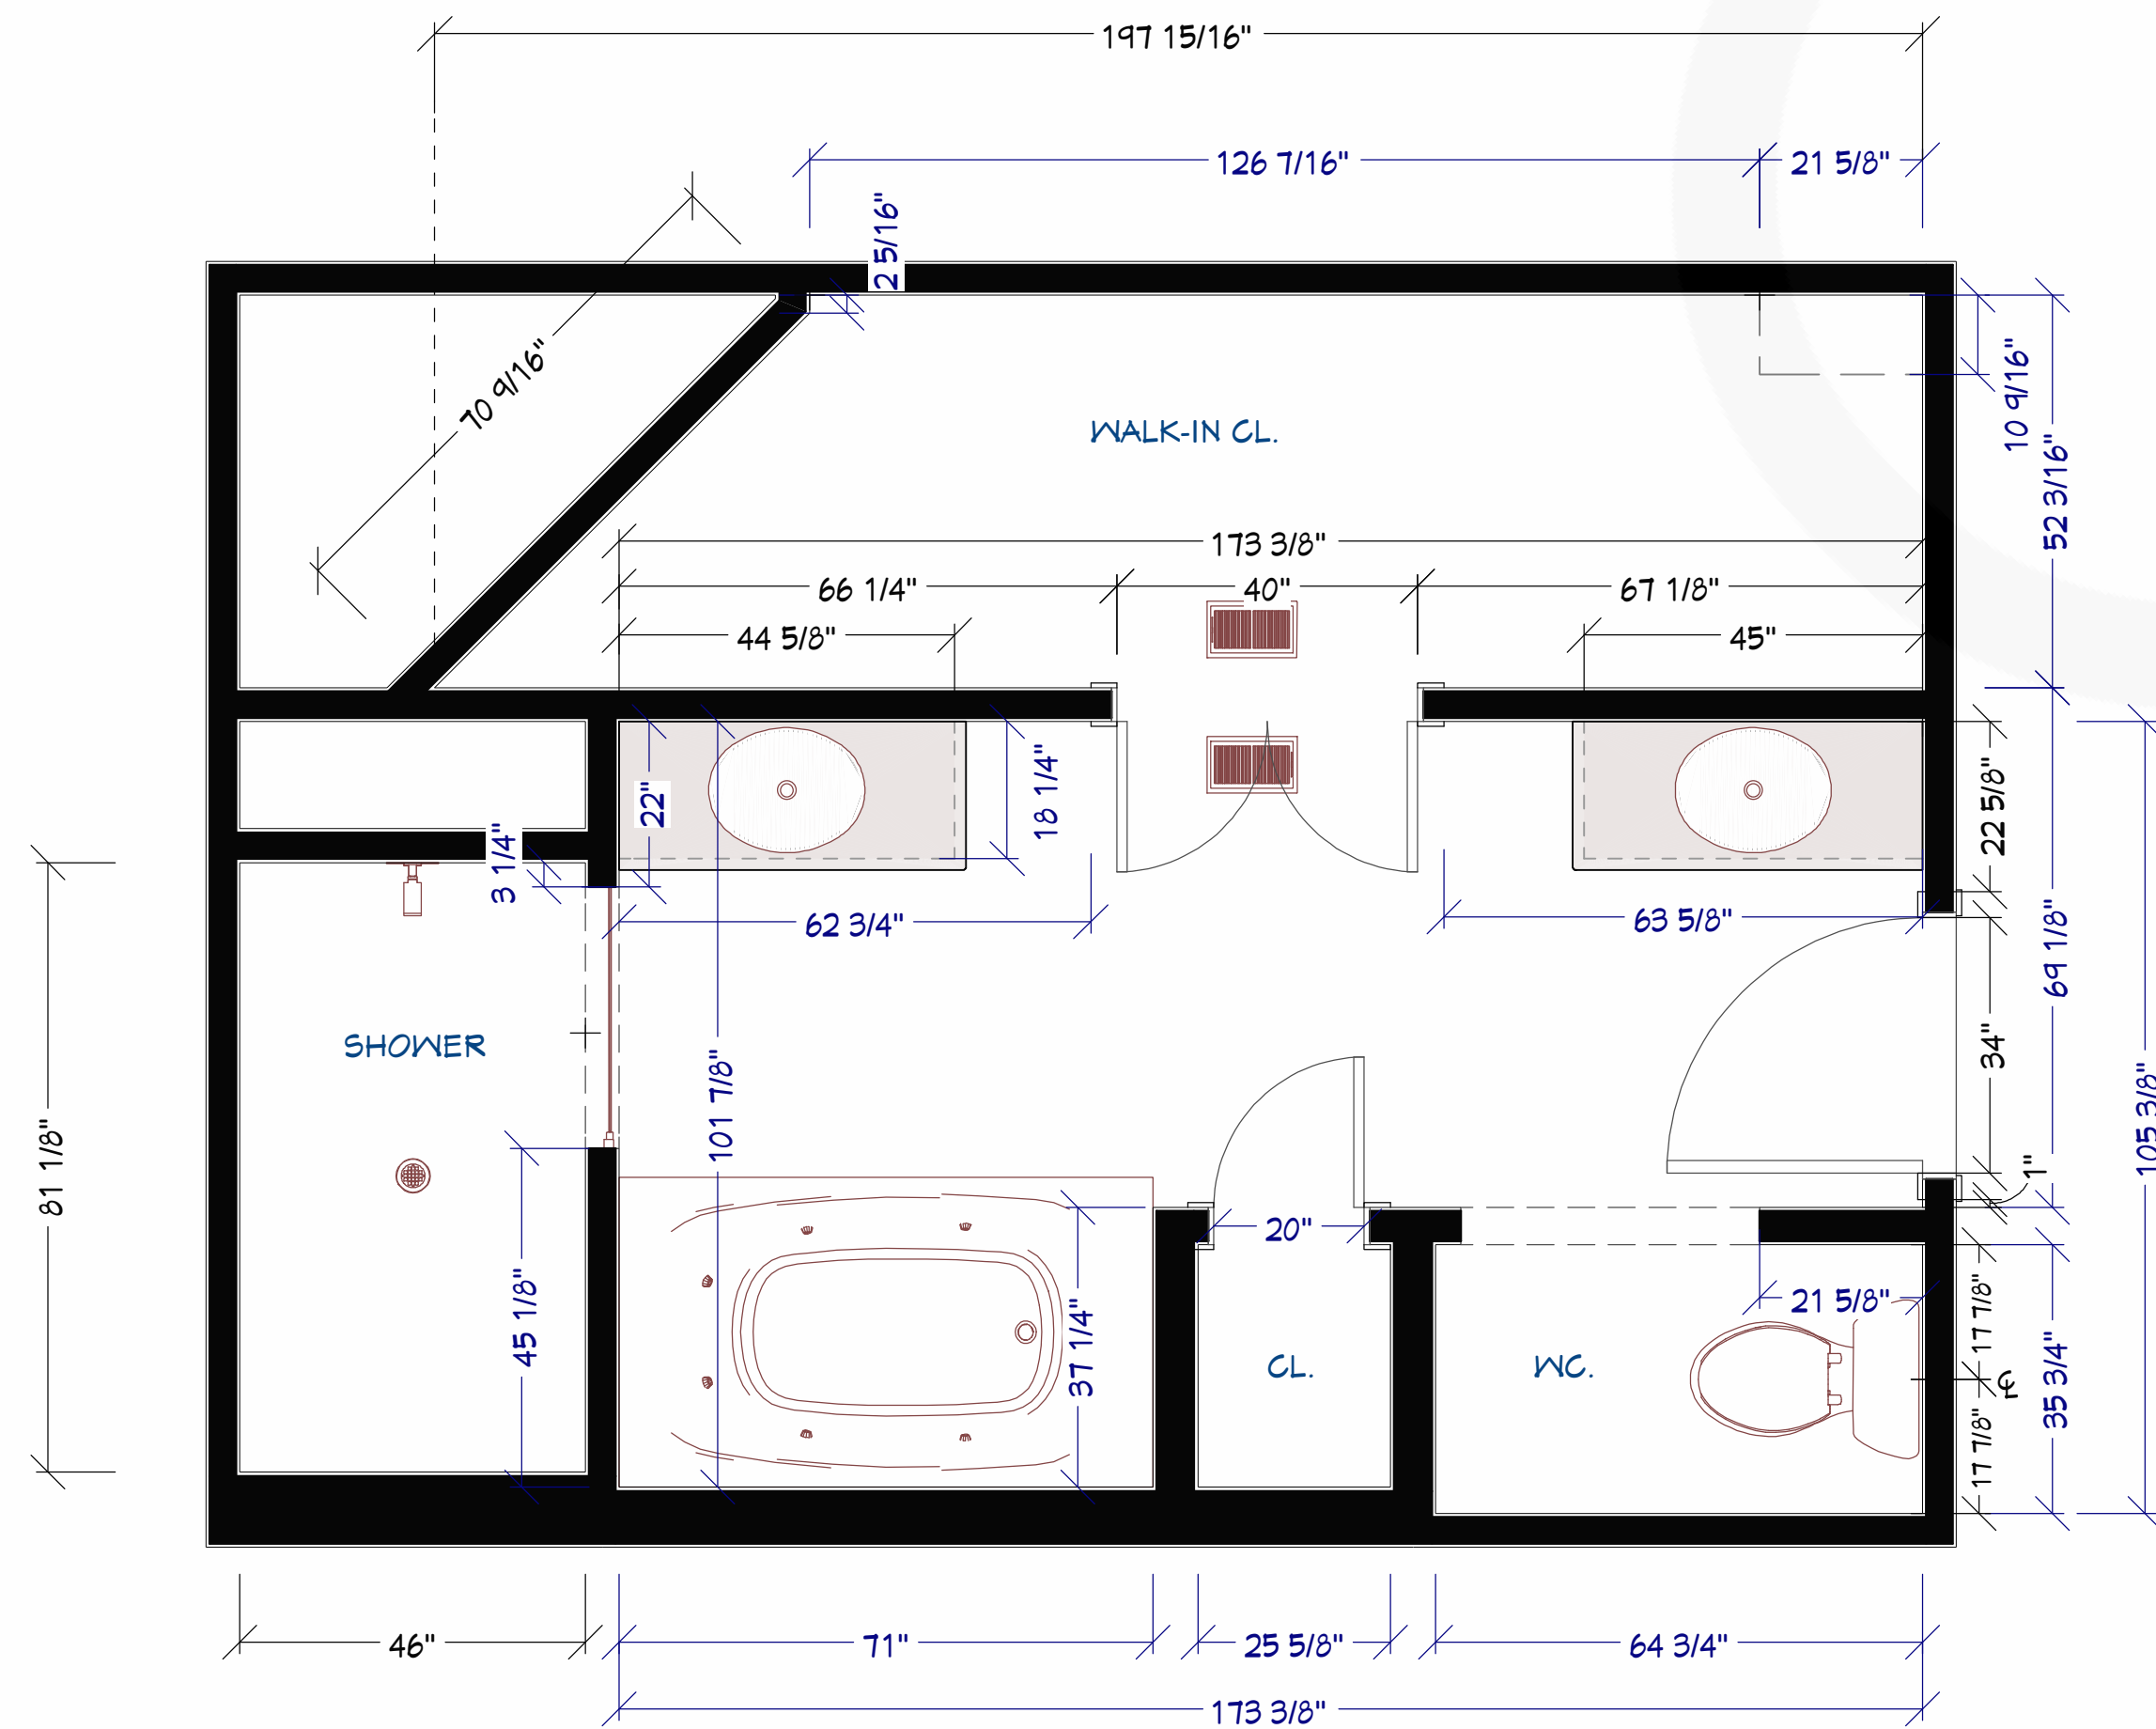

AS-BUILT PLAN
SCALE TO 1/2" = 1' ON ARCH D

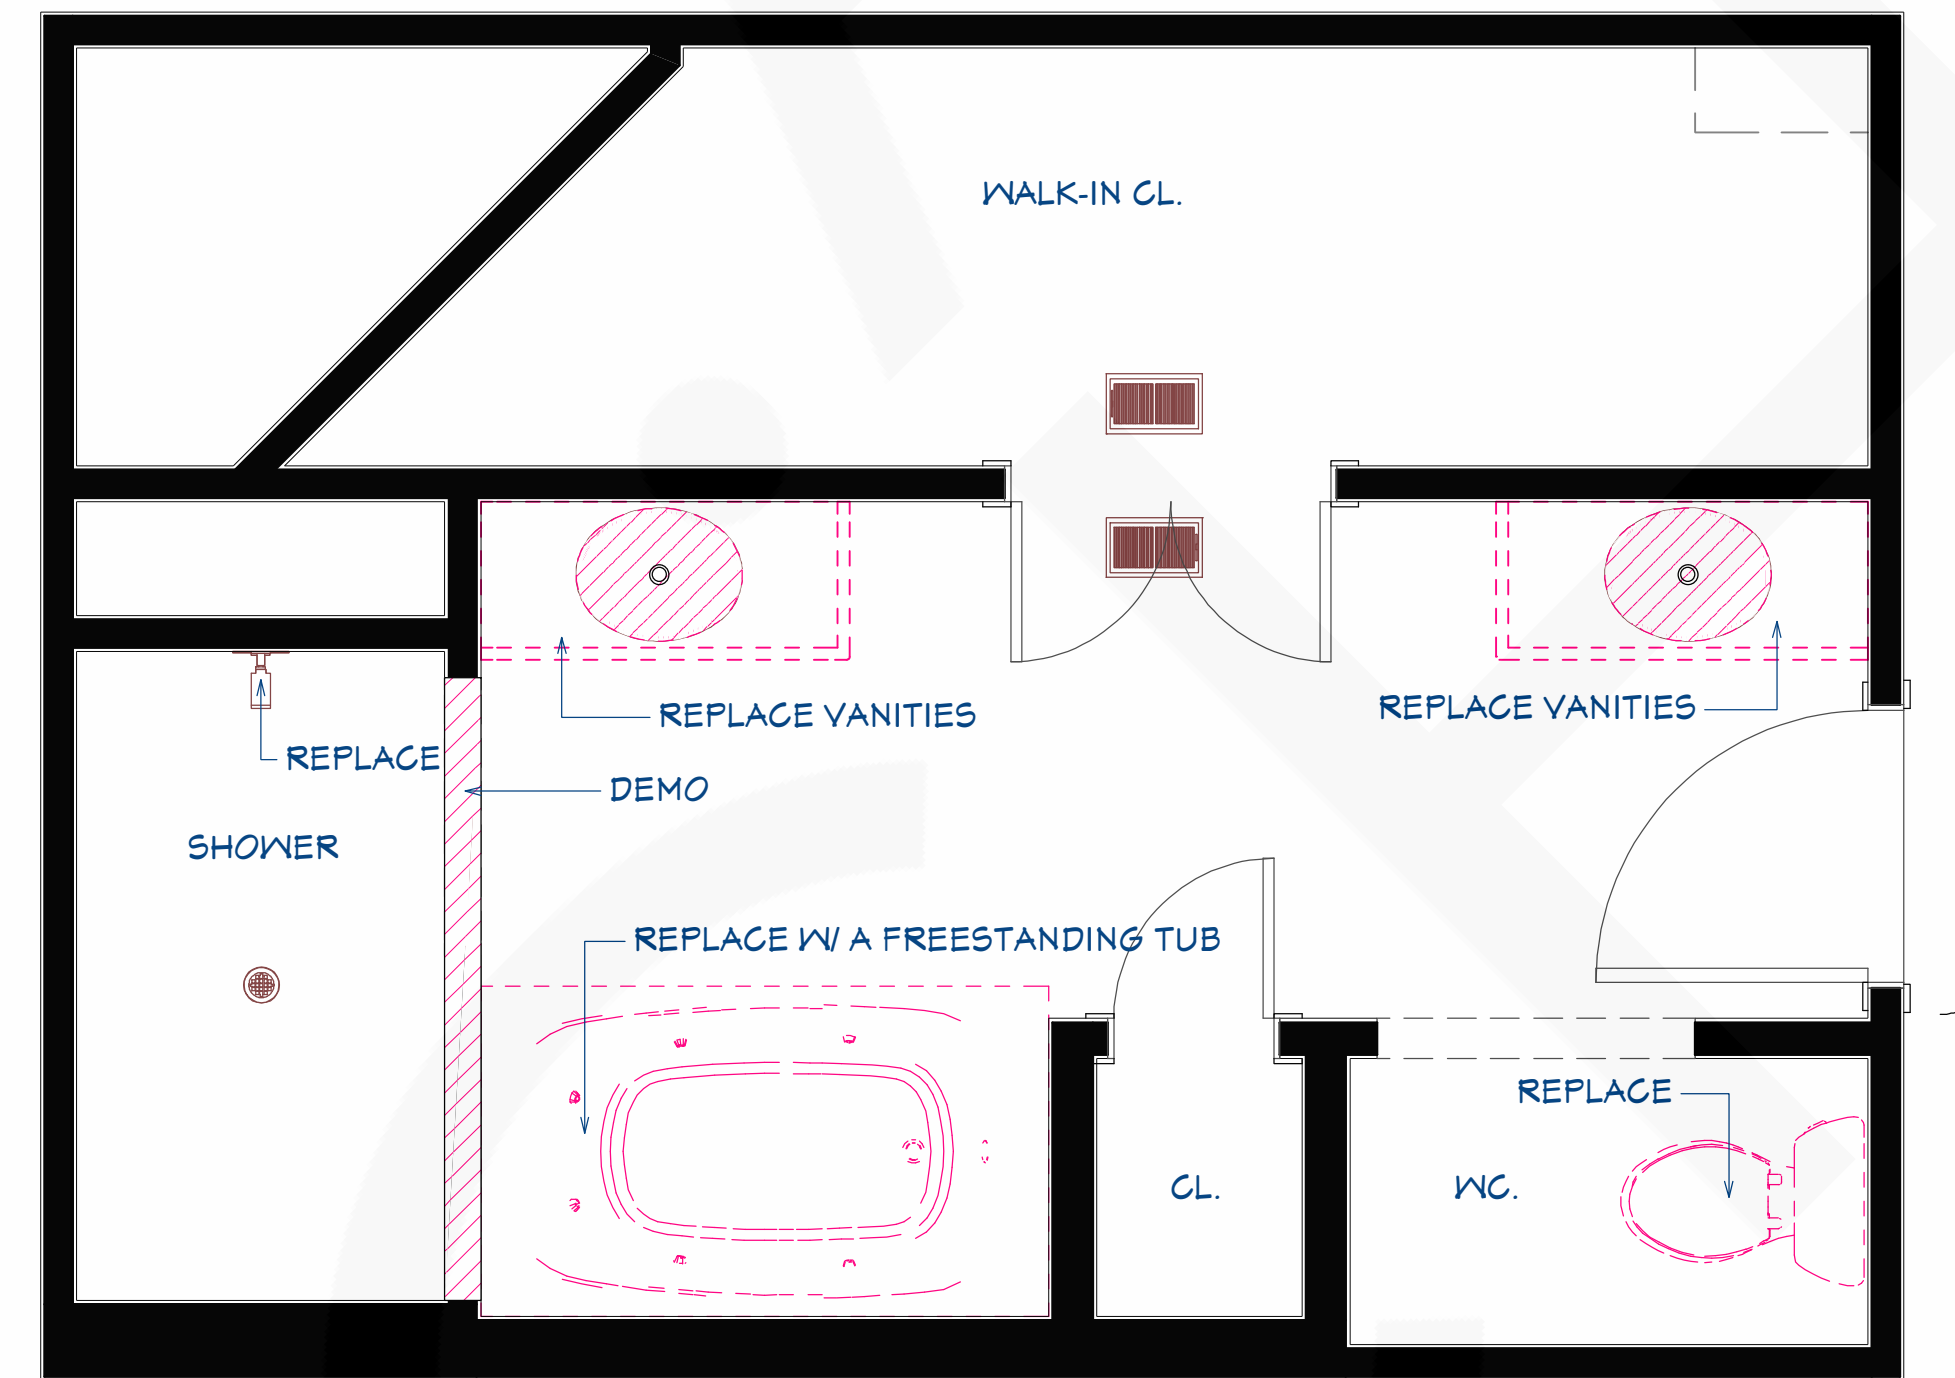

 PROPOSED DEMOLITION PLAN
SCALE TO 1/2" = 1' ON ARCH D



SHEET #	DRAWINGS BY:	DATE:
1	Oz G.	2025.7.28


PROJECT DESCRIPTION
Bathroom & Walk-In Closet Remodel – Bennett Residence

SHEET TITLE	SCALE	PAGE SIZE
As-Built and Demolition Plans	1/2" = 1'	ARCH D


REVISION TABLE			
NUMBER	DATE	REVISED BY	DESCRIPTION

COPYRIGHT
All rights reserved. These drawings, plans and specifications and the copyright are the property of Gir.Arch © and must not be used, reproduced or copied wholly or in part without the written permission of Gir.Arch ©


GIR.Arch

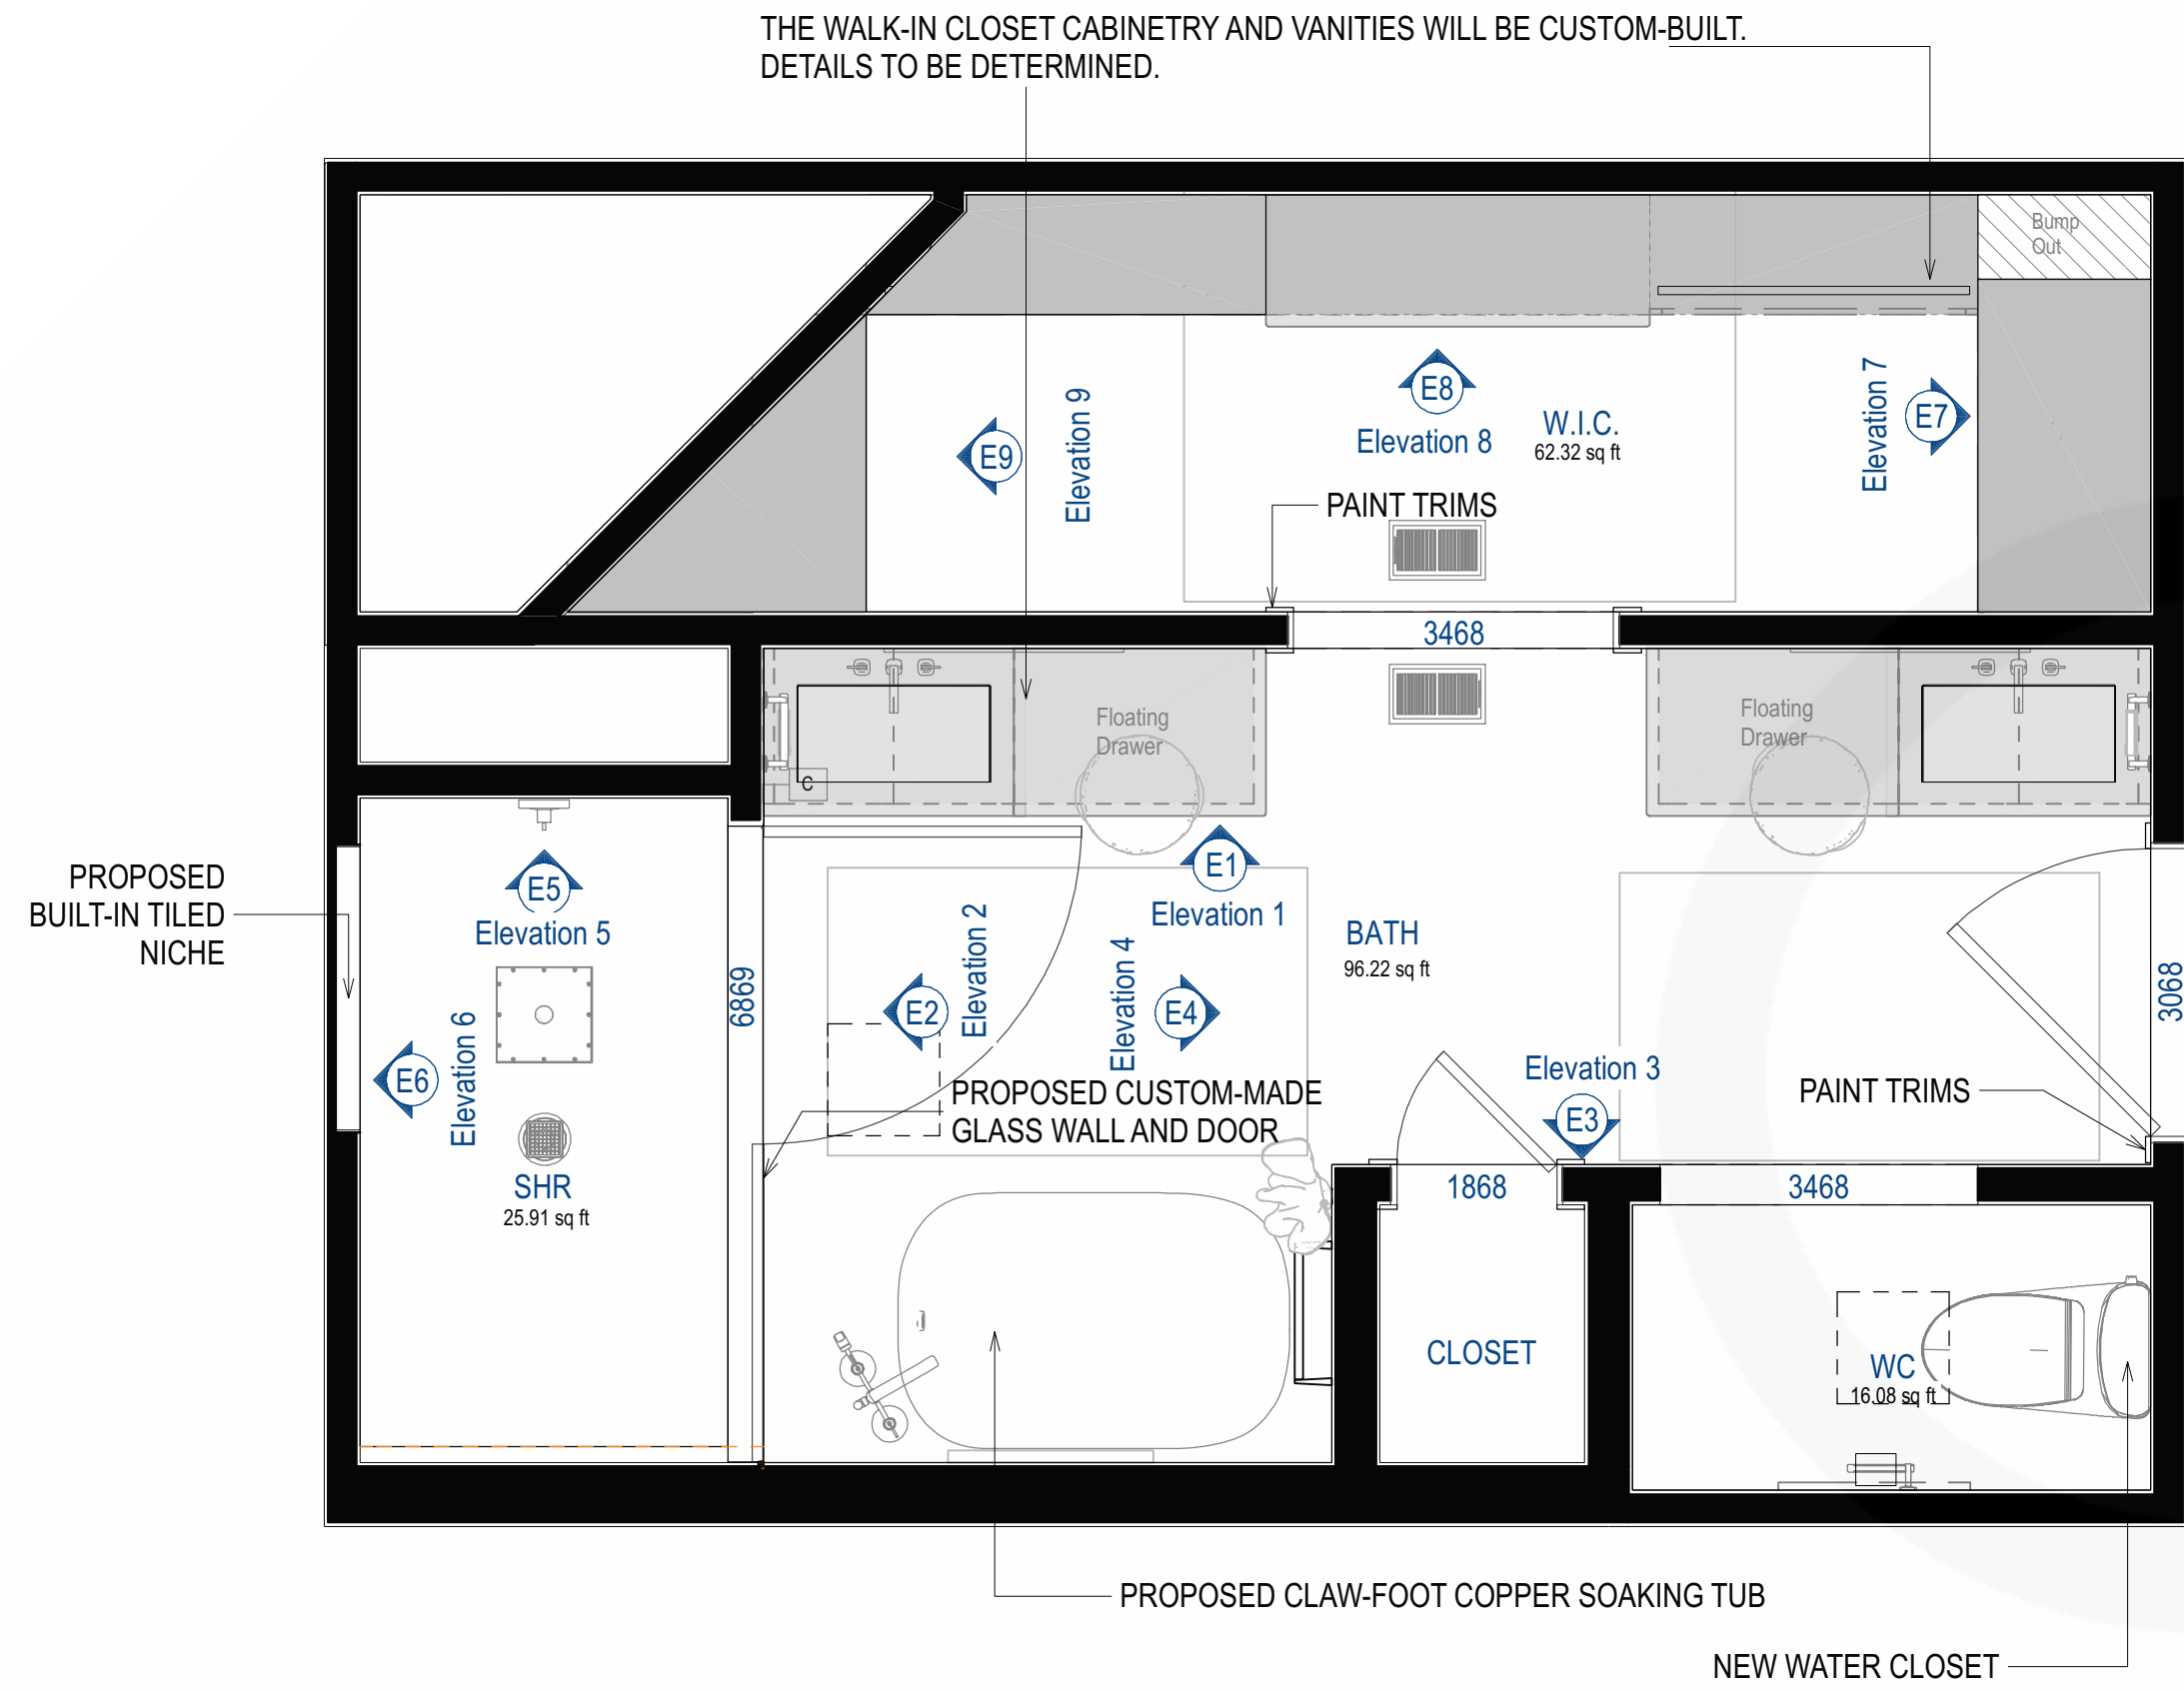


PROPOSED FLOOR PLAN
SCALE TO 1/2" = 1' ON ARCH D

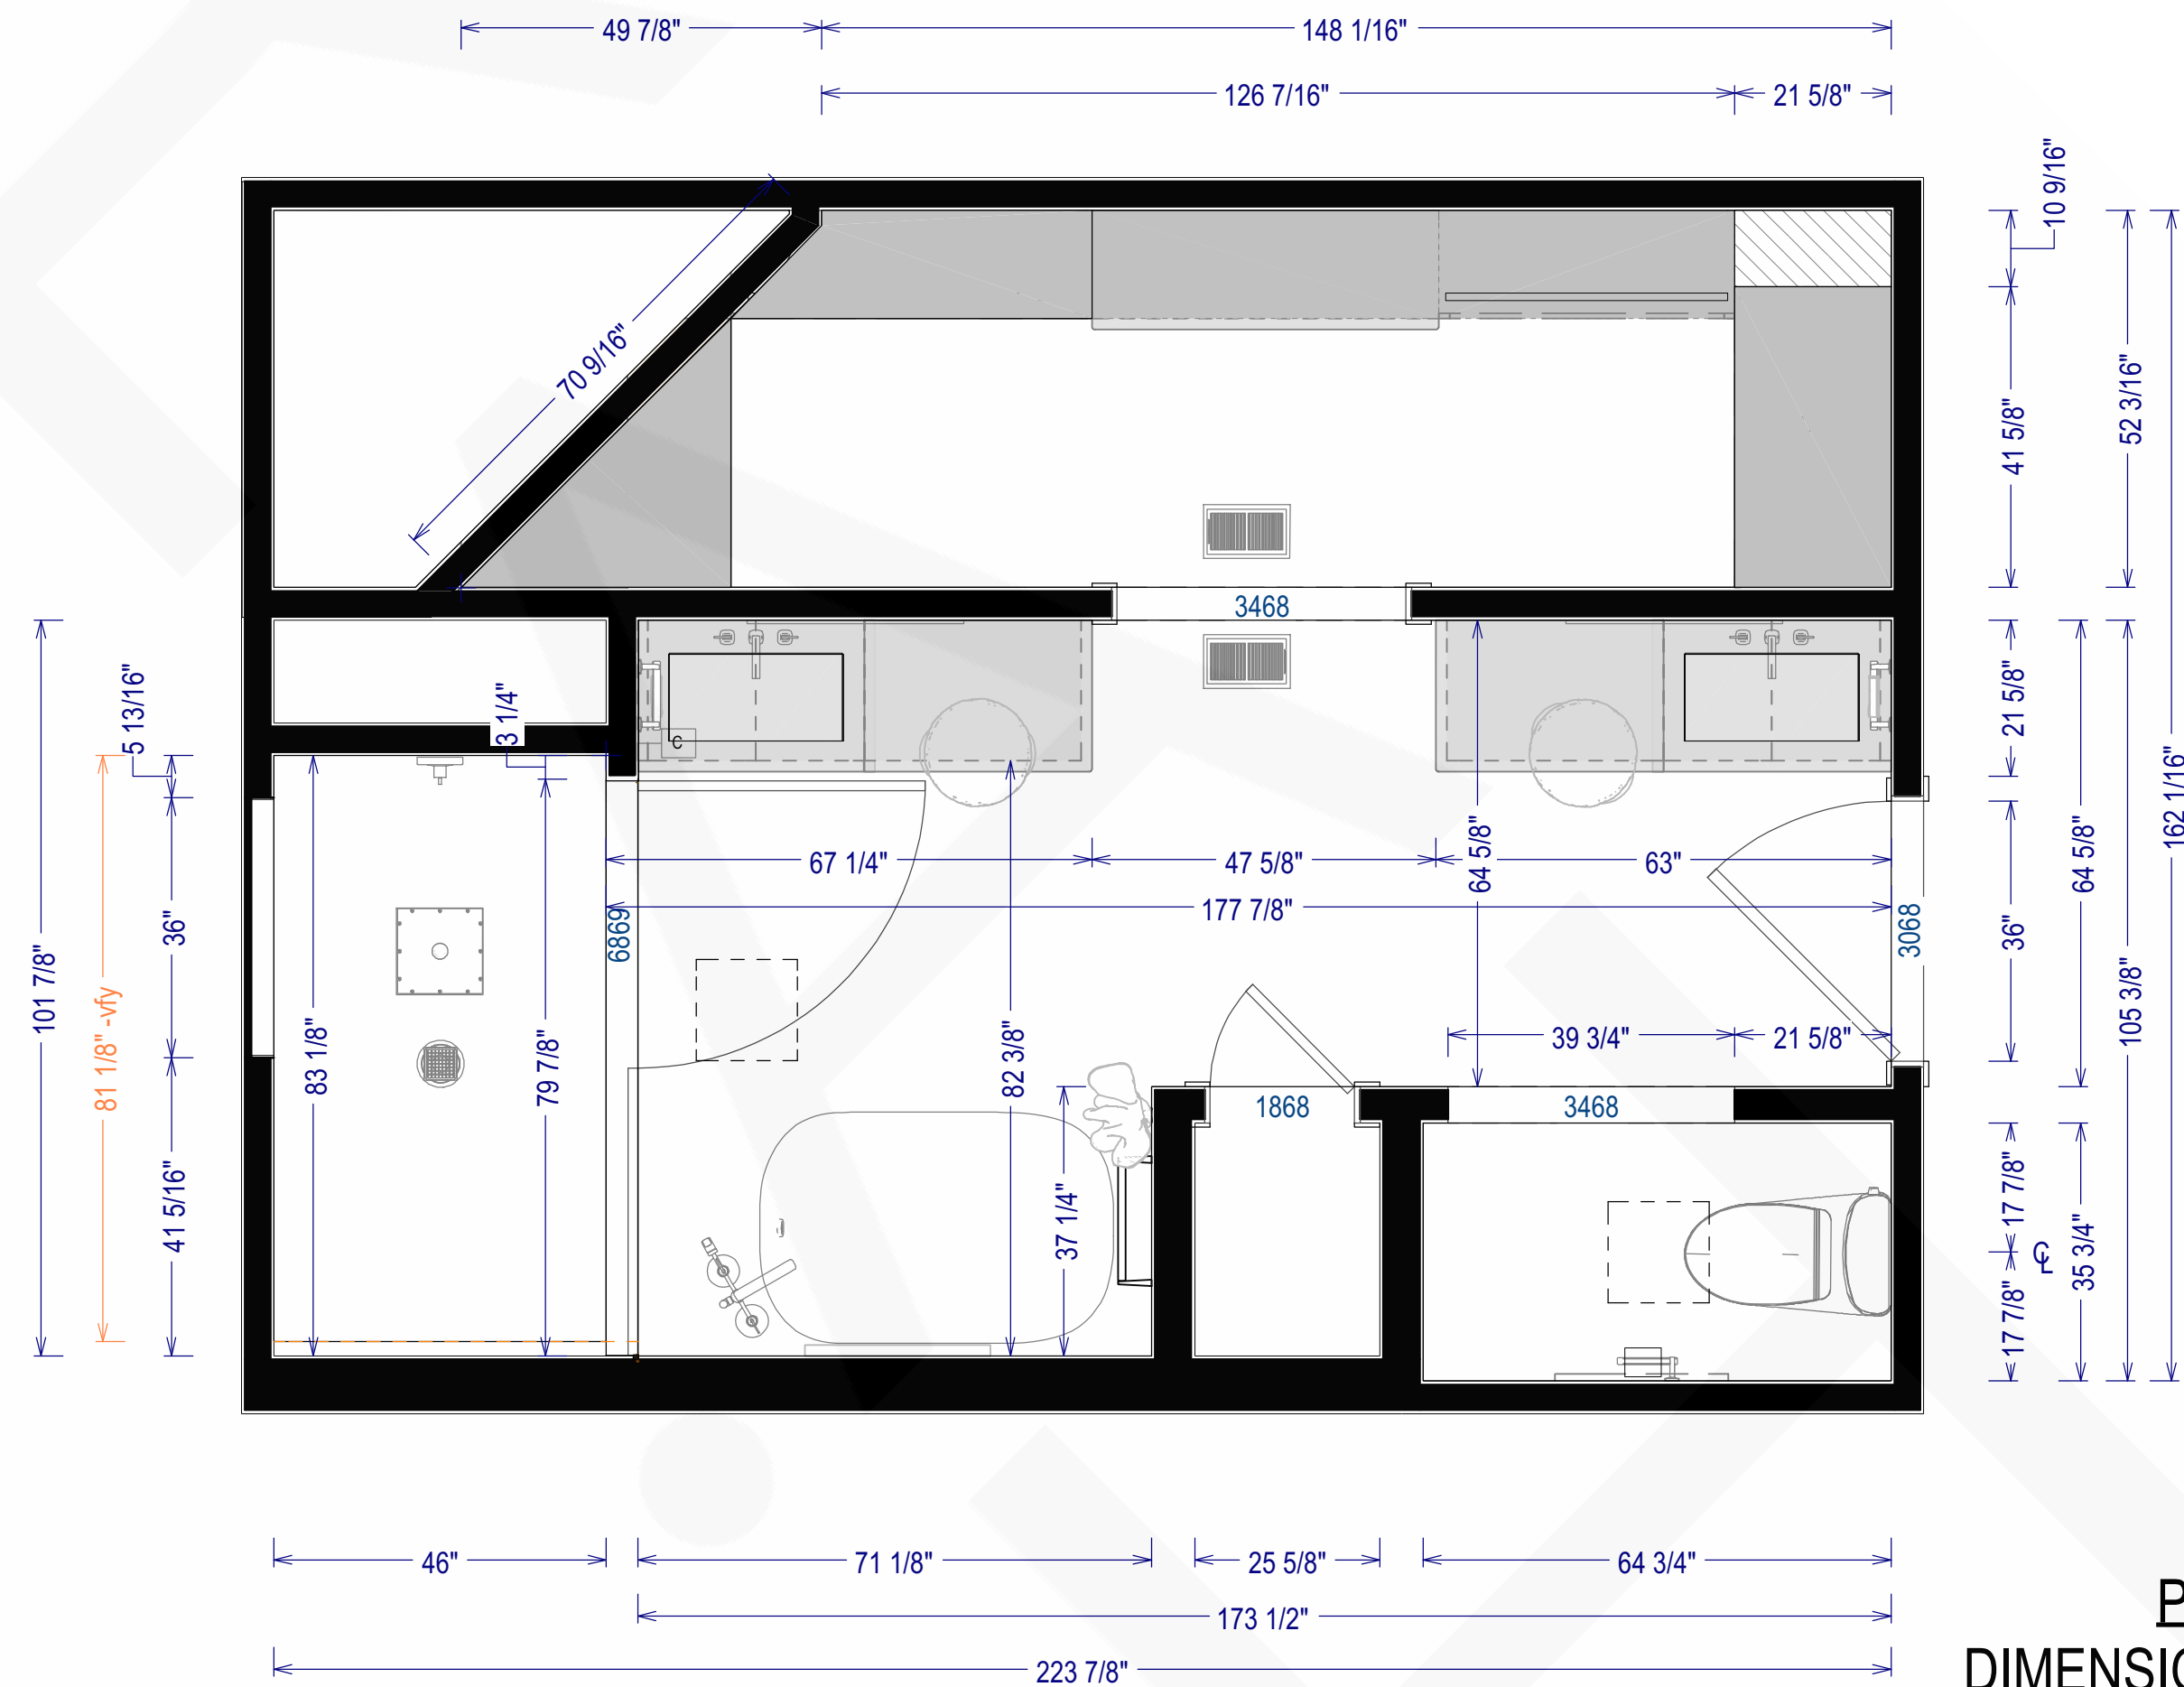


**PROPOSED DESIGN
DIMENSIONED FLOOR PLAN**
SCALE TO 1/2" = 1' ON ARCH D

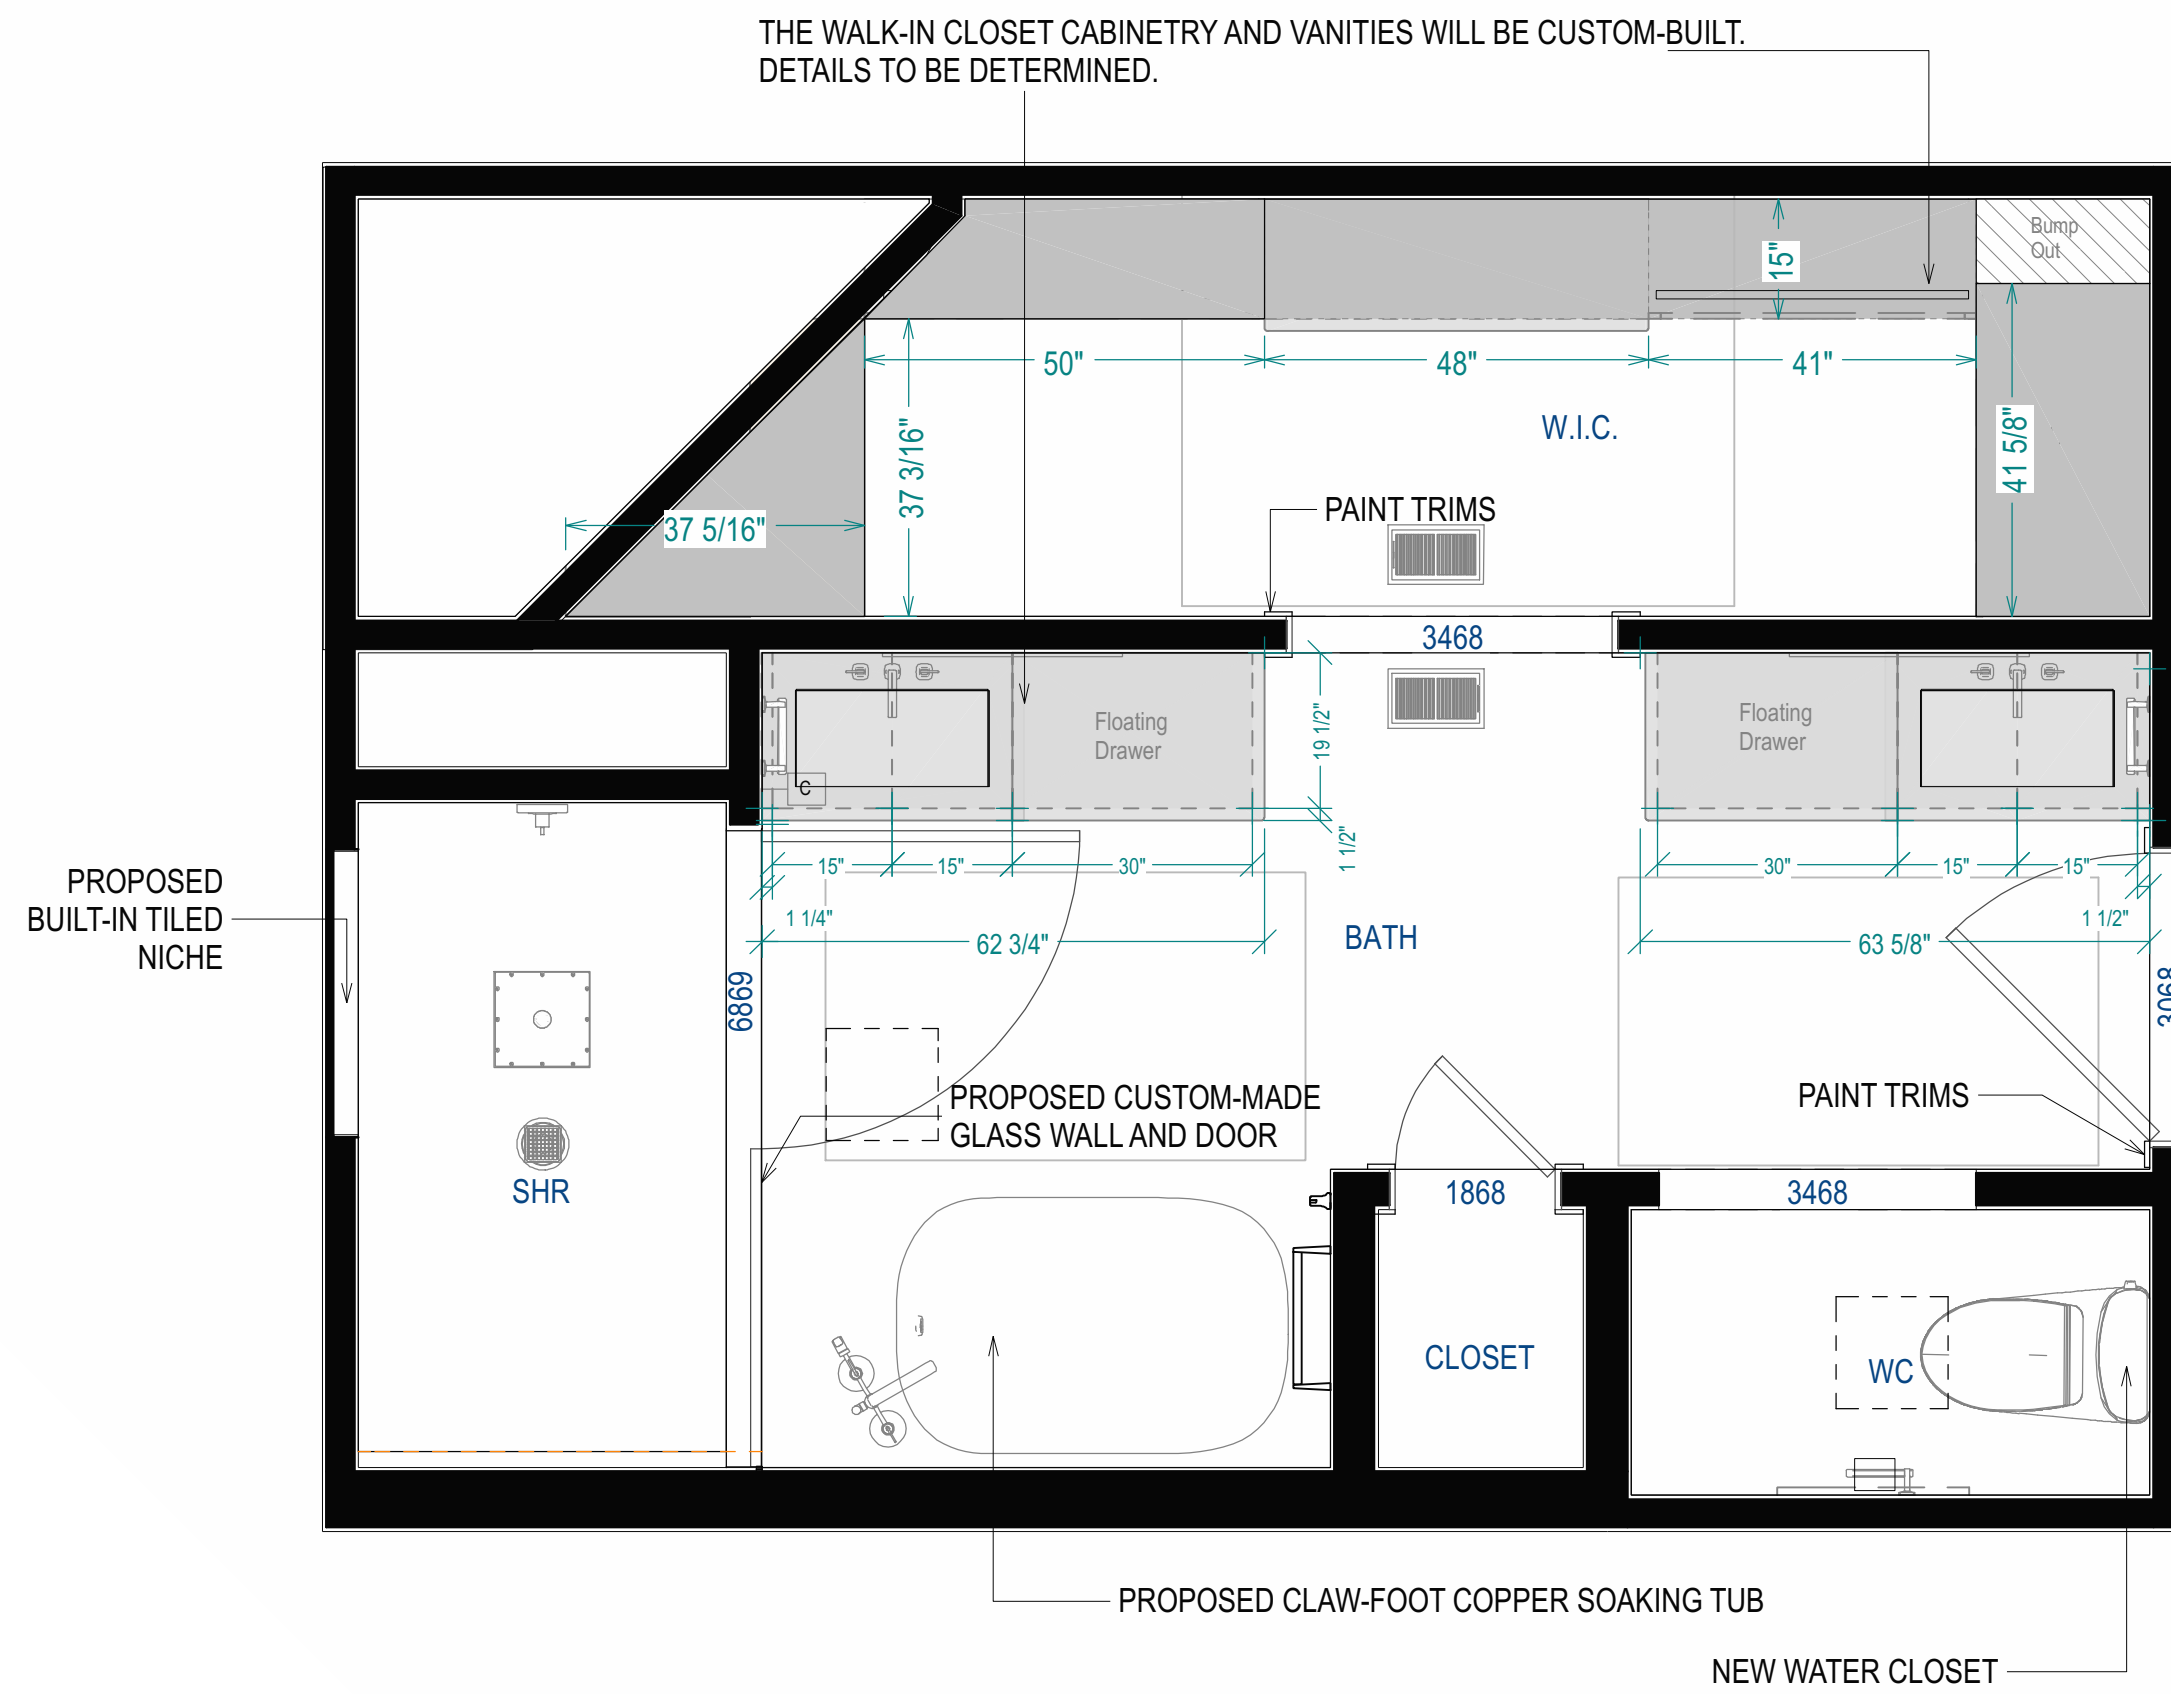


**PROPOSED DESIGN
w/ CABINETRY & COUNTERTOP DIMENSIONS**
SCALE TO 1/2" = 1' ON ARCH D

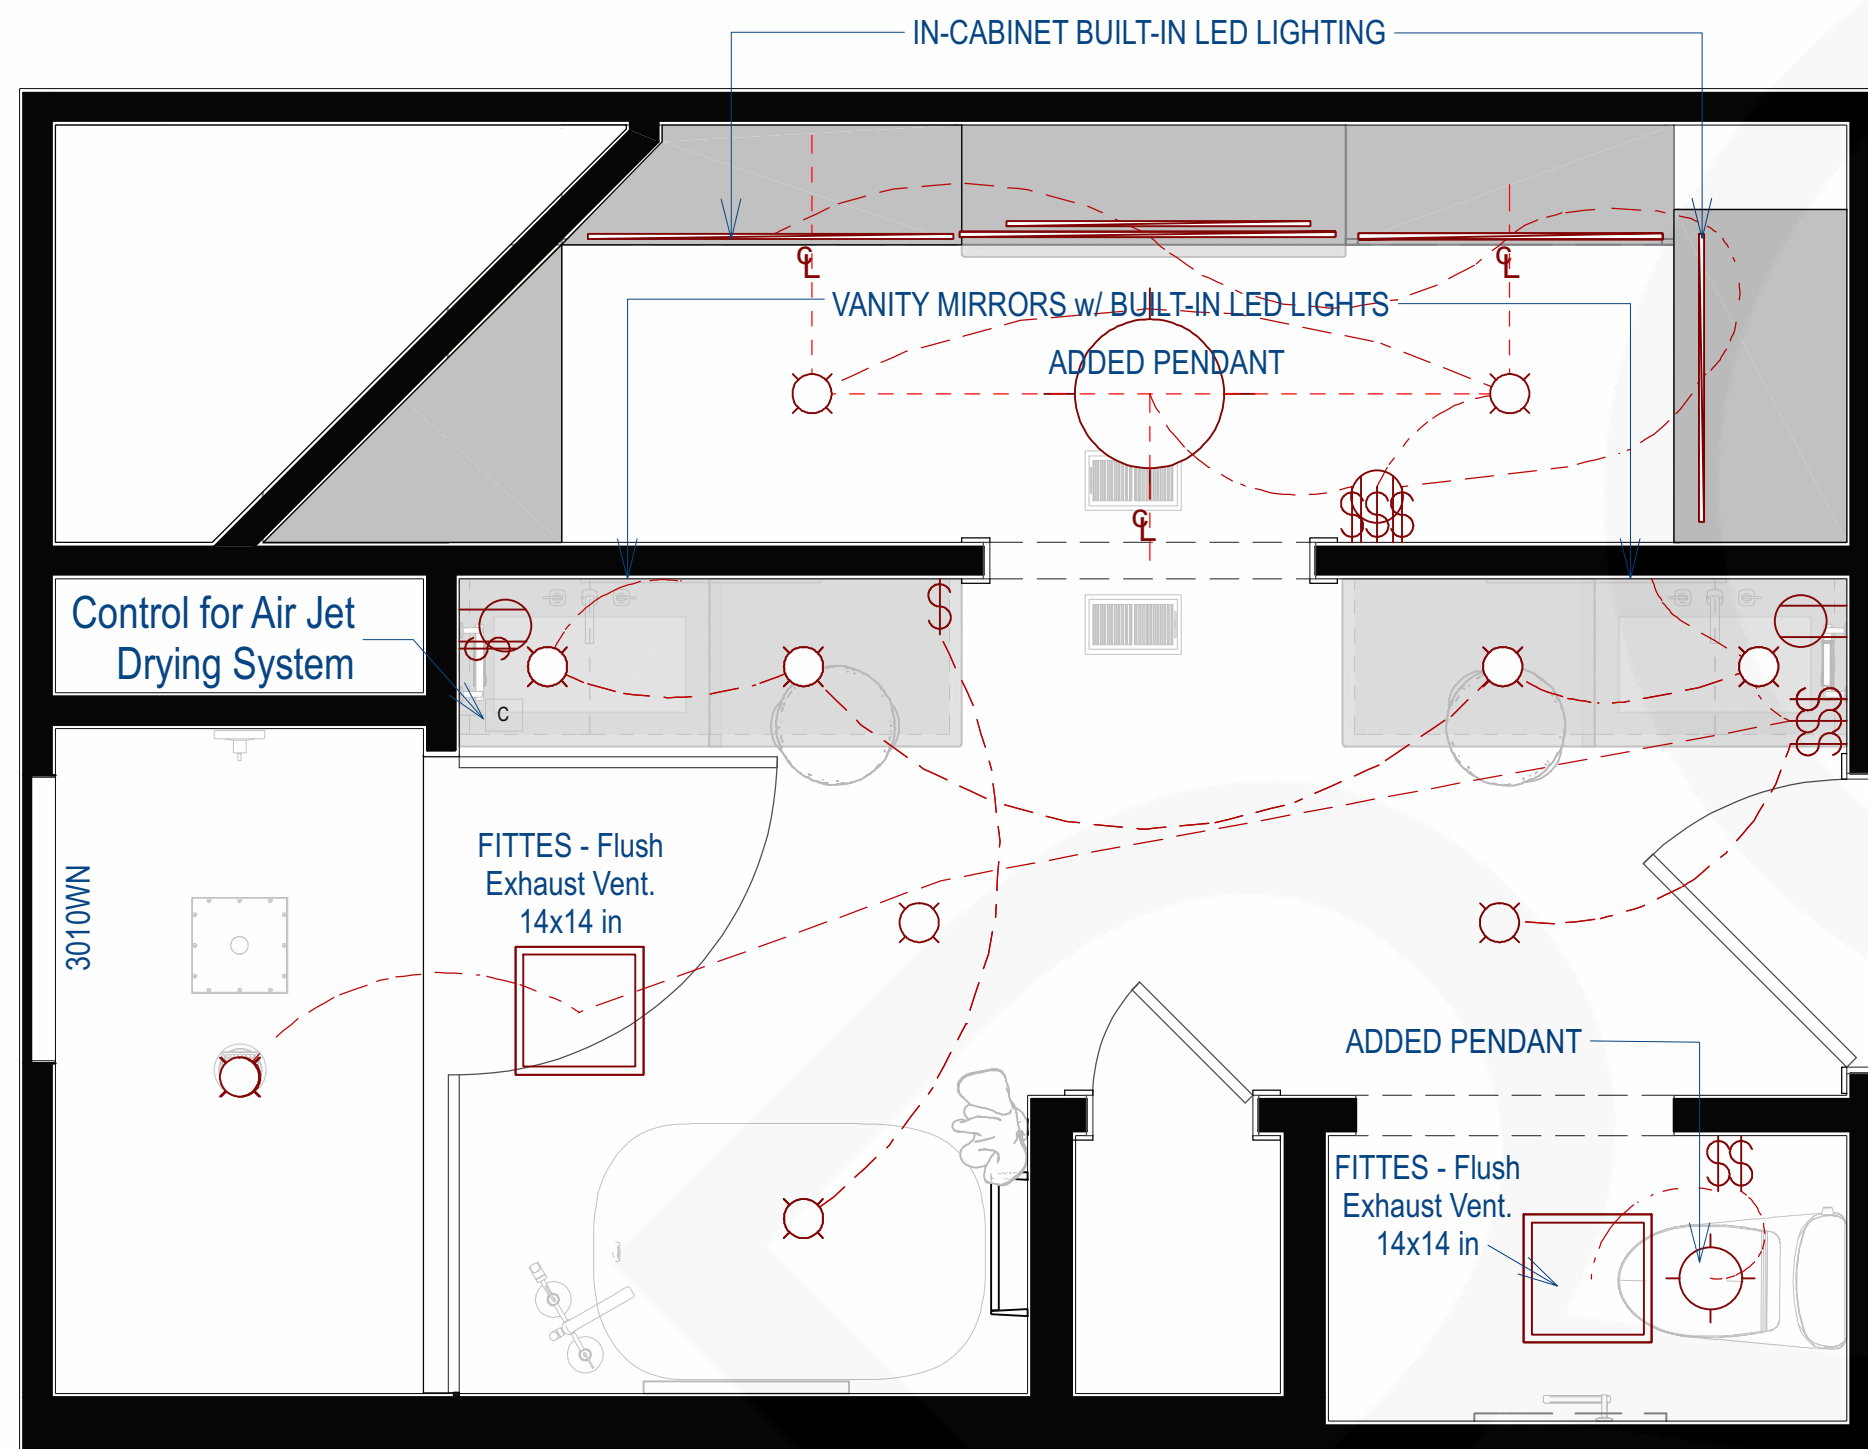

PROPOSED RCP & ELECTRICAL PLAN
SCALE TO 1/2" = 1' ON ARCH D

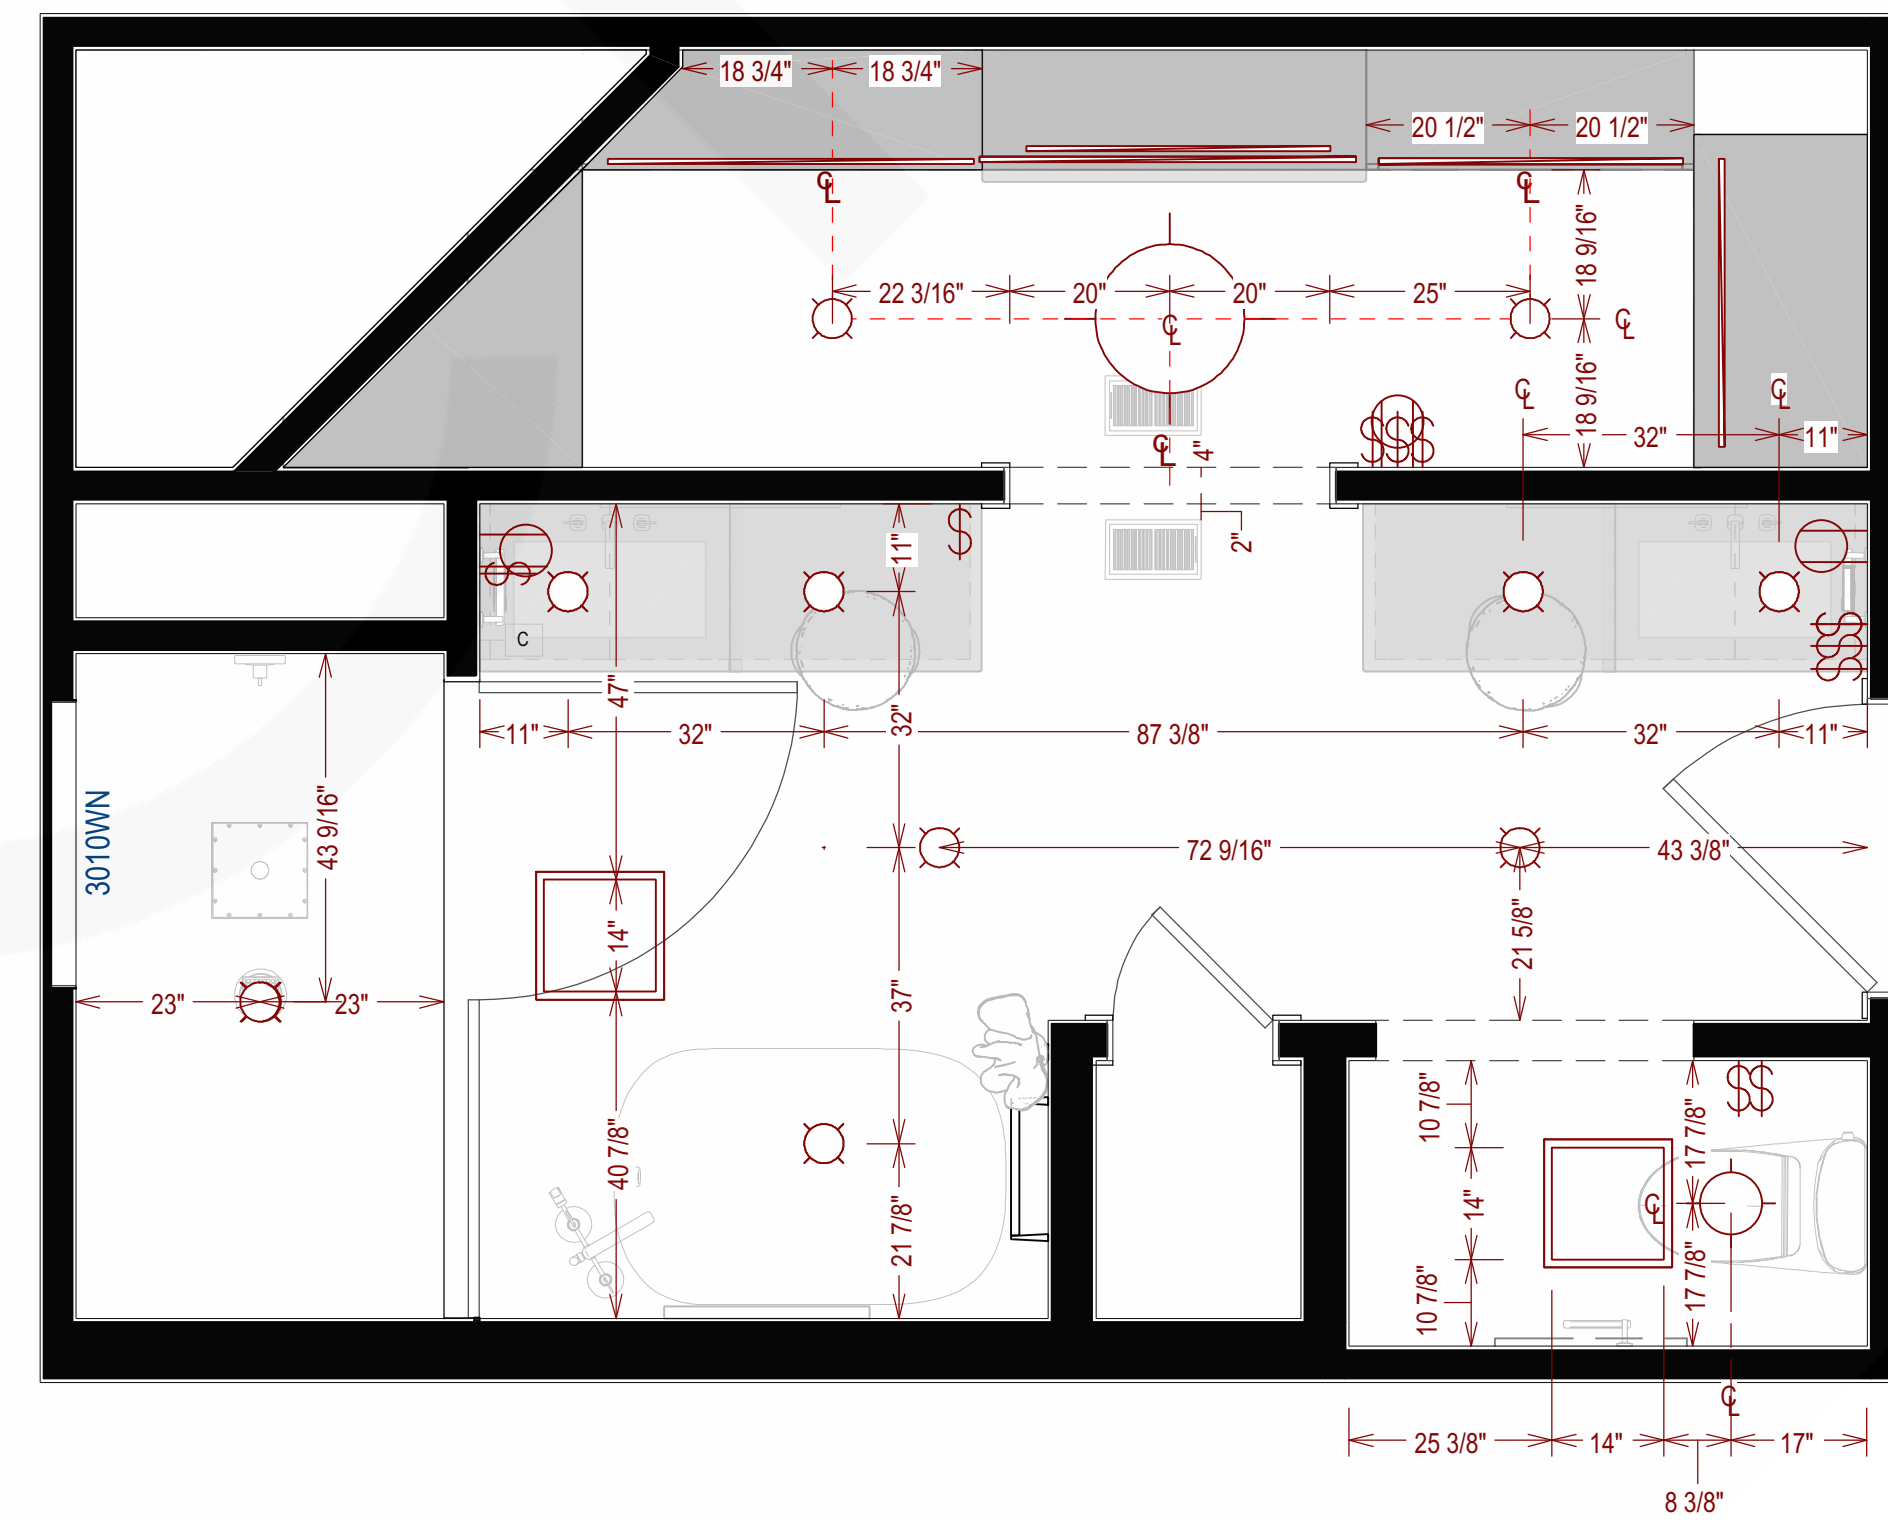

 PROPOSED RCP & ELECTRICAL PLAN WITH DIMENSIONS
SCALE TO 1/2" = 1' ON ARCH D







AXONOMETRIC OVERVIEW-1
NTS




AXONOMETRIC OVERVIEW-2
NTS

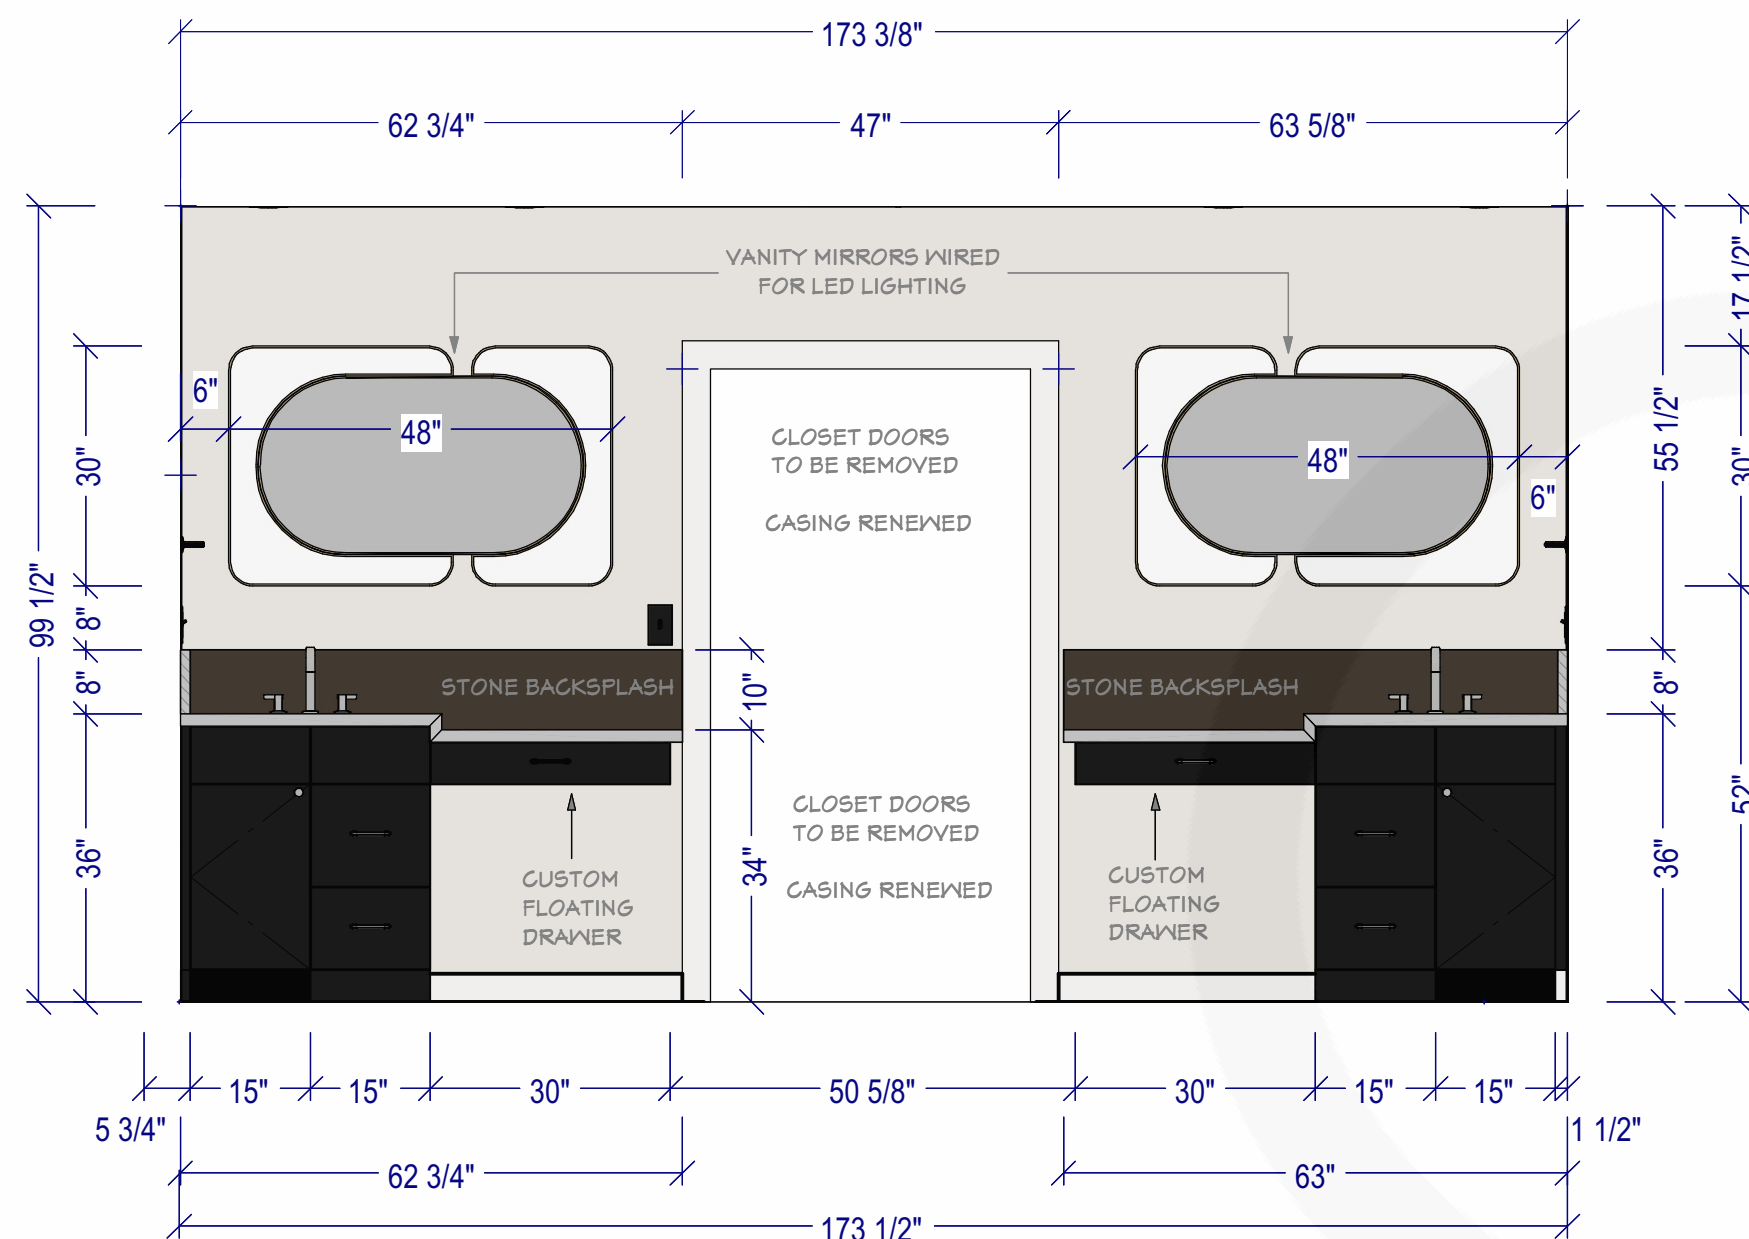


WALL ELEVATION-1
SCALE TO 1/2" = 1' ON ARCH D

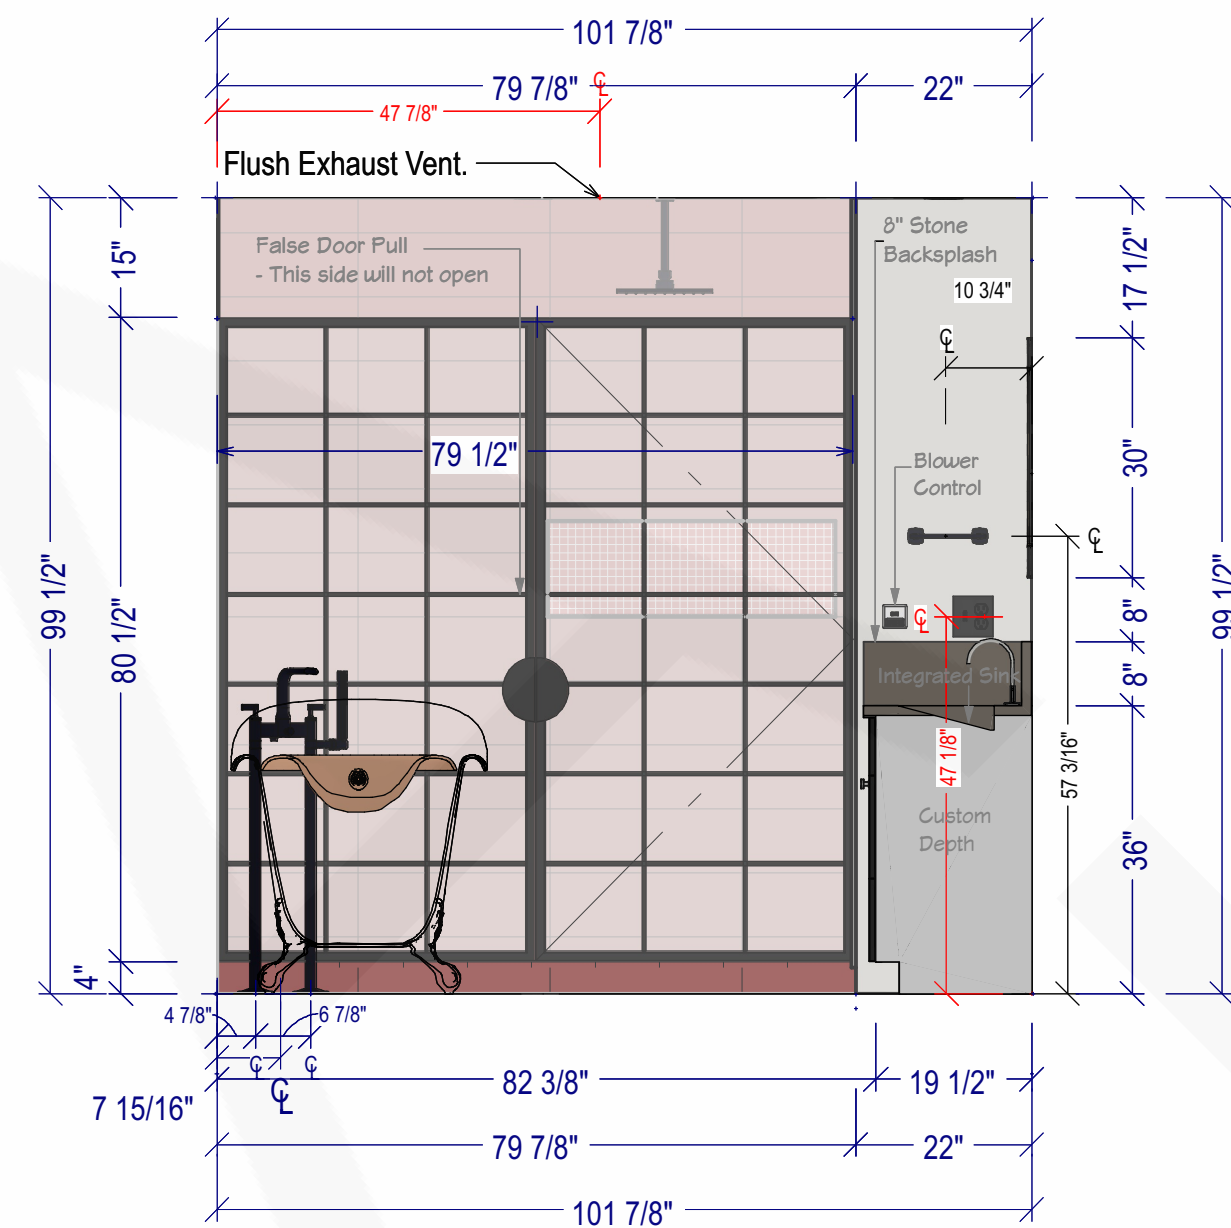


WALL ELEVATION-2
SCALE TO 1/2" = 1' ON ARCH D

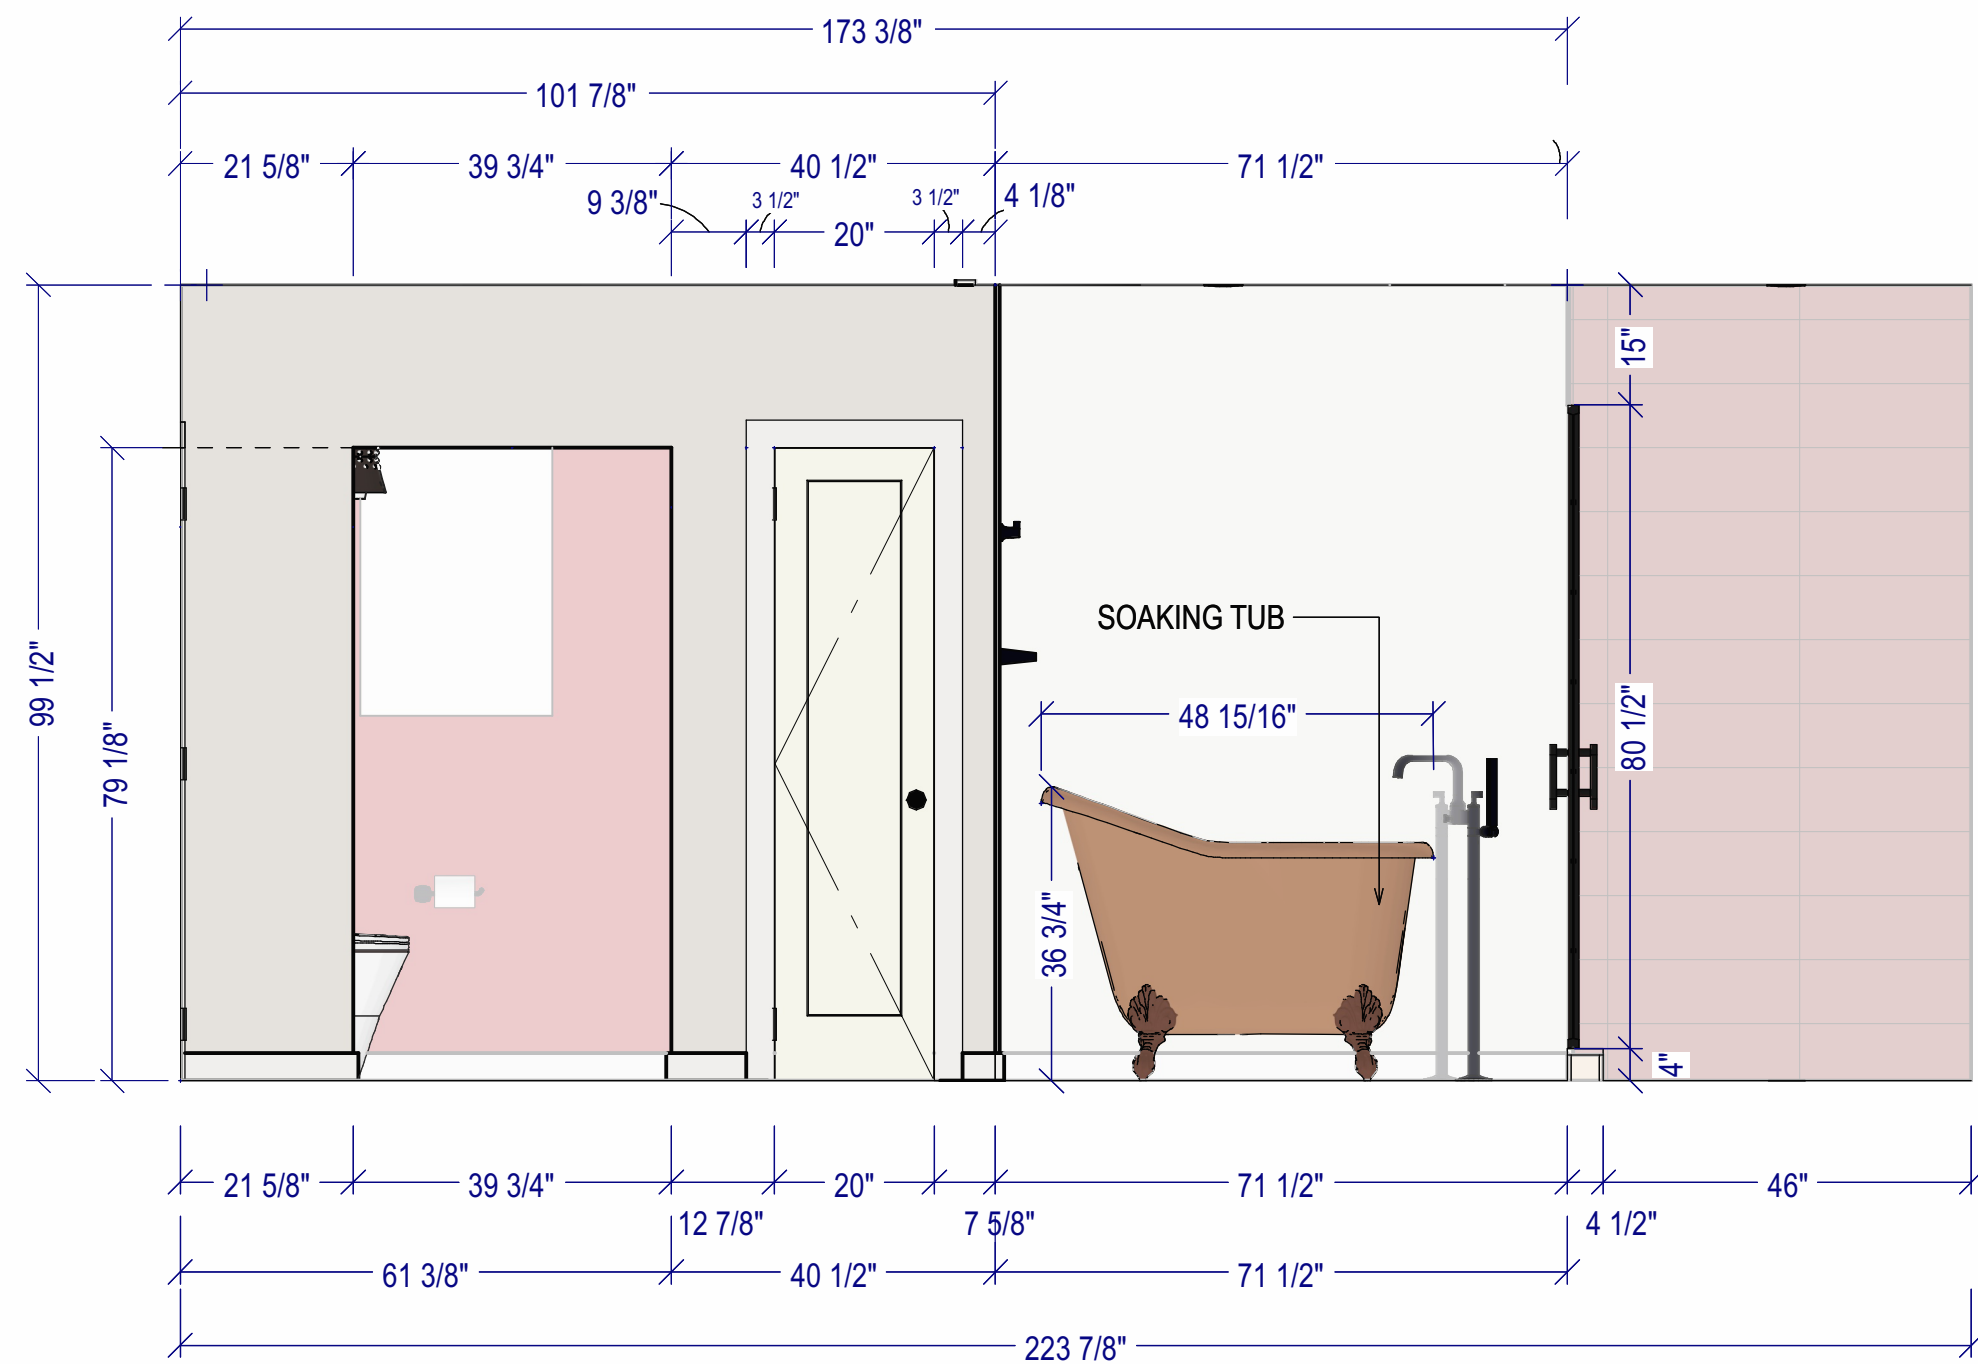


WALL ELEVATION-3
SCALE TO 1/2" = 1' ON ARCH D

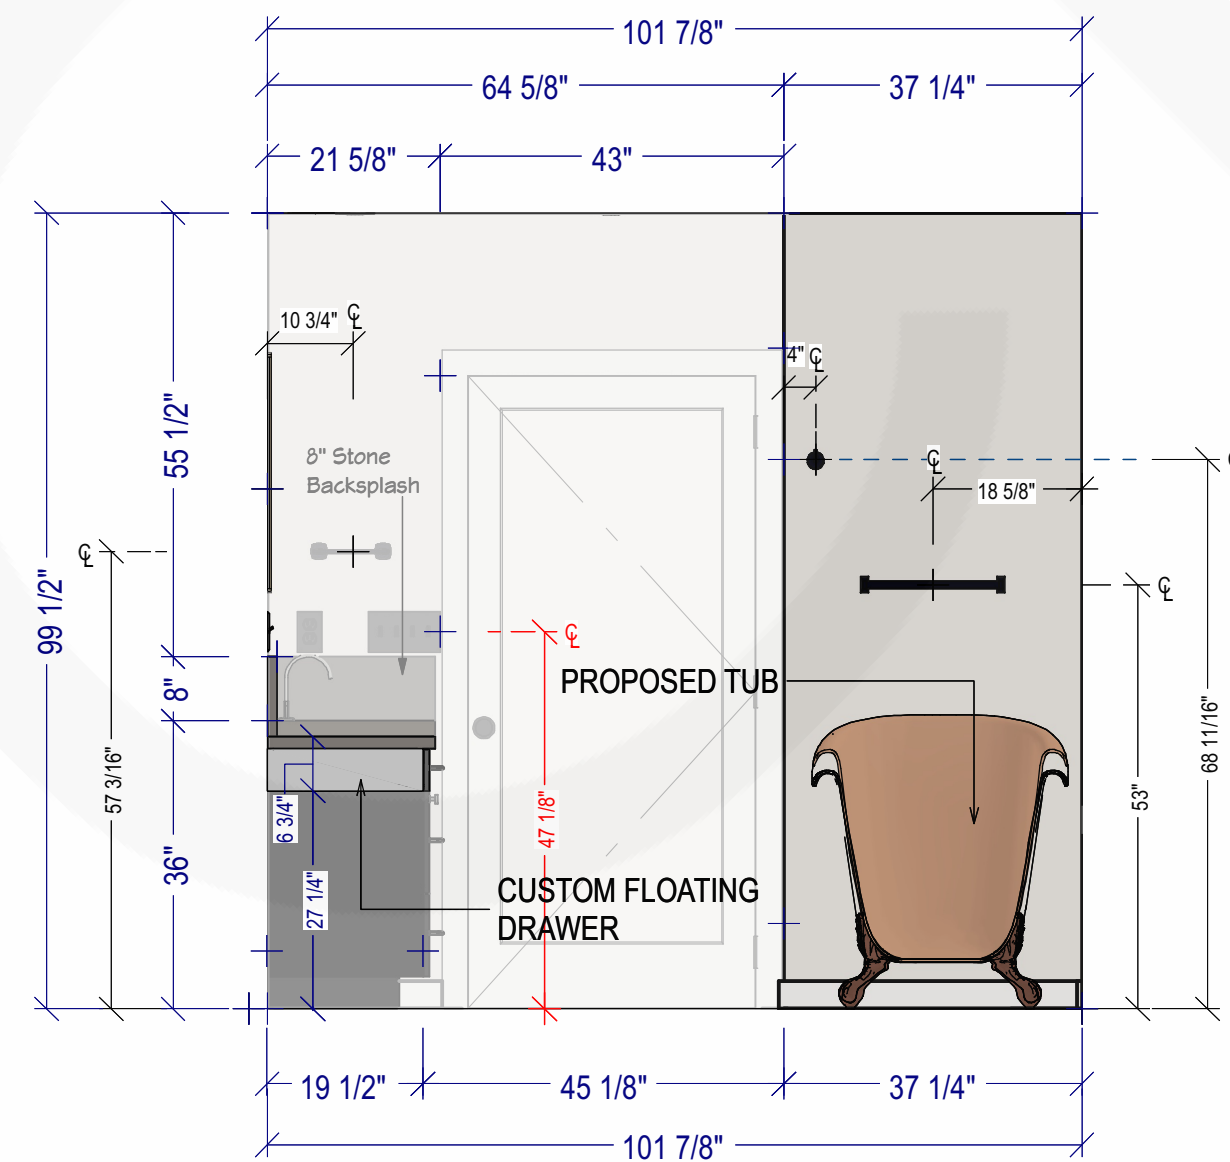

 
WALL ELEVATION-4
SCALE TO 1/2" = 1' ON ARCH D




REVISION TABLE			
NUMBER	DATE	REVISED BY	DESCRIPTION

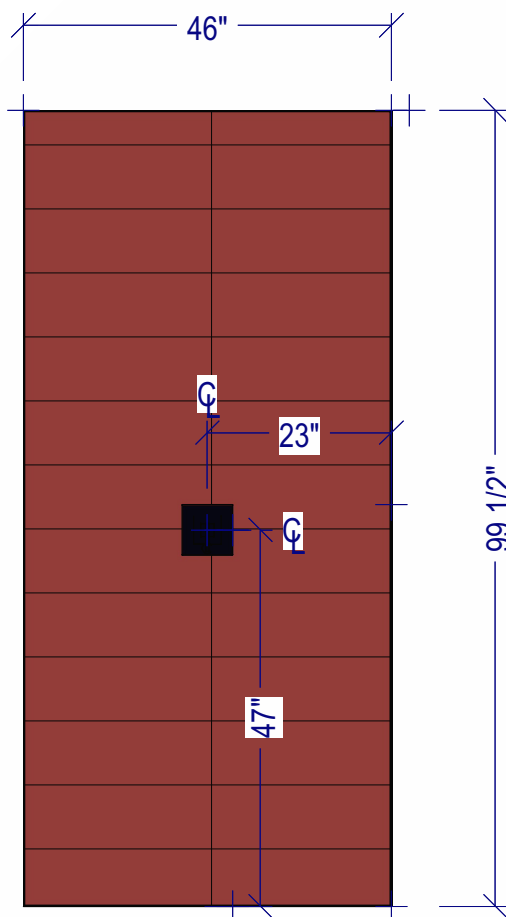


WALL ELEVATION-5
SCALE TO 1/2" = 1' ON ARCH D

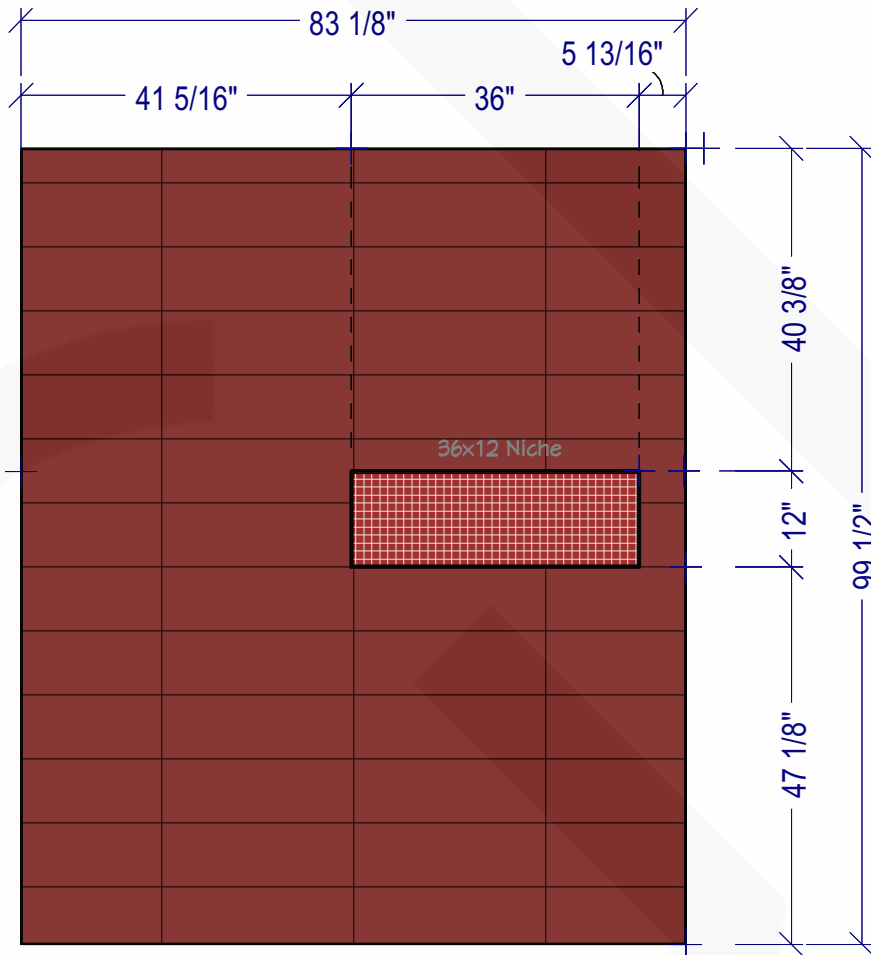


WALL ELEVATION-6
SCALE TO 1/2" = 1' ON ARCH D

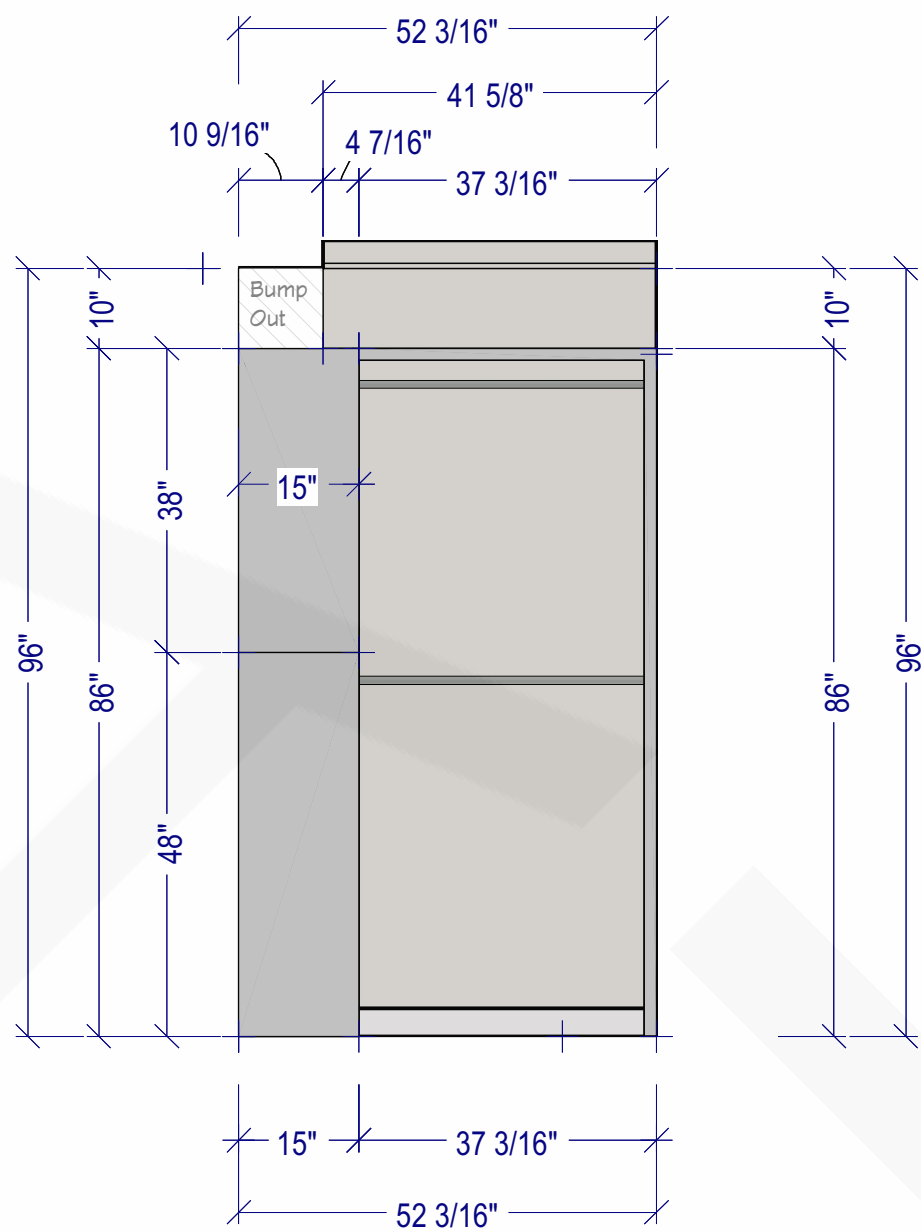


WALL ELEVATION-7
SCALE TO 1/2" = 1' ON ARCH D

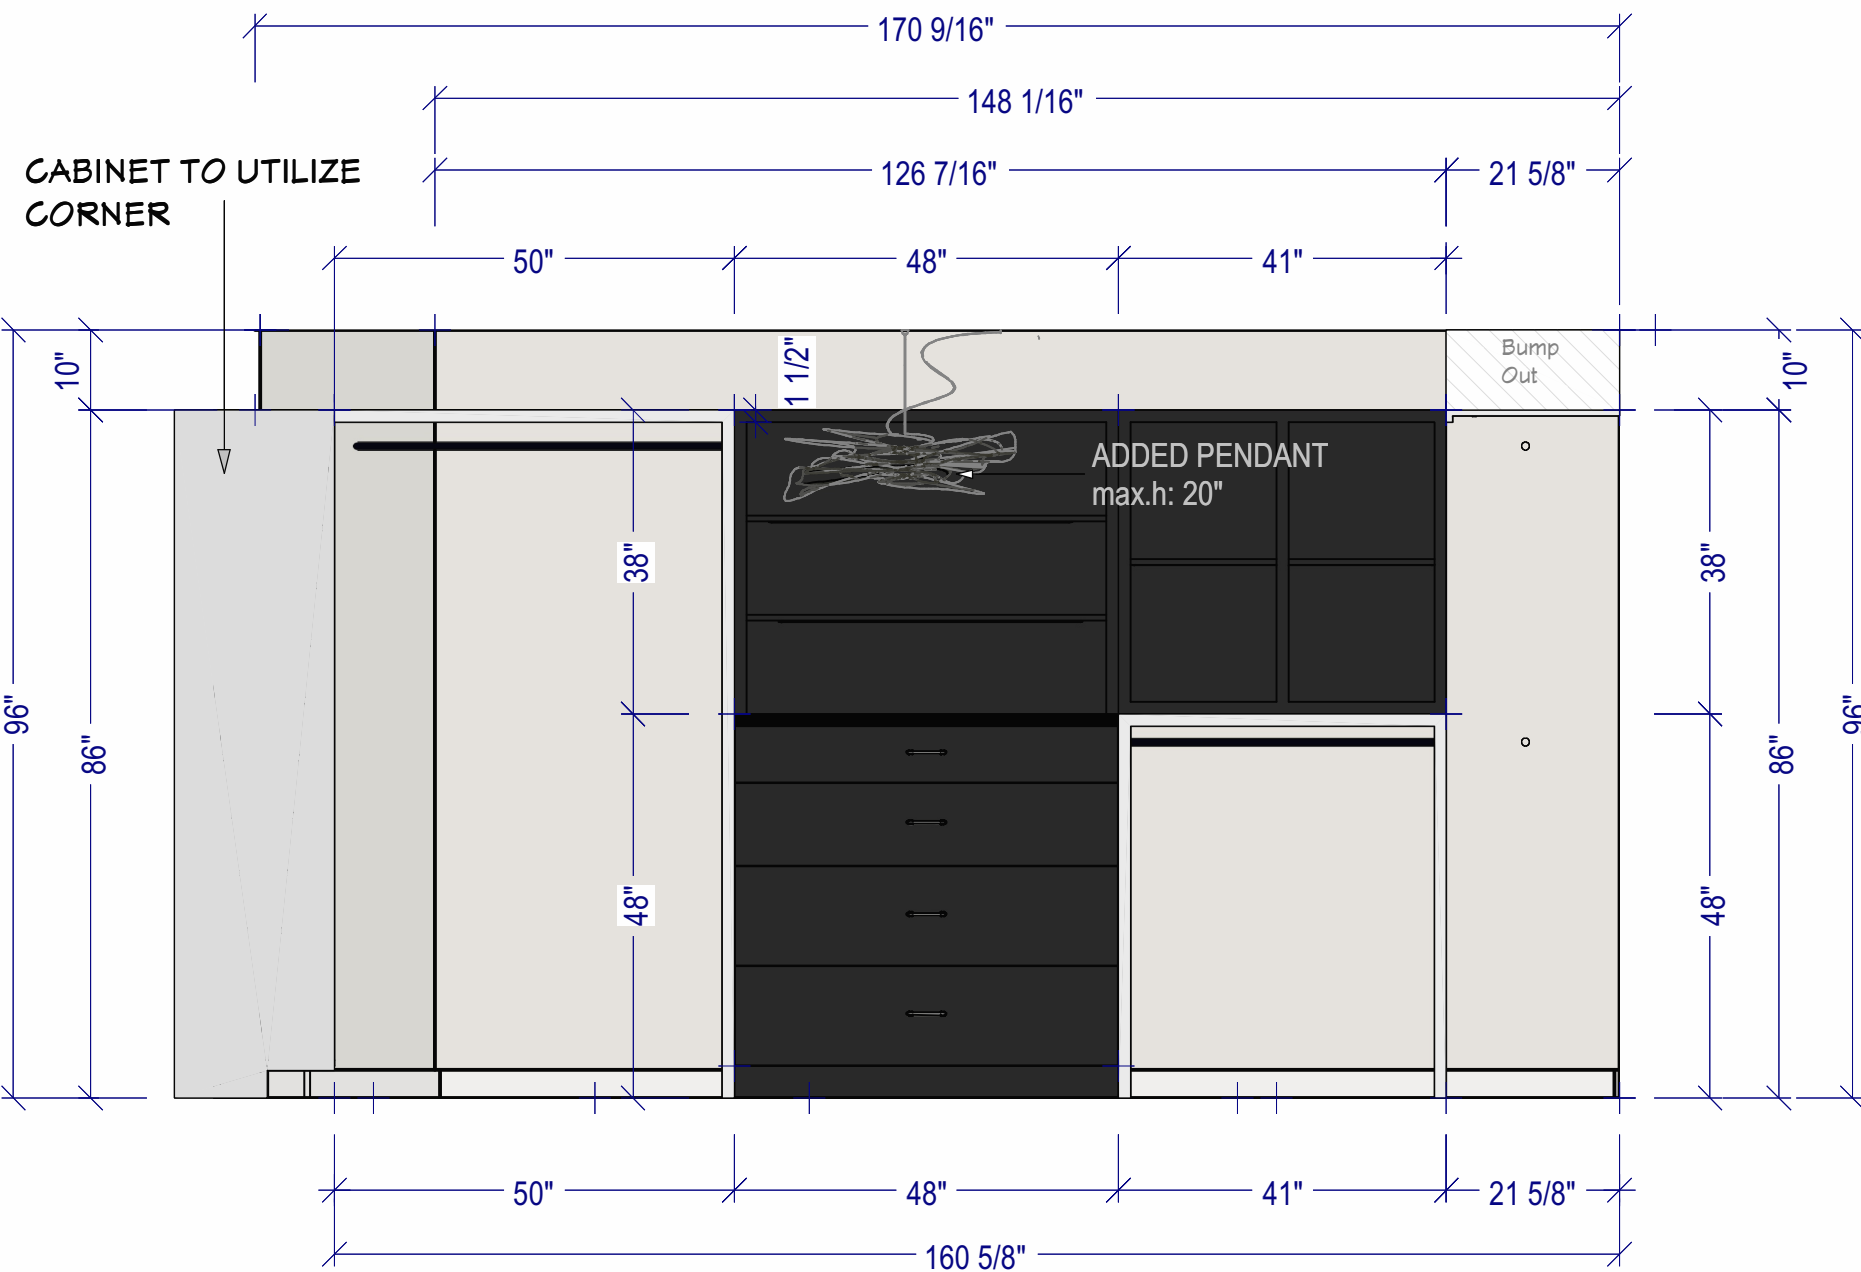

WALL ELEVATION-8
SCALE TO 1/2" = 1' ON ARCH D

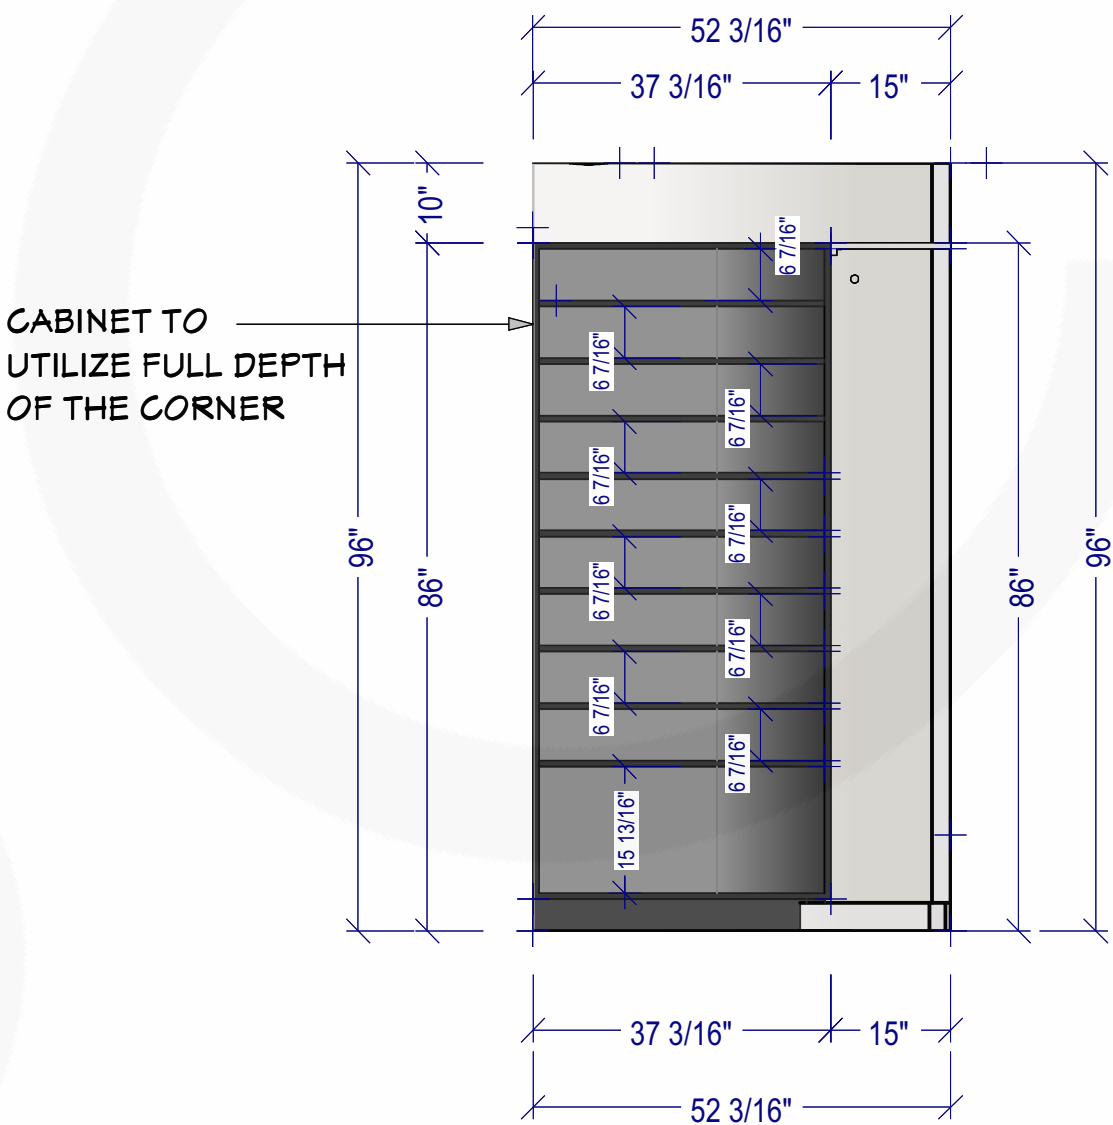

 WALL ELEVATION-9
SCALE TO 1/2" = 1' ON ARCH D



Bathroom Floor Tiles:
Arctic White Brushed Large Herringbone
Marble Mosaic Wall and Floor Tile



Vent Covers: (x2)
FITTES Flush Mounted Vent Covers
(w/ Panasonic Exhausts)




Vanity Stools: (x2)
Sam Klemik Quilted Stool




Pendant:
SLAMP - La Belle Etoile
Ceiling-wall - Black Light -
By Adriano Rachele



Drawer Pulls:
Brizo Allaria 4 Inch
Center to Center Bar Cabinet Pull

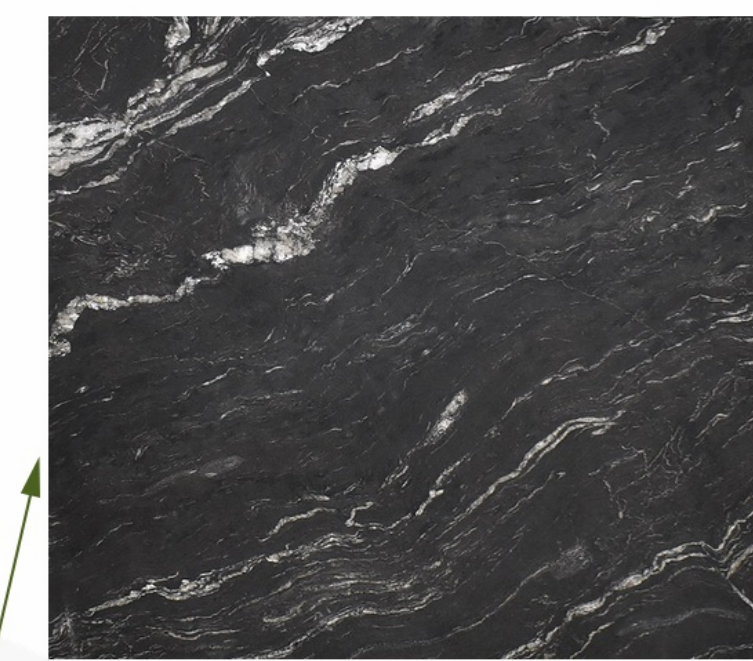


Countertop and Backsplash Stone:
3cm Titanium Leathered Granite

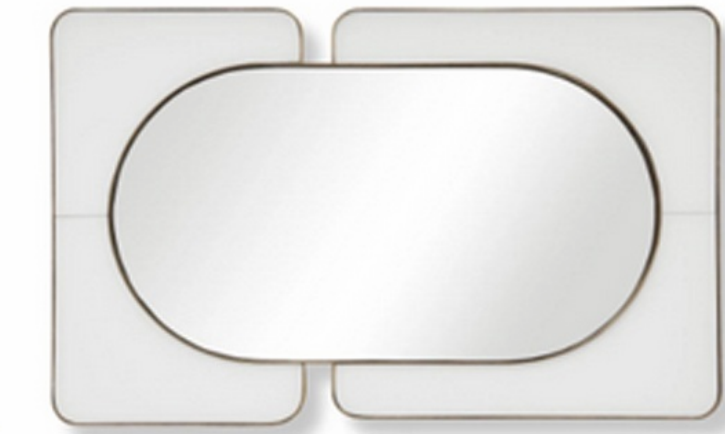


Integrated Vanity Sinks:
3cm Titanium Leathered Granite

Vanity Mirrors(x2):
Embrace Mirror — Craft w/ Built-in LED Lights

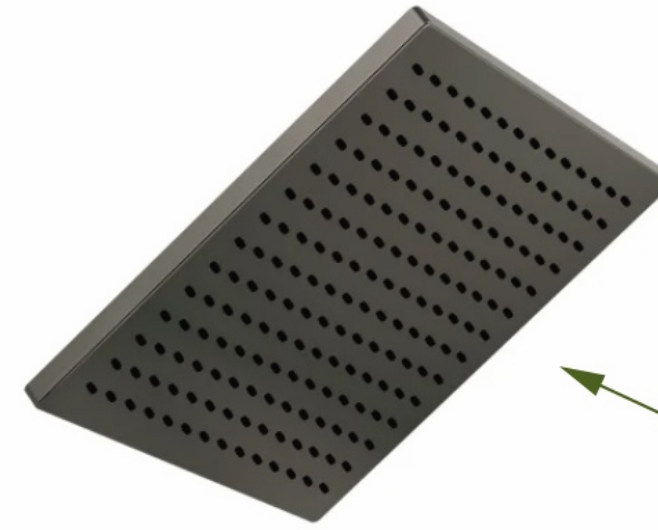

Shower Head:
Brizo Essential 2.5 GPM 12" Single Function
Square Metal Raincan Shower Head

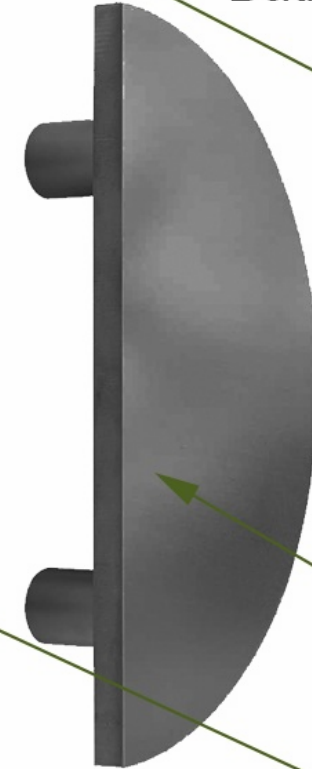


Lavatory:
Brizo Allaria

Shower Head:
Essential 2.5 GPM 12" Single Function
Square Metal Raincan Shower Head


Shower Door Handle:
First Impressions, Cascade Door Pull Handle, Solid C-Shaped
in Matte Black



Red Grout for Shower Tiles

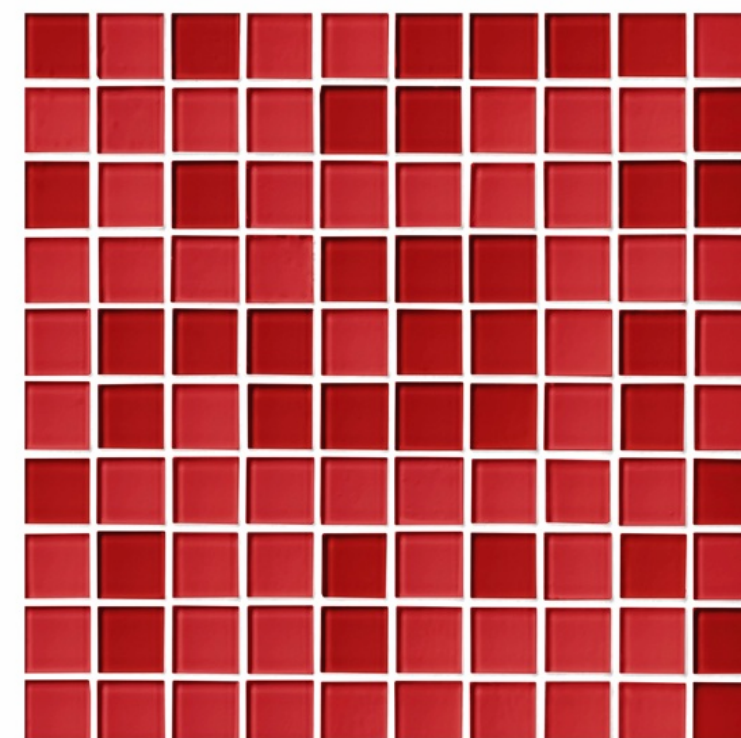

Shower Floor and Wall Niche Tiles:
Glass Red Blend Mosaic Wall Tile - 1 in.

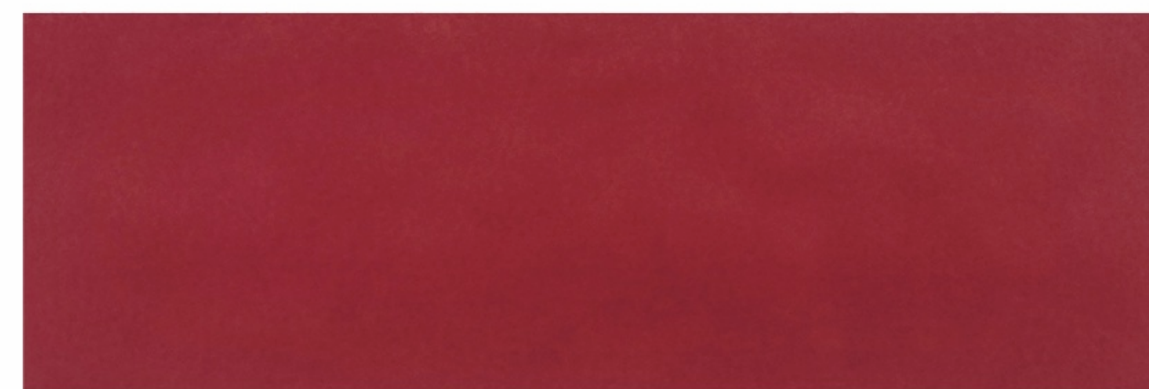

Shower Wall Tiles:
Maiolica Red Lux Ceramic Wall Tile - 8 x 24 in.



Tub Filler:
Brizo T70368-BNX Allaria Two Handle Tub Filler
Trim Kit with Hand Shower and Lever Handles



Soaking Tub:
Signature Hardware, 49" Abbey Hammered Copper
Slipper Clawfoot Soaking Tub-Antique Copper



Robe Hook
Brizo 693467-BNX Allaria Single




Tissue Holder
Brizo Allaria Wall Mounted Euro
Toilet Paper Holder Brilliance Black Onyx



Pendant:
MauriAlmari K2-7



Towel Bars(x2):
Brizo Allaria 8" Towel Bar

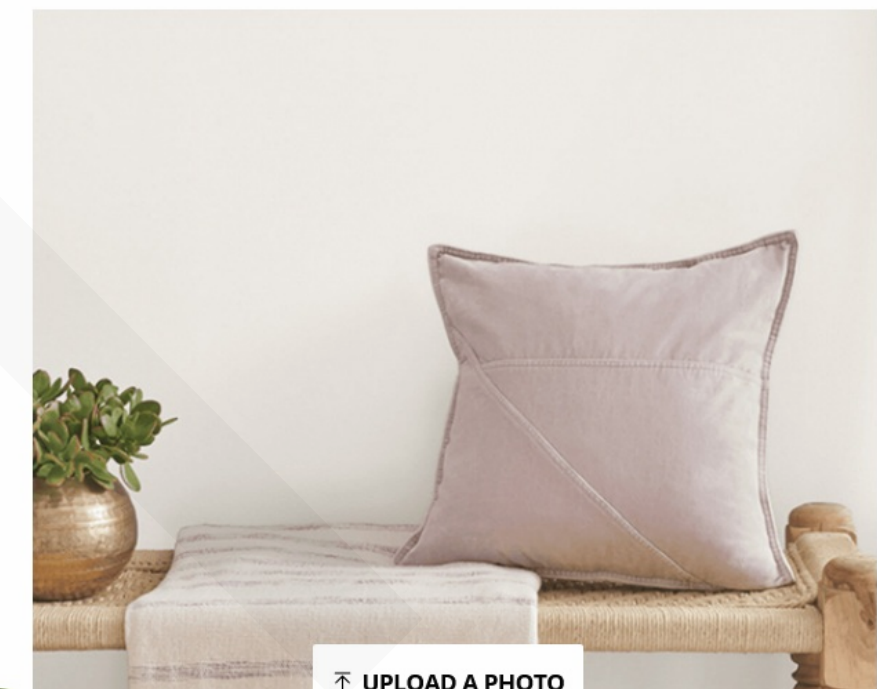

Bathroom Wall Color:
Sherwin Williams Snowbound SW 7004 | White



Toilet Wall Color:
Sherwin Williams Real Red SW 6868



~~WC:
TOTO Nexus 1.28 GPF One Piece
Elongated Chair Height Toilet~~



SHEET # 6	DRAWINGS BY: Oz G.	DATE: 2025.7.28	PROJECT DESCRIPTION Bathroom & Walk-In Closet Remodel – Bennett Residence	SHEET TITLE Design Specifications	SCALE 	PAGE SIZE ARCH D	REVISION TABLE				COPYRIGHT All rights reserved. These drawings, plans and specifications and the copyright are the property of Gir.Arch © and must not be used, reproduced or copied wholly or in part without the written permission of Gir.Arch ©	GIR.A RCH
							NUMBER	DATE	REVISED BY	DESCRIPTION		



SHEET #	DRAWINGS BY:	DATE:
7	Oz G.	2025.7.28

PROJECT DESCRIPTION
Bathroom & Walk-In Closet Remodel – Bennett Residence

SHEET TITLE	SCALE	PAGE SIZE
Rendering (1 of 7)		ARCH D

REVISION TABLE			
NUMBER	DATE	REVISED BY	DESCRIPTION

COPYRIGHT
All rights reserved. These drawings, plans and specifications and the copyright are the property of Gir.Arch © and must not be used, reproduced or copied wholly or in part without the written permission of Gir.Arch ©

GIR A RCH



SHEET #	DRAWINGS BY:	DATE:
8	Oz G.	2025.7.28

PROJECT DESCRIPTION
Bathroom & Walk-In Closet Remodel – Bennett Residence

SHEET TITLE	SCALE	PAGE SIZE
Rendering (2 of 7)		ARCH D

REVISION TABLE			
NUMBER	DATE	REVISED BY	DESCRIPTION

COPYRIGHT
All rights reserved. These drawings, plans and specifications and the copyright are the property of Gir.Arch © and must not be used, reproduced or copied wholly or in part without the written permission of Gir.Arch ©

GIR A RCH



SHEET #	DRAWINGS BY:	DATE:
9	Oz G.	2025.7.28

PROJECT DESCRIPTION
Bathroom & Walk-In Closet Remodel – Bennett Residence

SHEET TITLE	SCALE	PAGE SIZE
Rendering (3 of 7)		ARCH D

REVISION TABLE			
NUMBER	DATE	REVISED BY	DESCRIPTION

COPYRIGHT
All rights reserved. These drawings, plans and specifications and the copyright are the property of Gir.Arch © and must not be used, reproduced or copied wholly or in part without the written permission of Gir.Arch ©

GIR A RCH



SHEET #	DRAWINGS BY:	DATE:
10	Oz G.	2025.7.28

PROJECT DESCRIPTION
Bathroom & Walk-In Closet Remodel – Bennett Residence

SHEET TITLE	SCALE	PAGE SIZE
Rendering (4 of 7)		ARCH D

REVISION TABLE			
NUMBER	DATE	REVISED BY	DESCRIPTION

COPYRIGHT
All rights reserved. These drawings, plans and specifications and the copyright are the property of Gir.Arch © and must not be used, reproduced or copied wholly or in part without the written permission of Gir.Arch ©

GIR A RCH



SHEET #	DRAWINGS BY:	DATE:
11	Oz G.	2025.7.28

PROJECT DESCRIPTION
Bathroom & Walk-In Closet Remodel – Bennett Residence

SHEET TITLE	SCALE	PAGE SIZE
Rendering (5 of 7)		ARCH D

REVISION TABLE			
NUMBER	DATE	REVISED BY	DESCRIPTION

COPYRIGHT
All rights reserved. These drawings, plans and specifications and the copyright are the property of Gir.Arch © and must not be used, reproduced or copied wholly or in part without the written permission of Gir.Arch ©

GIR A RCH



REVISION TABLE			
NUMBER	DATE	REVISED BY	DESCRIPTION



REVISION TABLE			
NUMBER	DATE	REVISED BY	DESCRIPTION