

# BELL BATHROOM REMODELING PROJECT


## DRAWING INDEX


SHEET NUMBER	TITLE
1	AS-BUILT AND DEMOLITION PLANS
2	PROPOSED DESIGN: FLOOR PLAN
3	PROPOSED DESIGN: REFLECTED CEILING PLAN
4	PROPOSED DESIGN: WALL ELEVATIONS
5	PROJECT SPECIFICATIONS
6-11	RENDERINGS






CH  $\rightarrow 100\frac{3}{8}"$  FROM SUBFLOOR

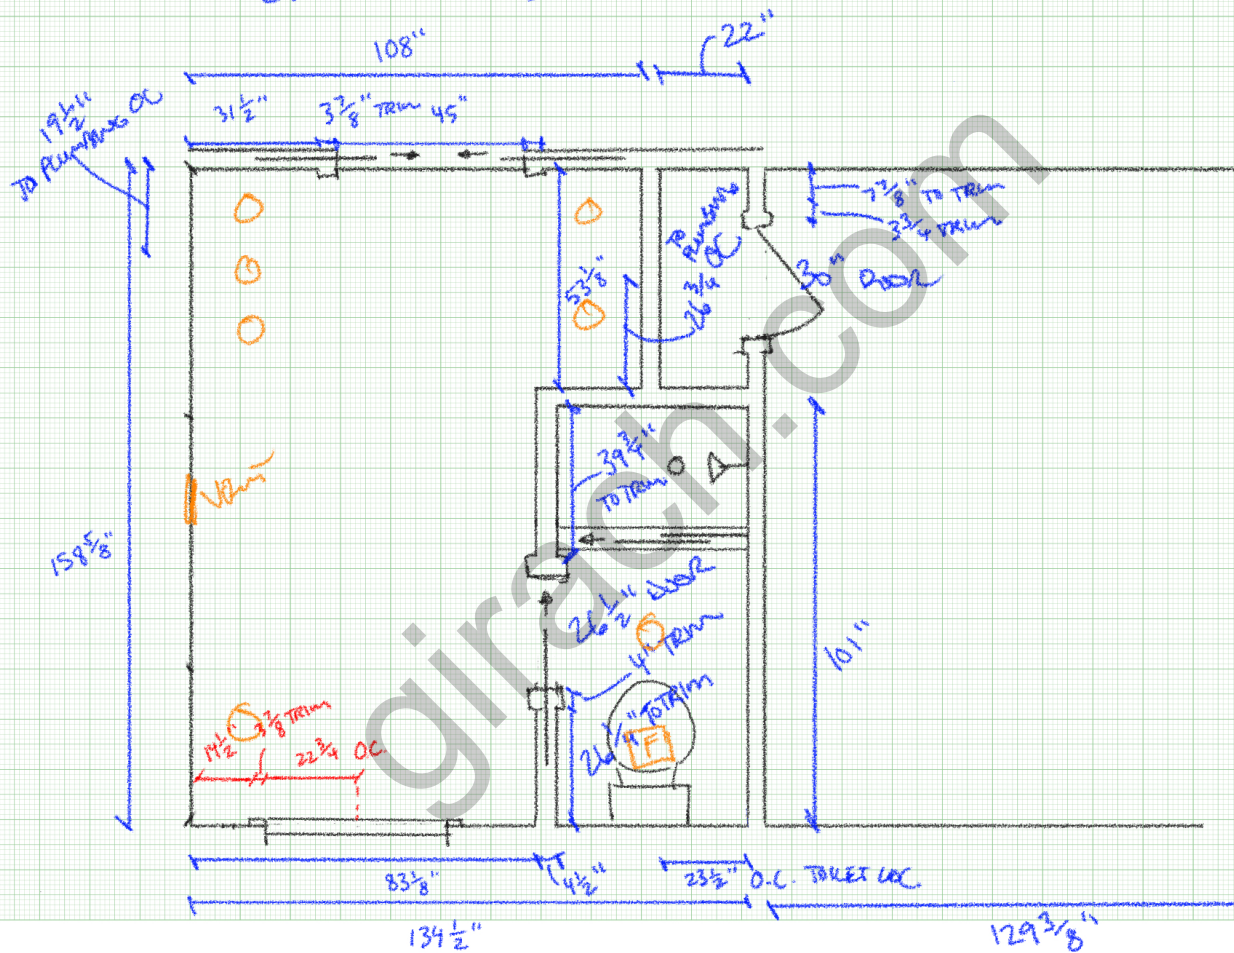

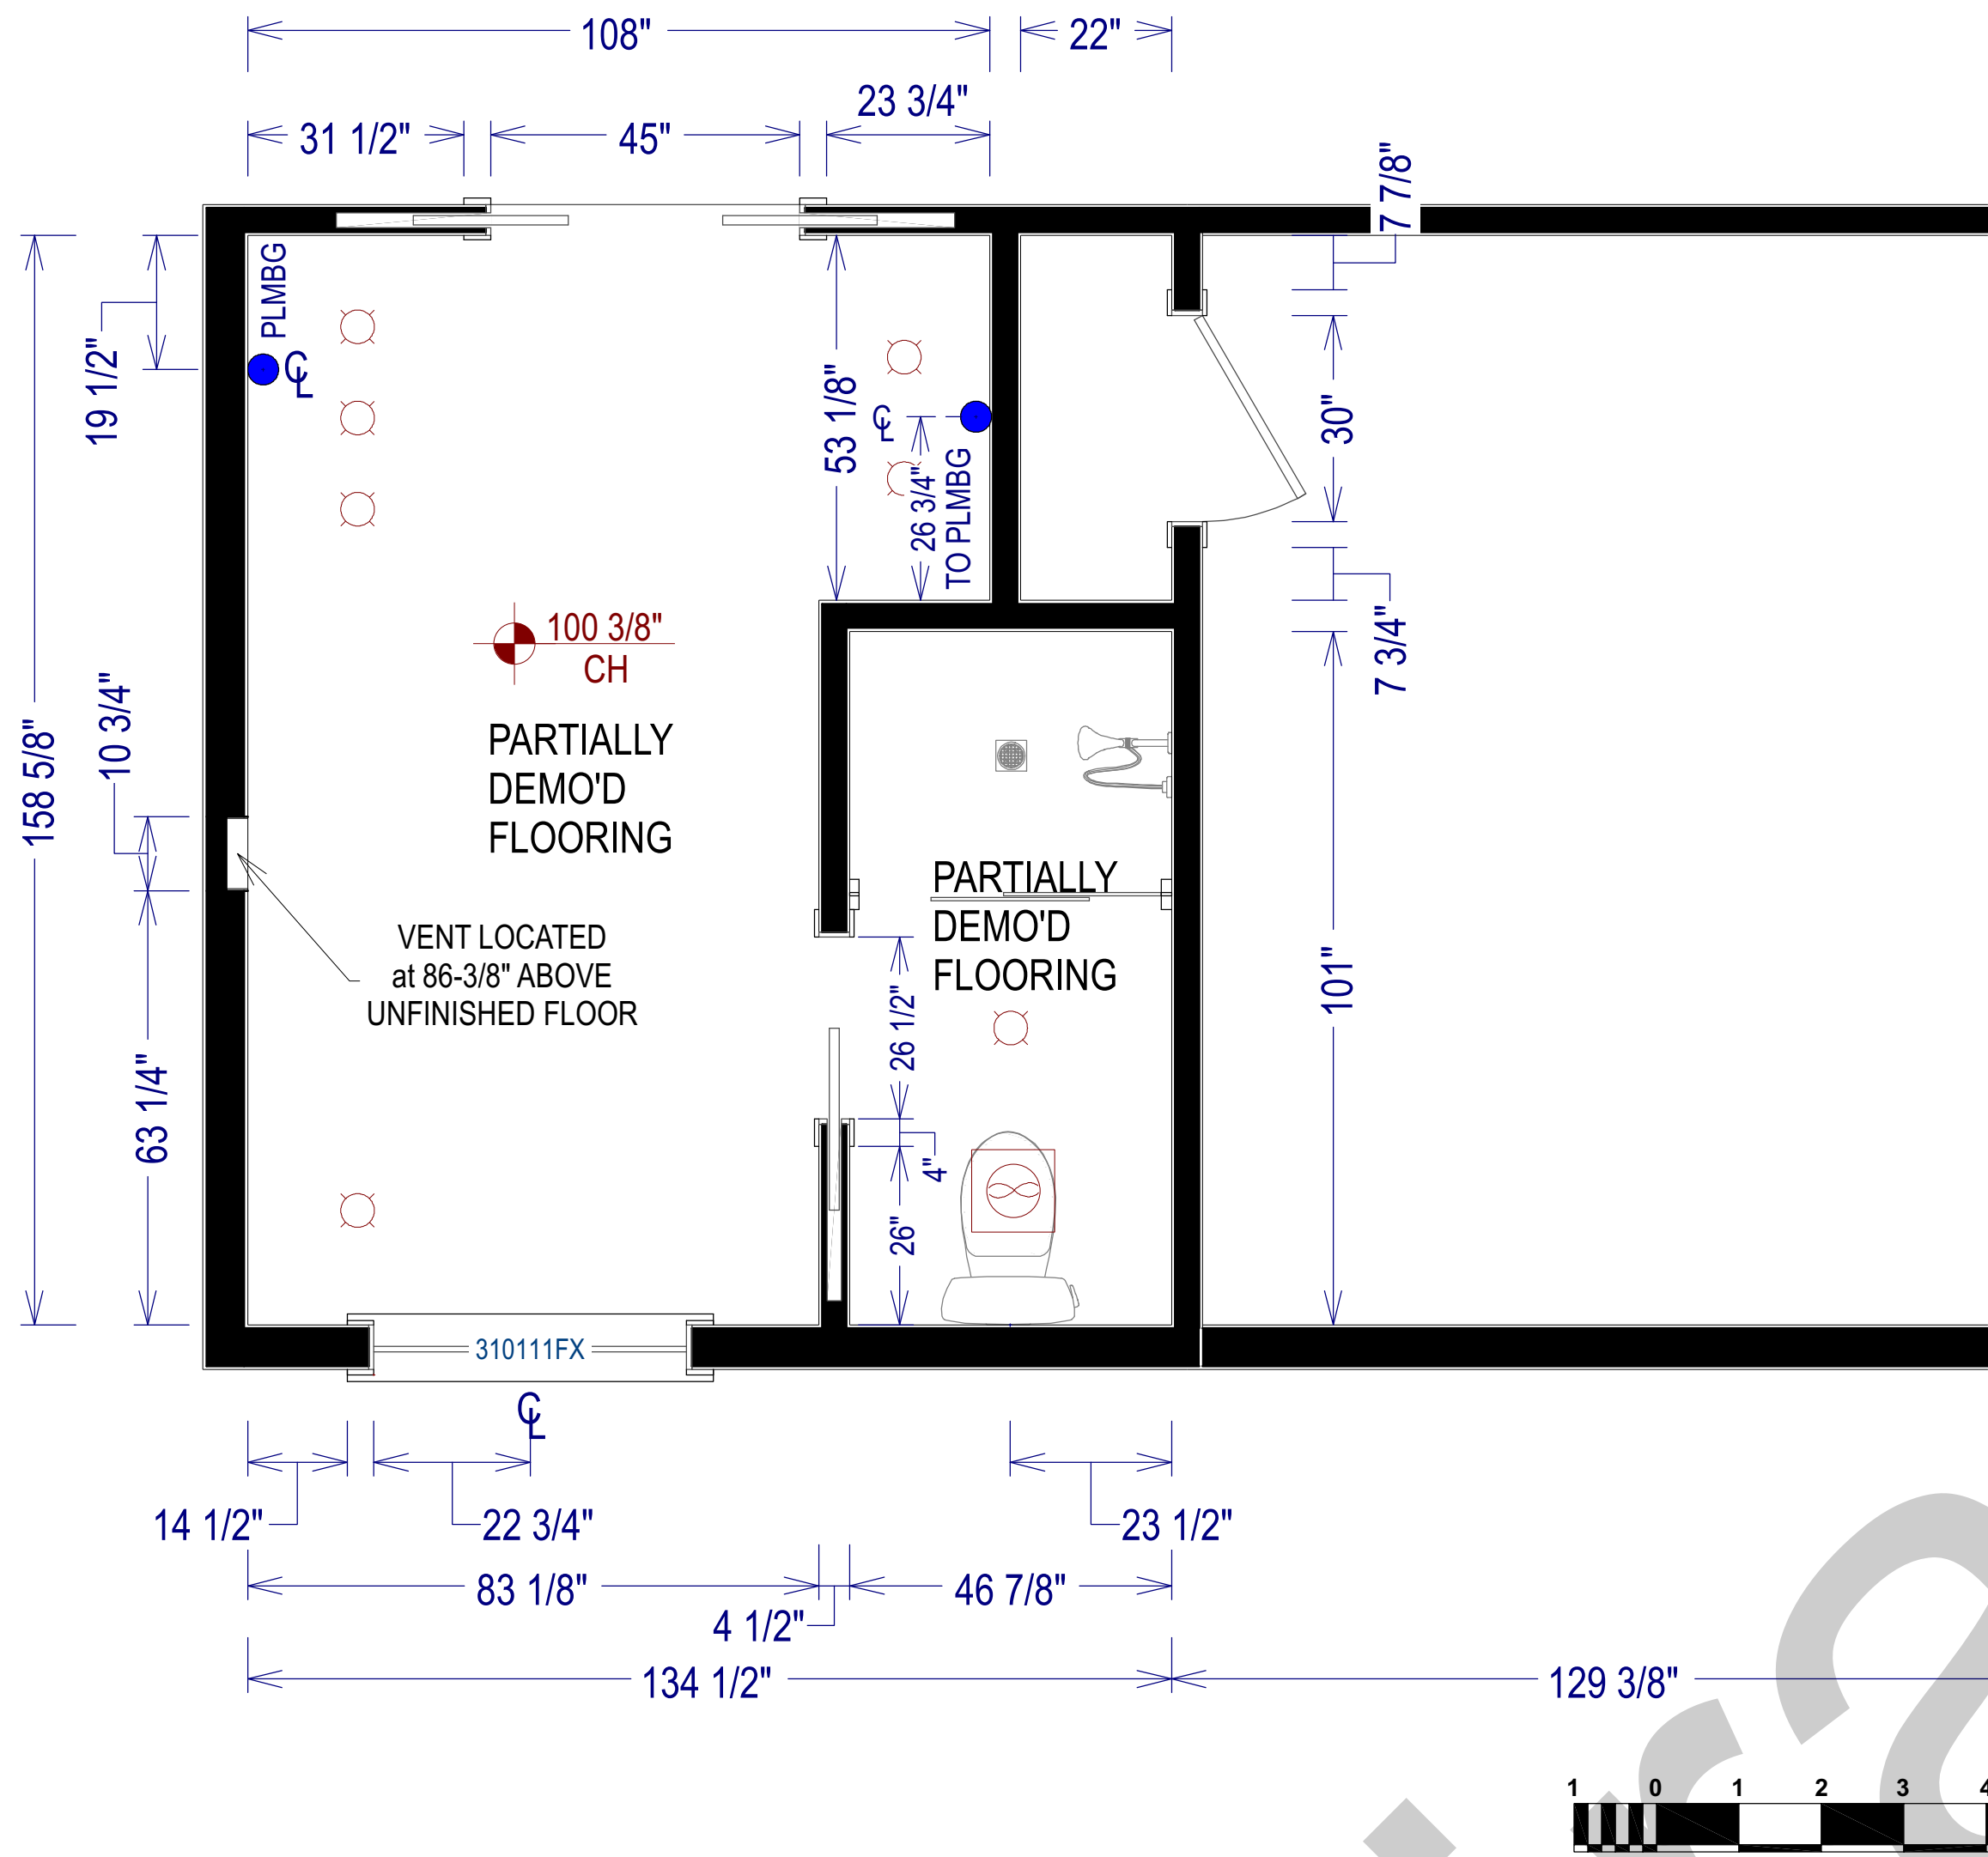



AS-BUILT FLOOR PLAN  
SCALE TO 1/2" = 1' ON ARCH D

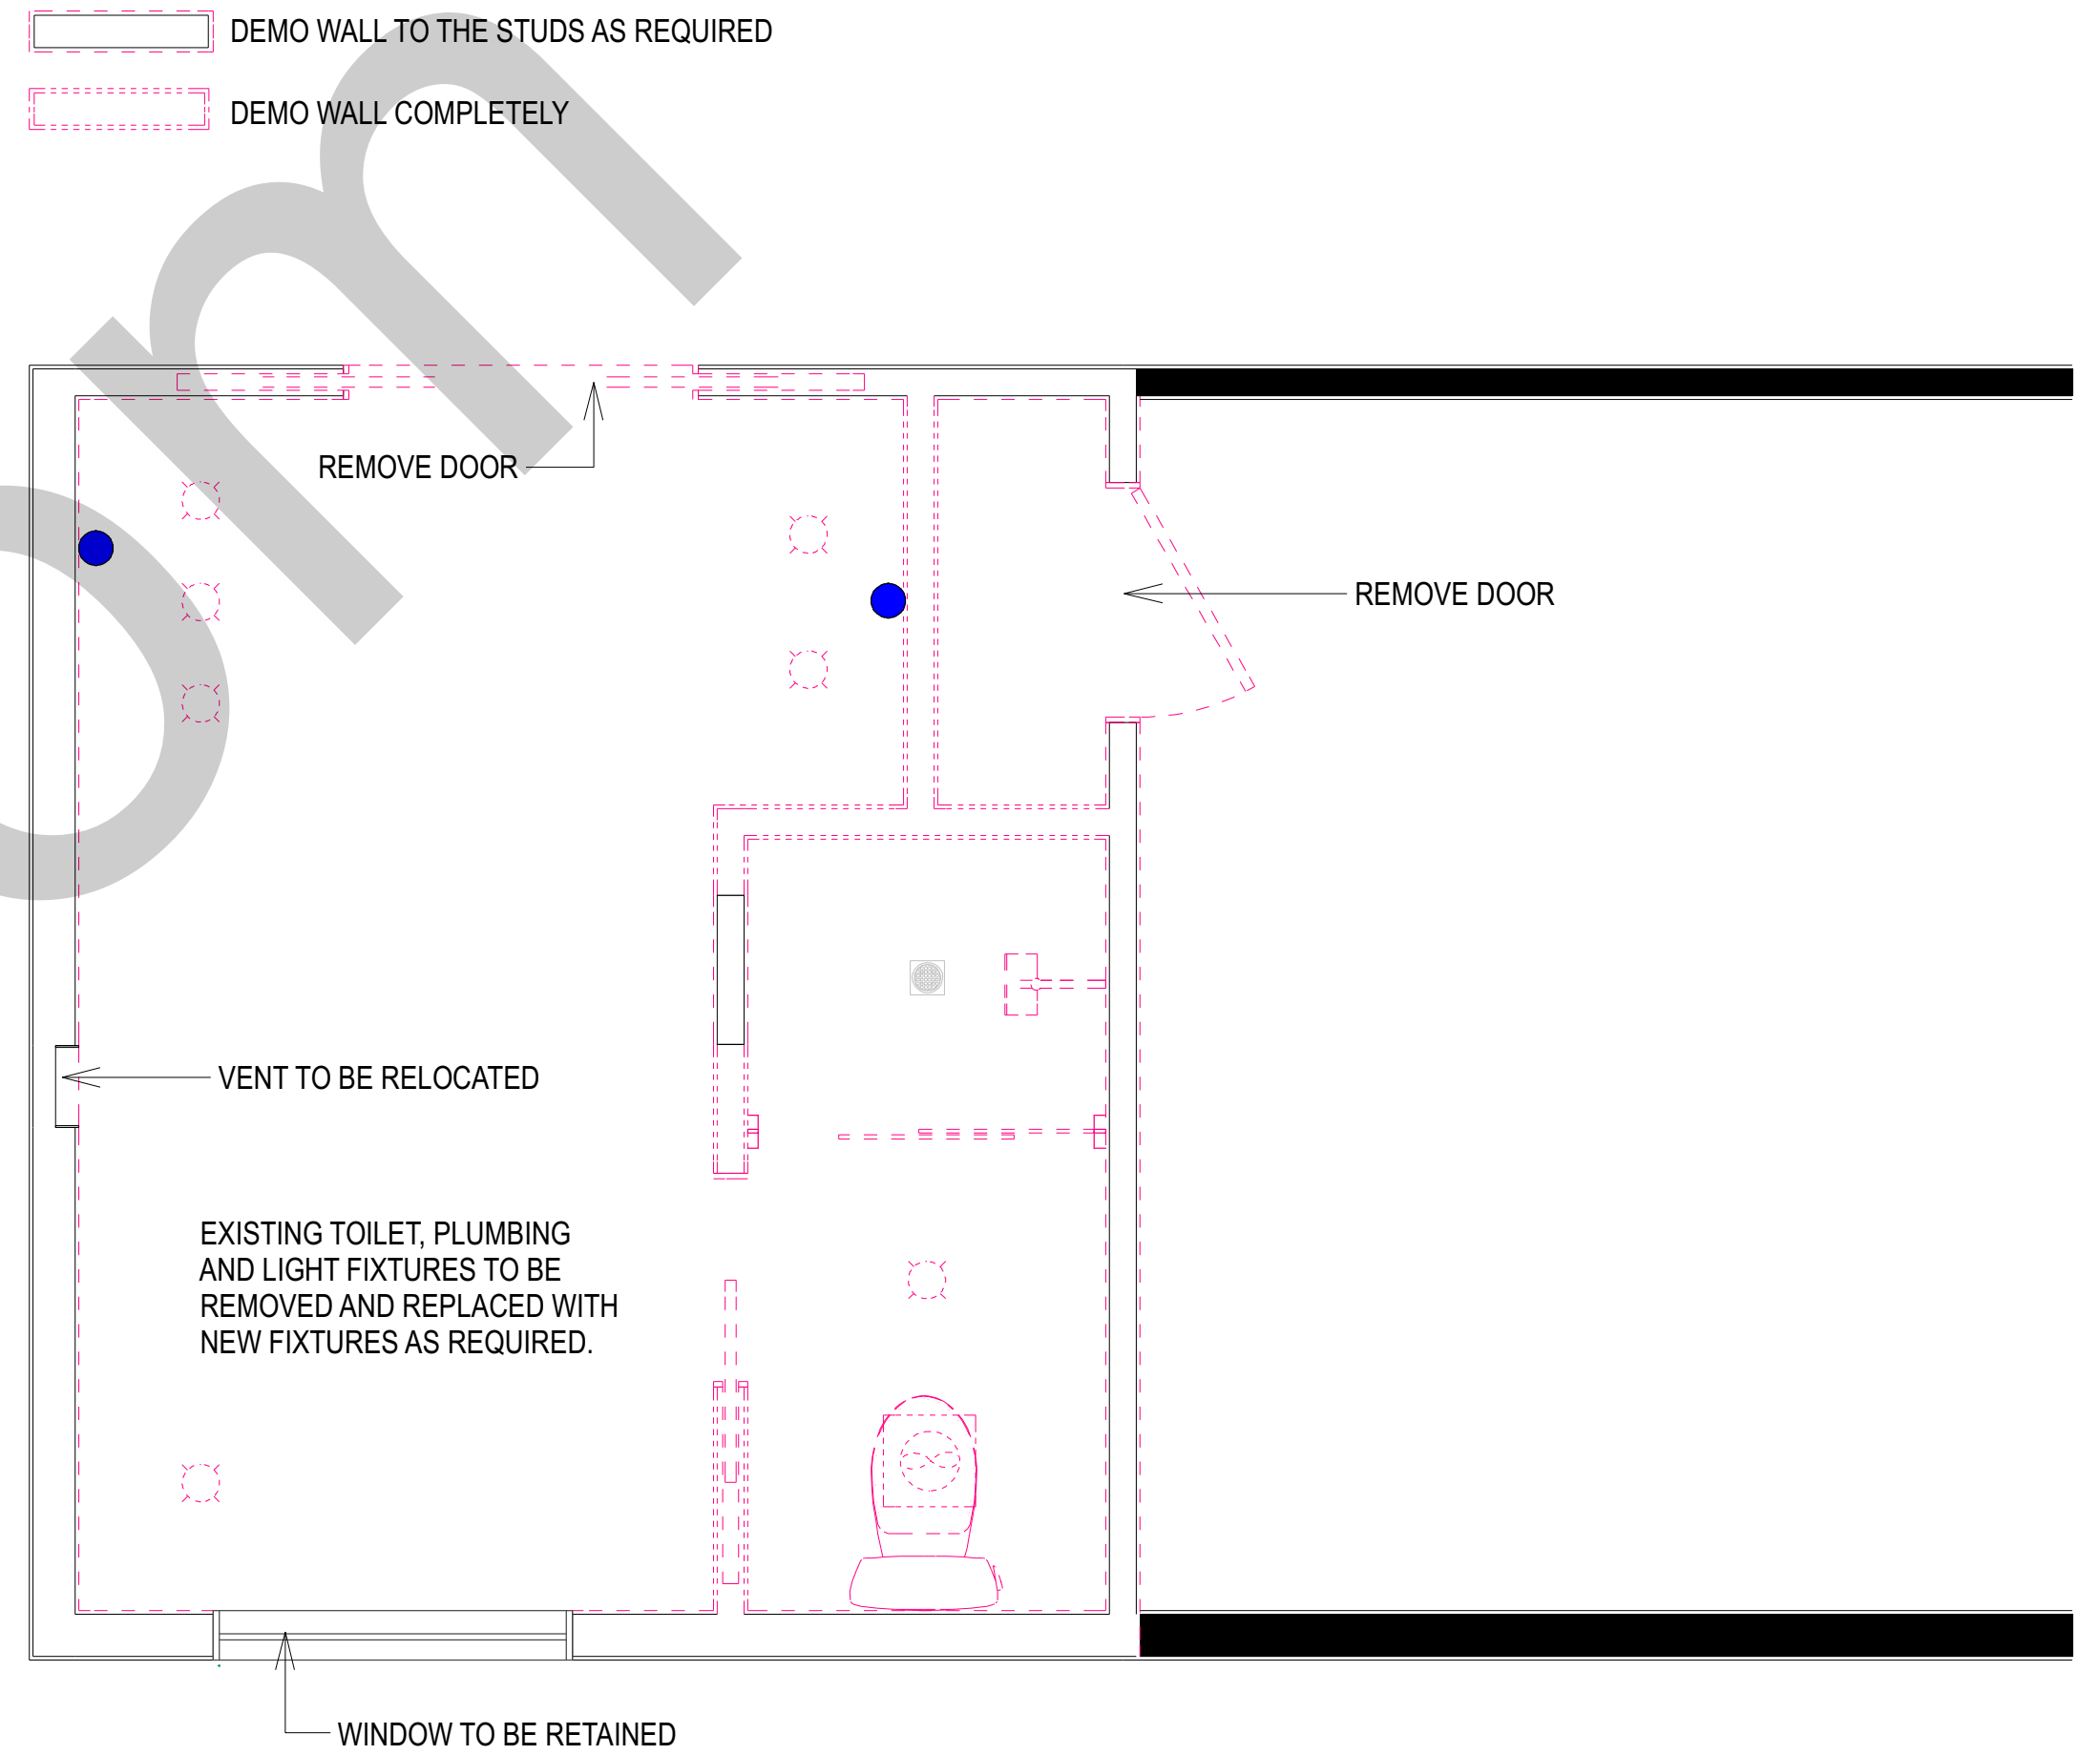

DEMOLITION PLAN  
SCALE TO 1/2" = 1' ON ARCH D



DIMENSIONS ARE TAKEN FROM THE EXISTING WALLS' FINISHES AND THE NEW WALLS' STUDS.

 NEW WALLS

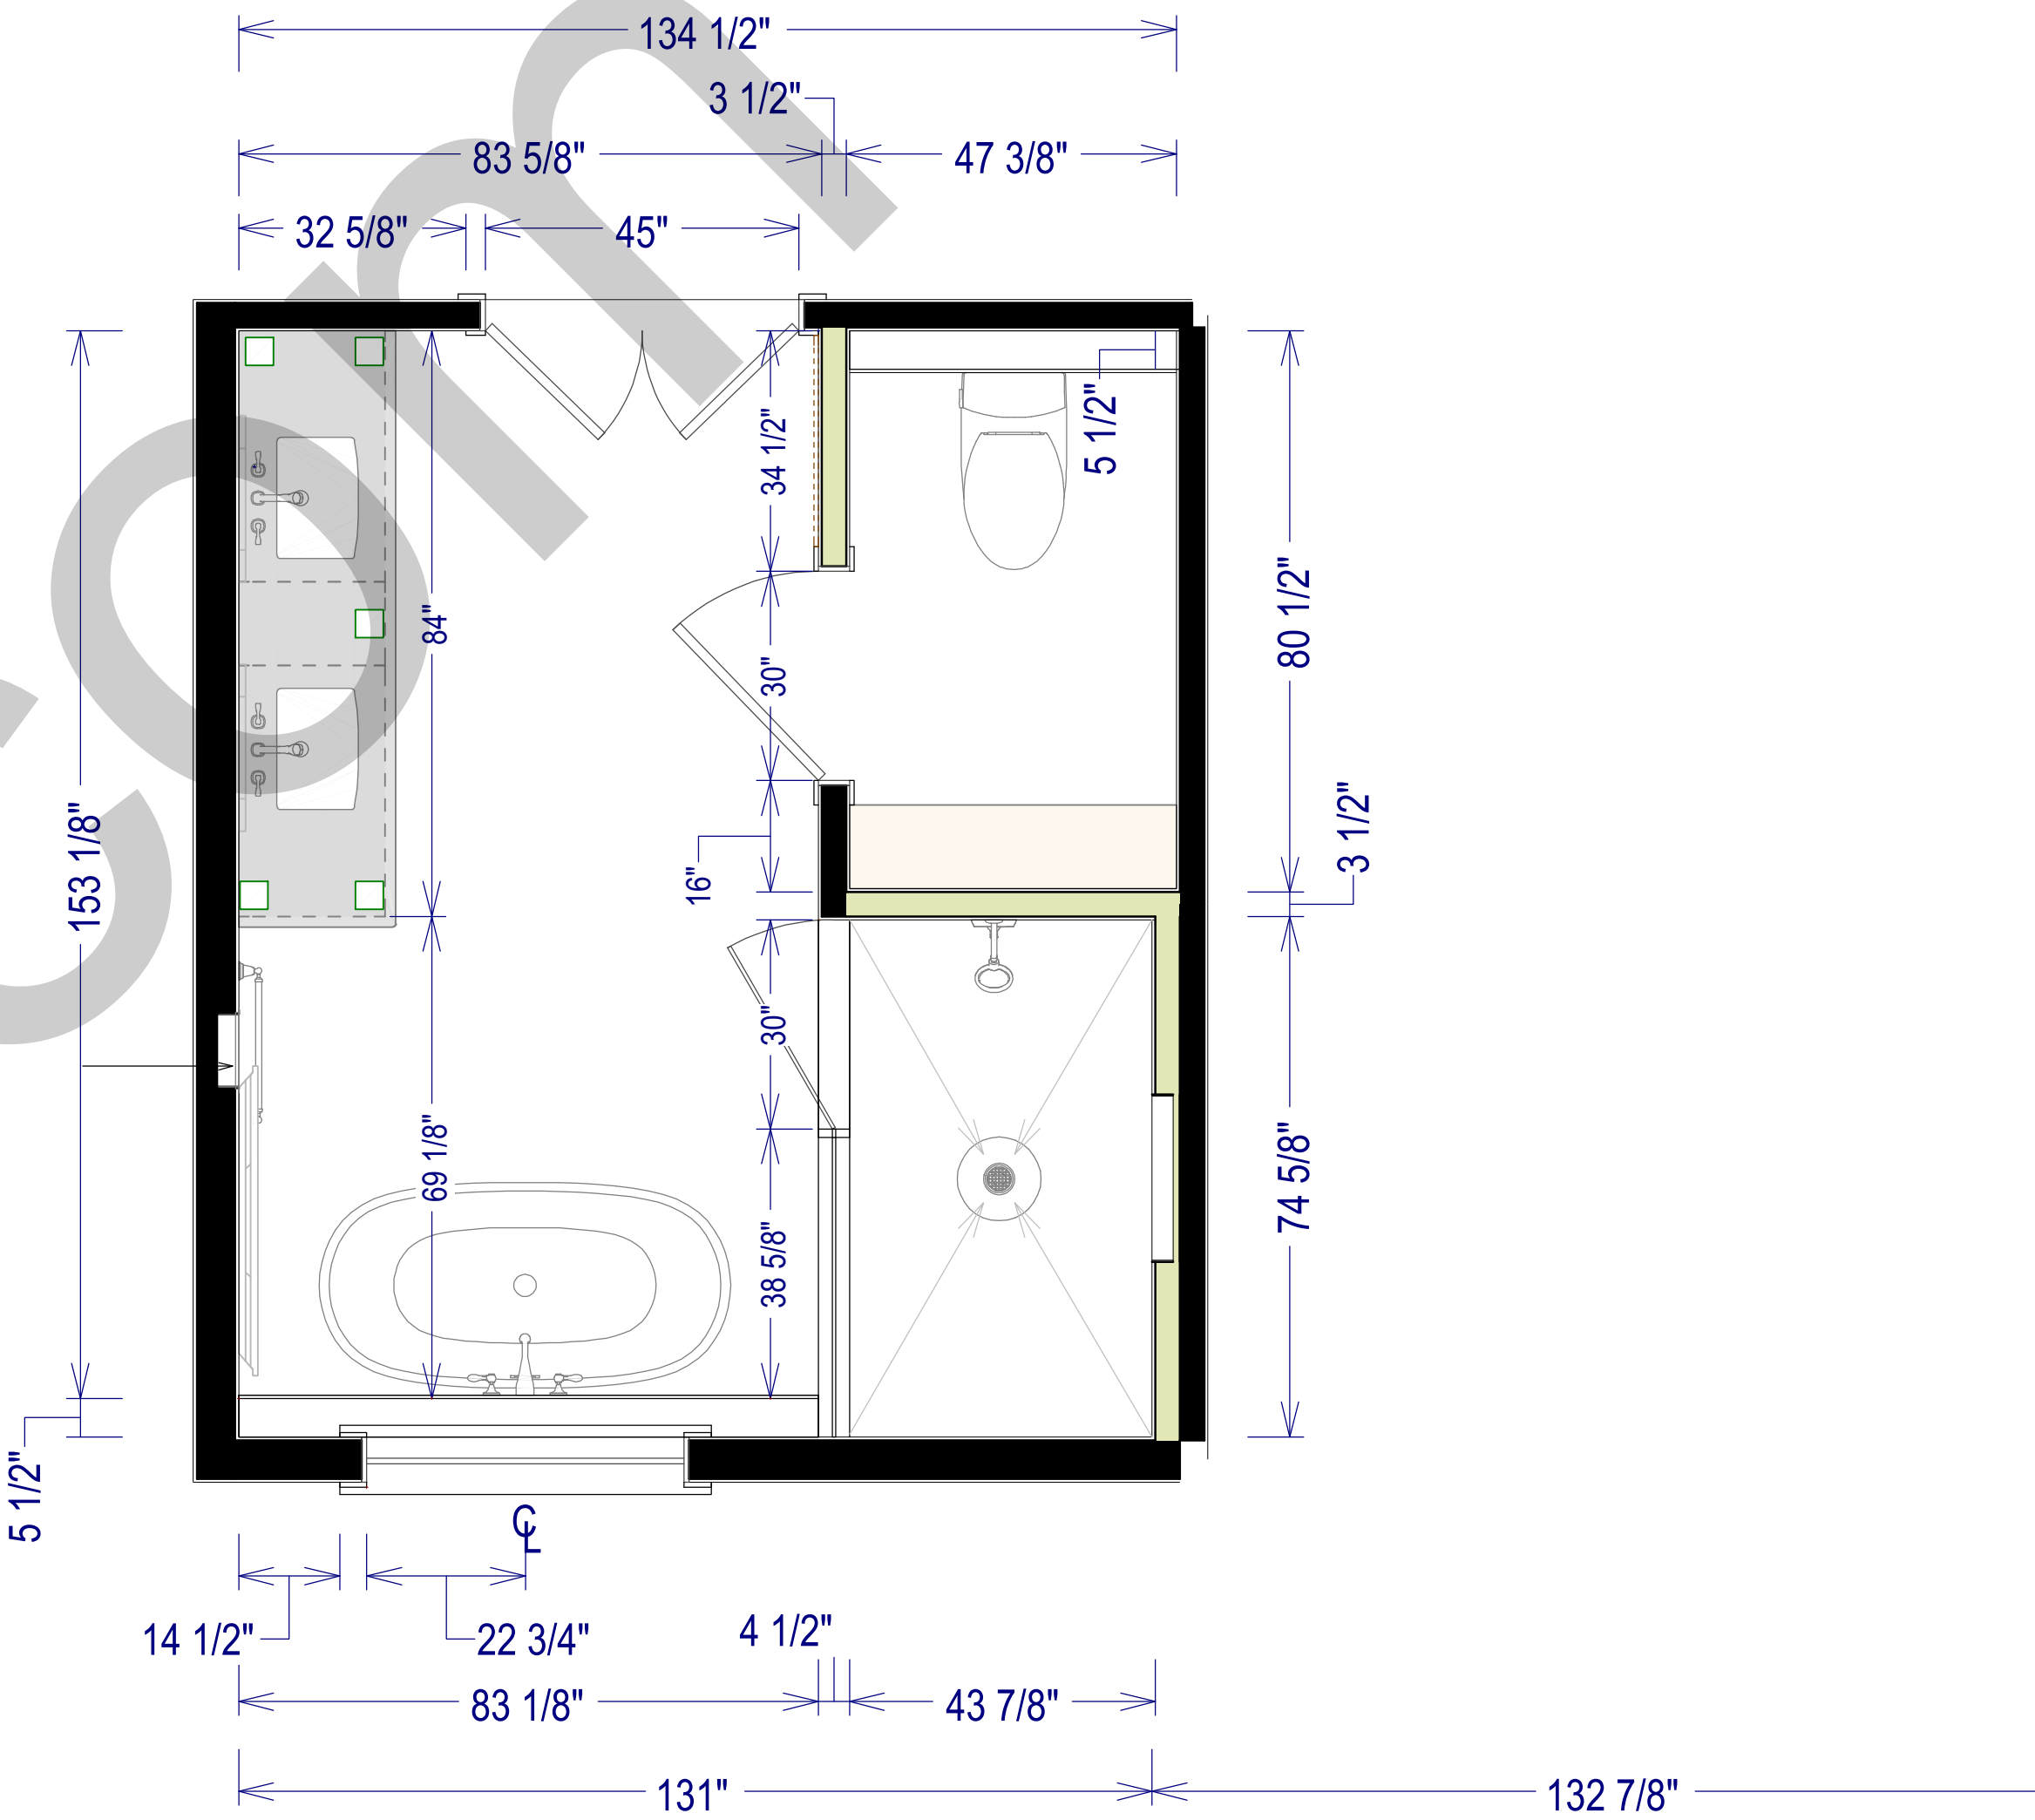


PROPOSED DESIGN, DIMENSIONED FLOOR PLAN  
SCALE TO 1/2" = 1' ON ARCH D

 NEW WALLS

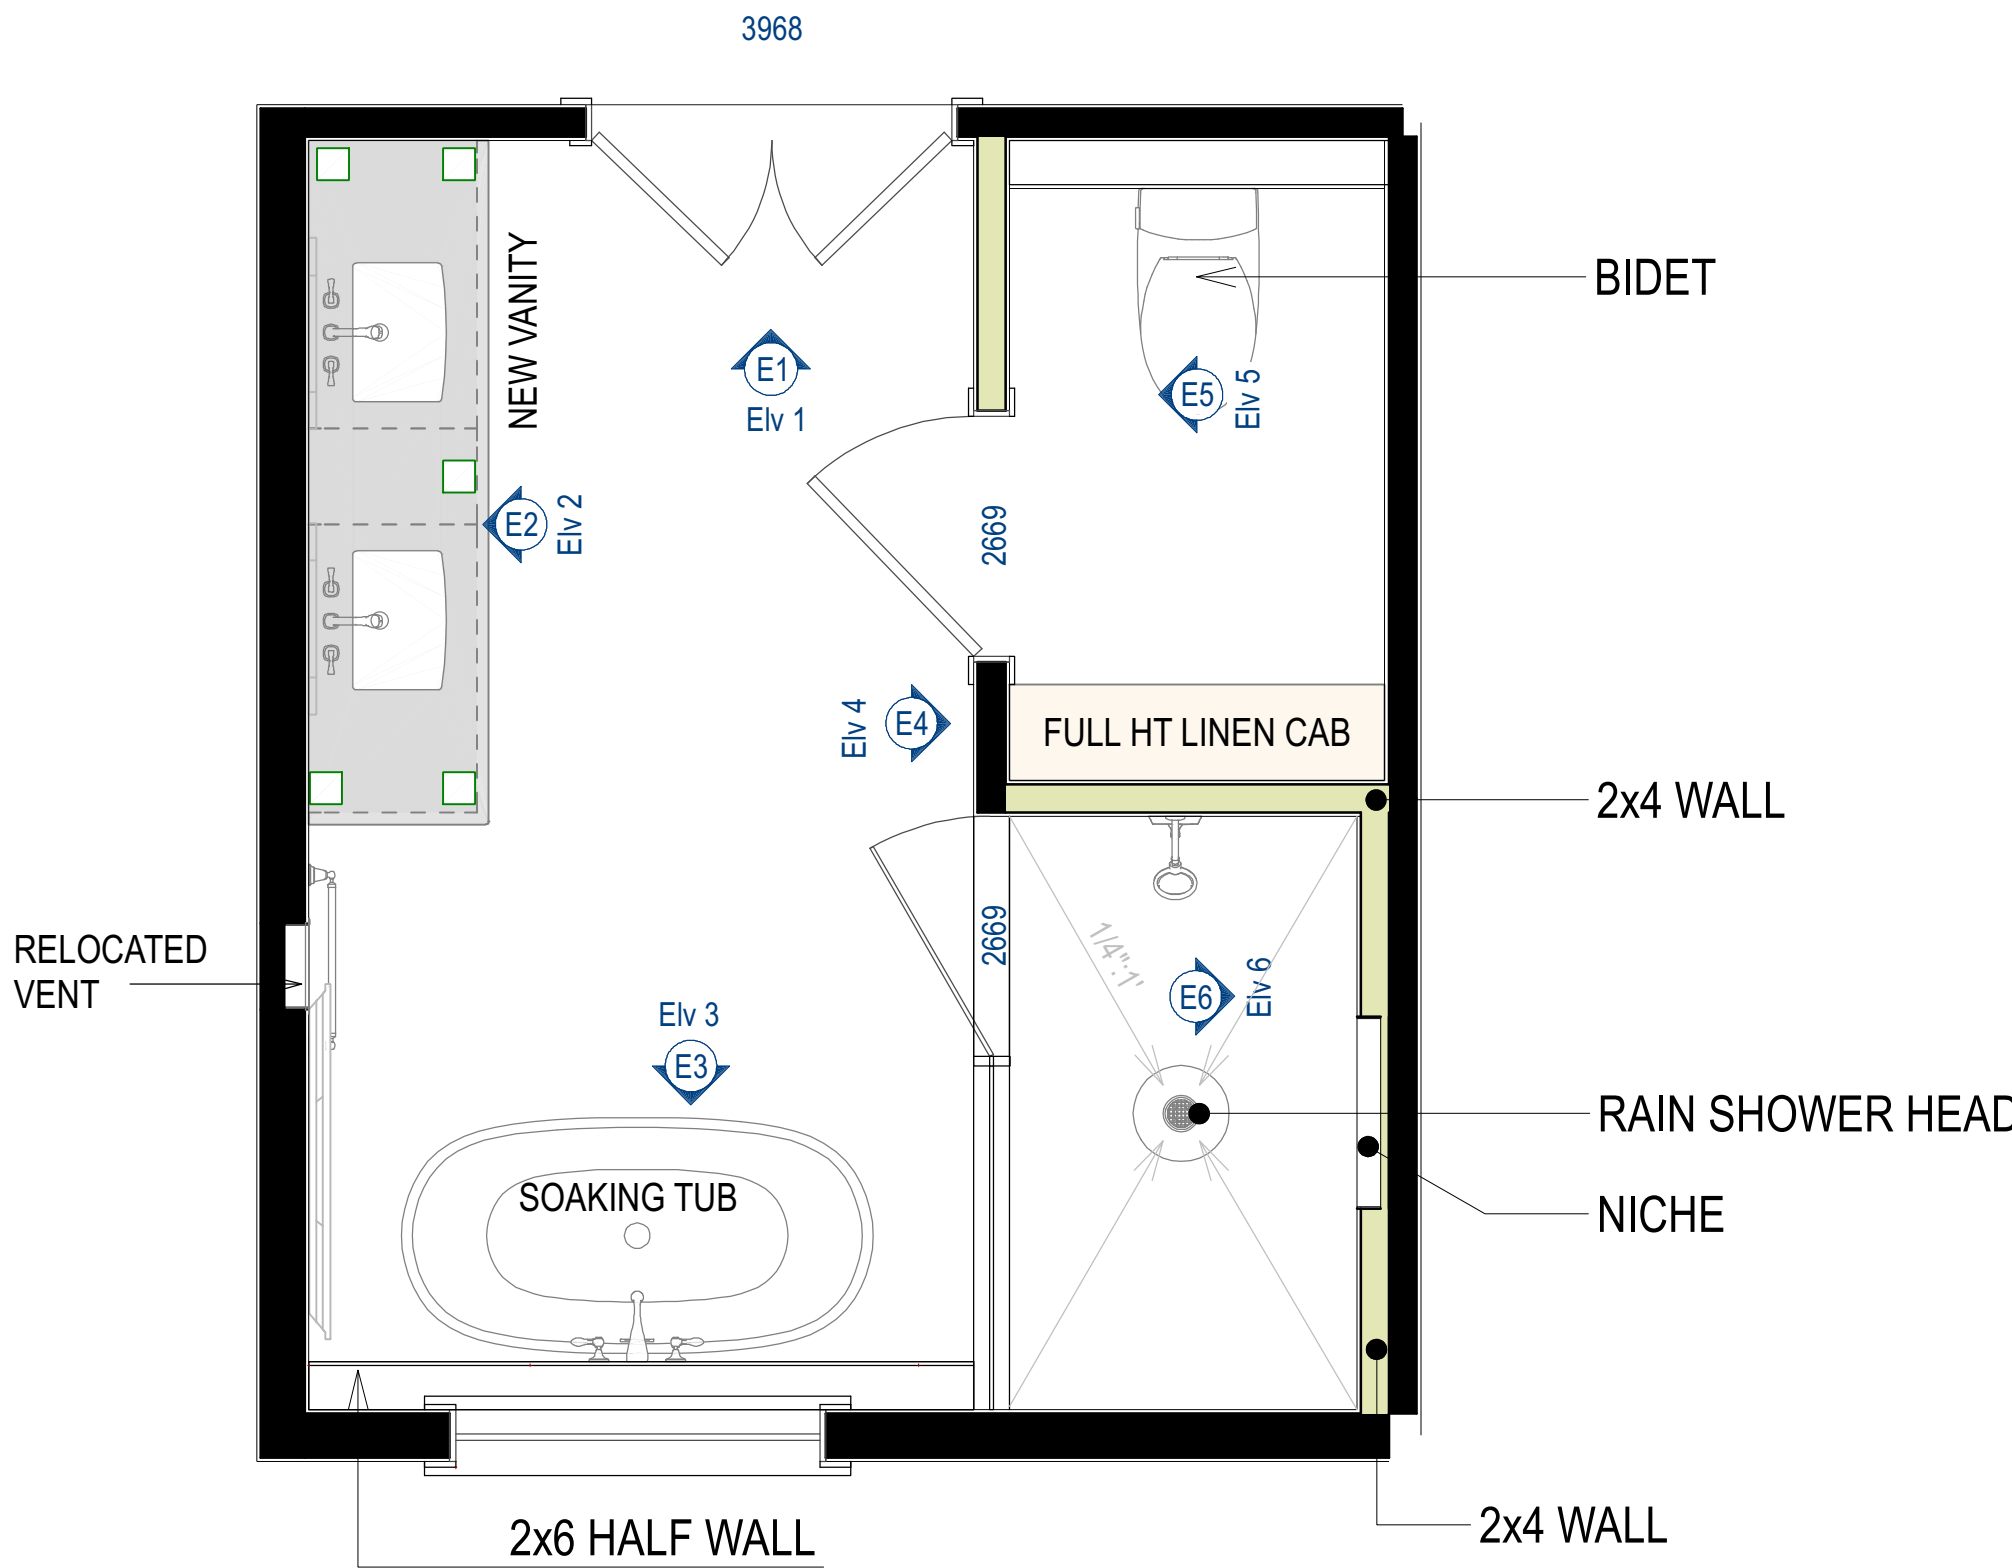


PROPOSED FLOOR PLAN  
SCALE TO 1/2" = 1' ON ARCH D



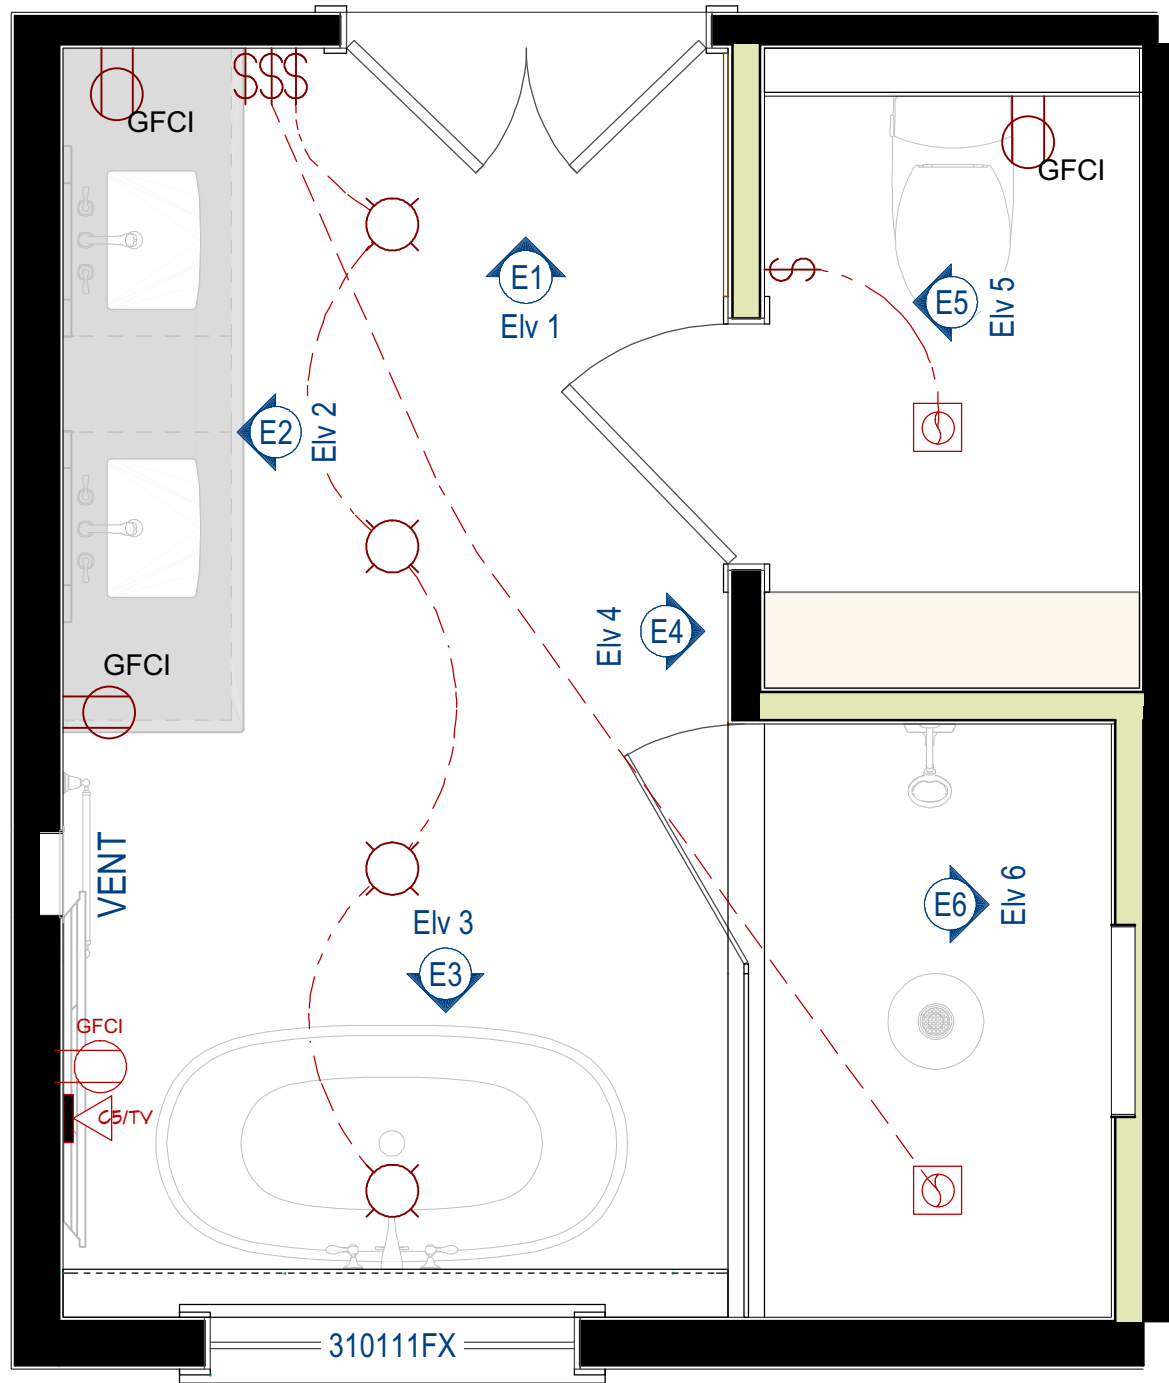


ELECTRICAL LEGEND	
2D SYMBOL	DESCRIPTION
	CAN LIGHT
	WALL SCNCE
	SWITCH
	RECESSED FAN+LIGHT COMBO
	GFCI DUPLEX RECEPTACLE
	CAT5 W/ TV

REFLECTED CEILING & ELECTRICAL PLAN  
SCALE TO 1/2" = 1' ON ARCH D

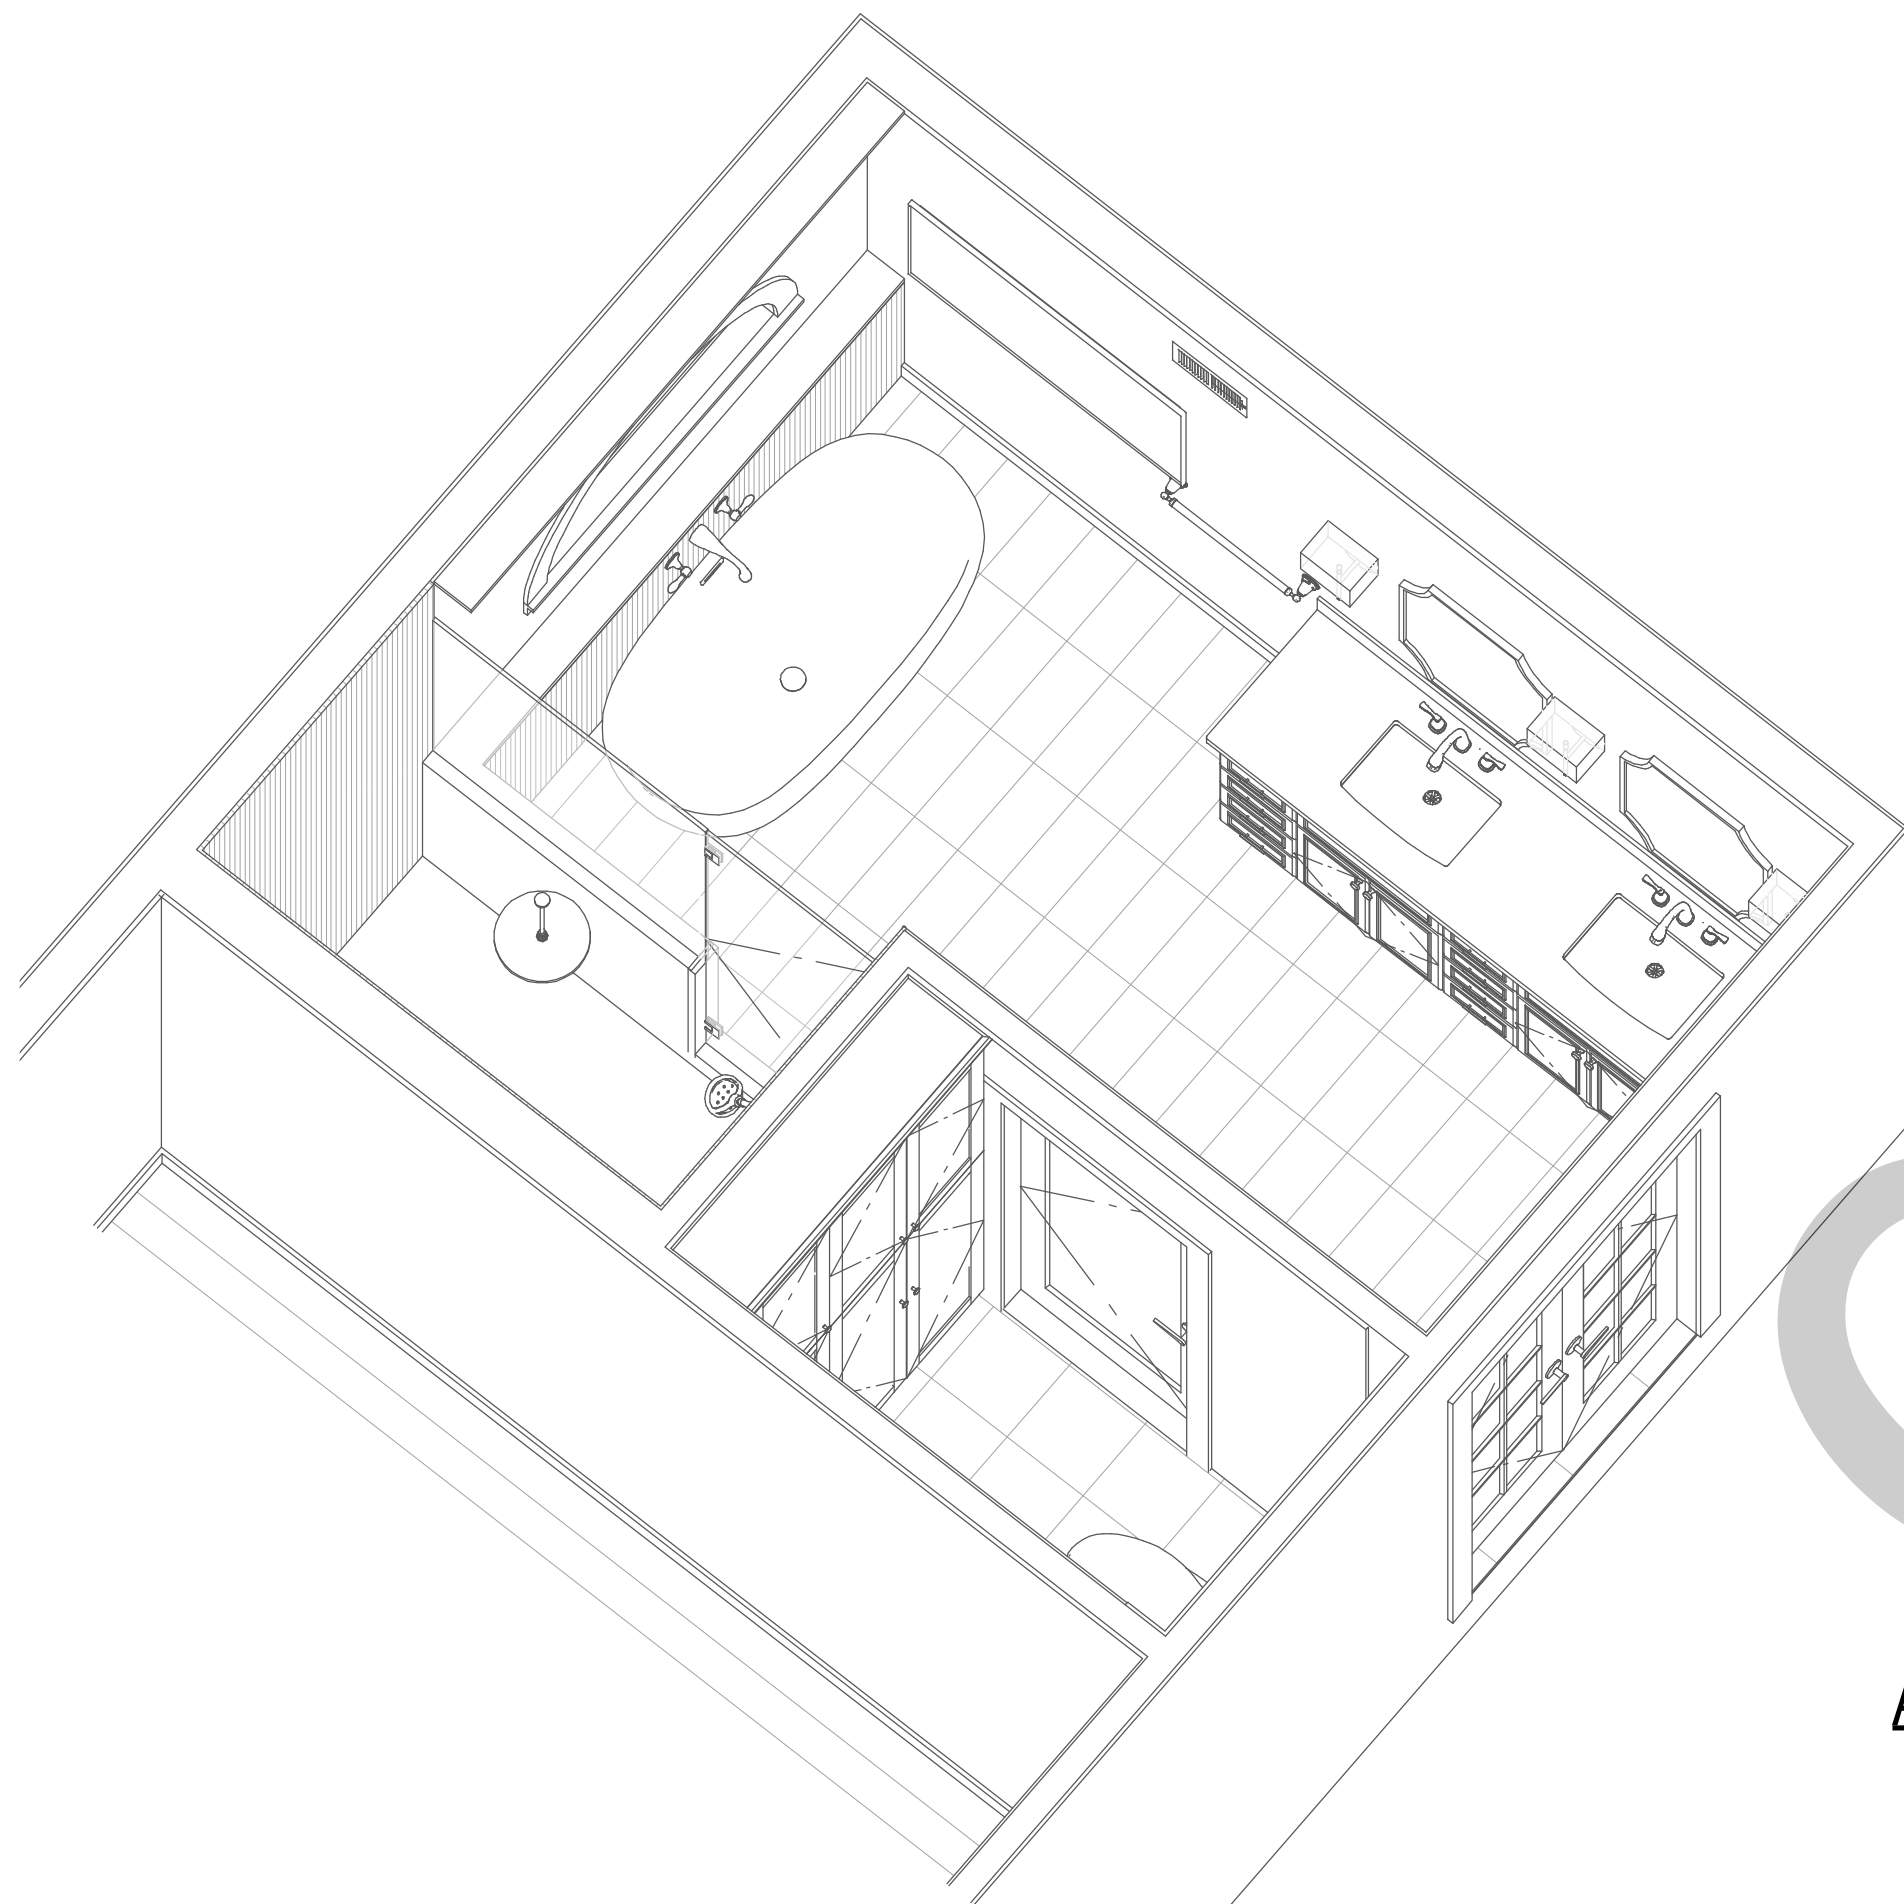

AXONOMETRIC FLOOR OVERVIEW  
1/2":1'

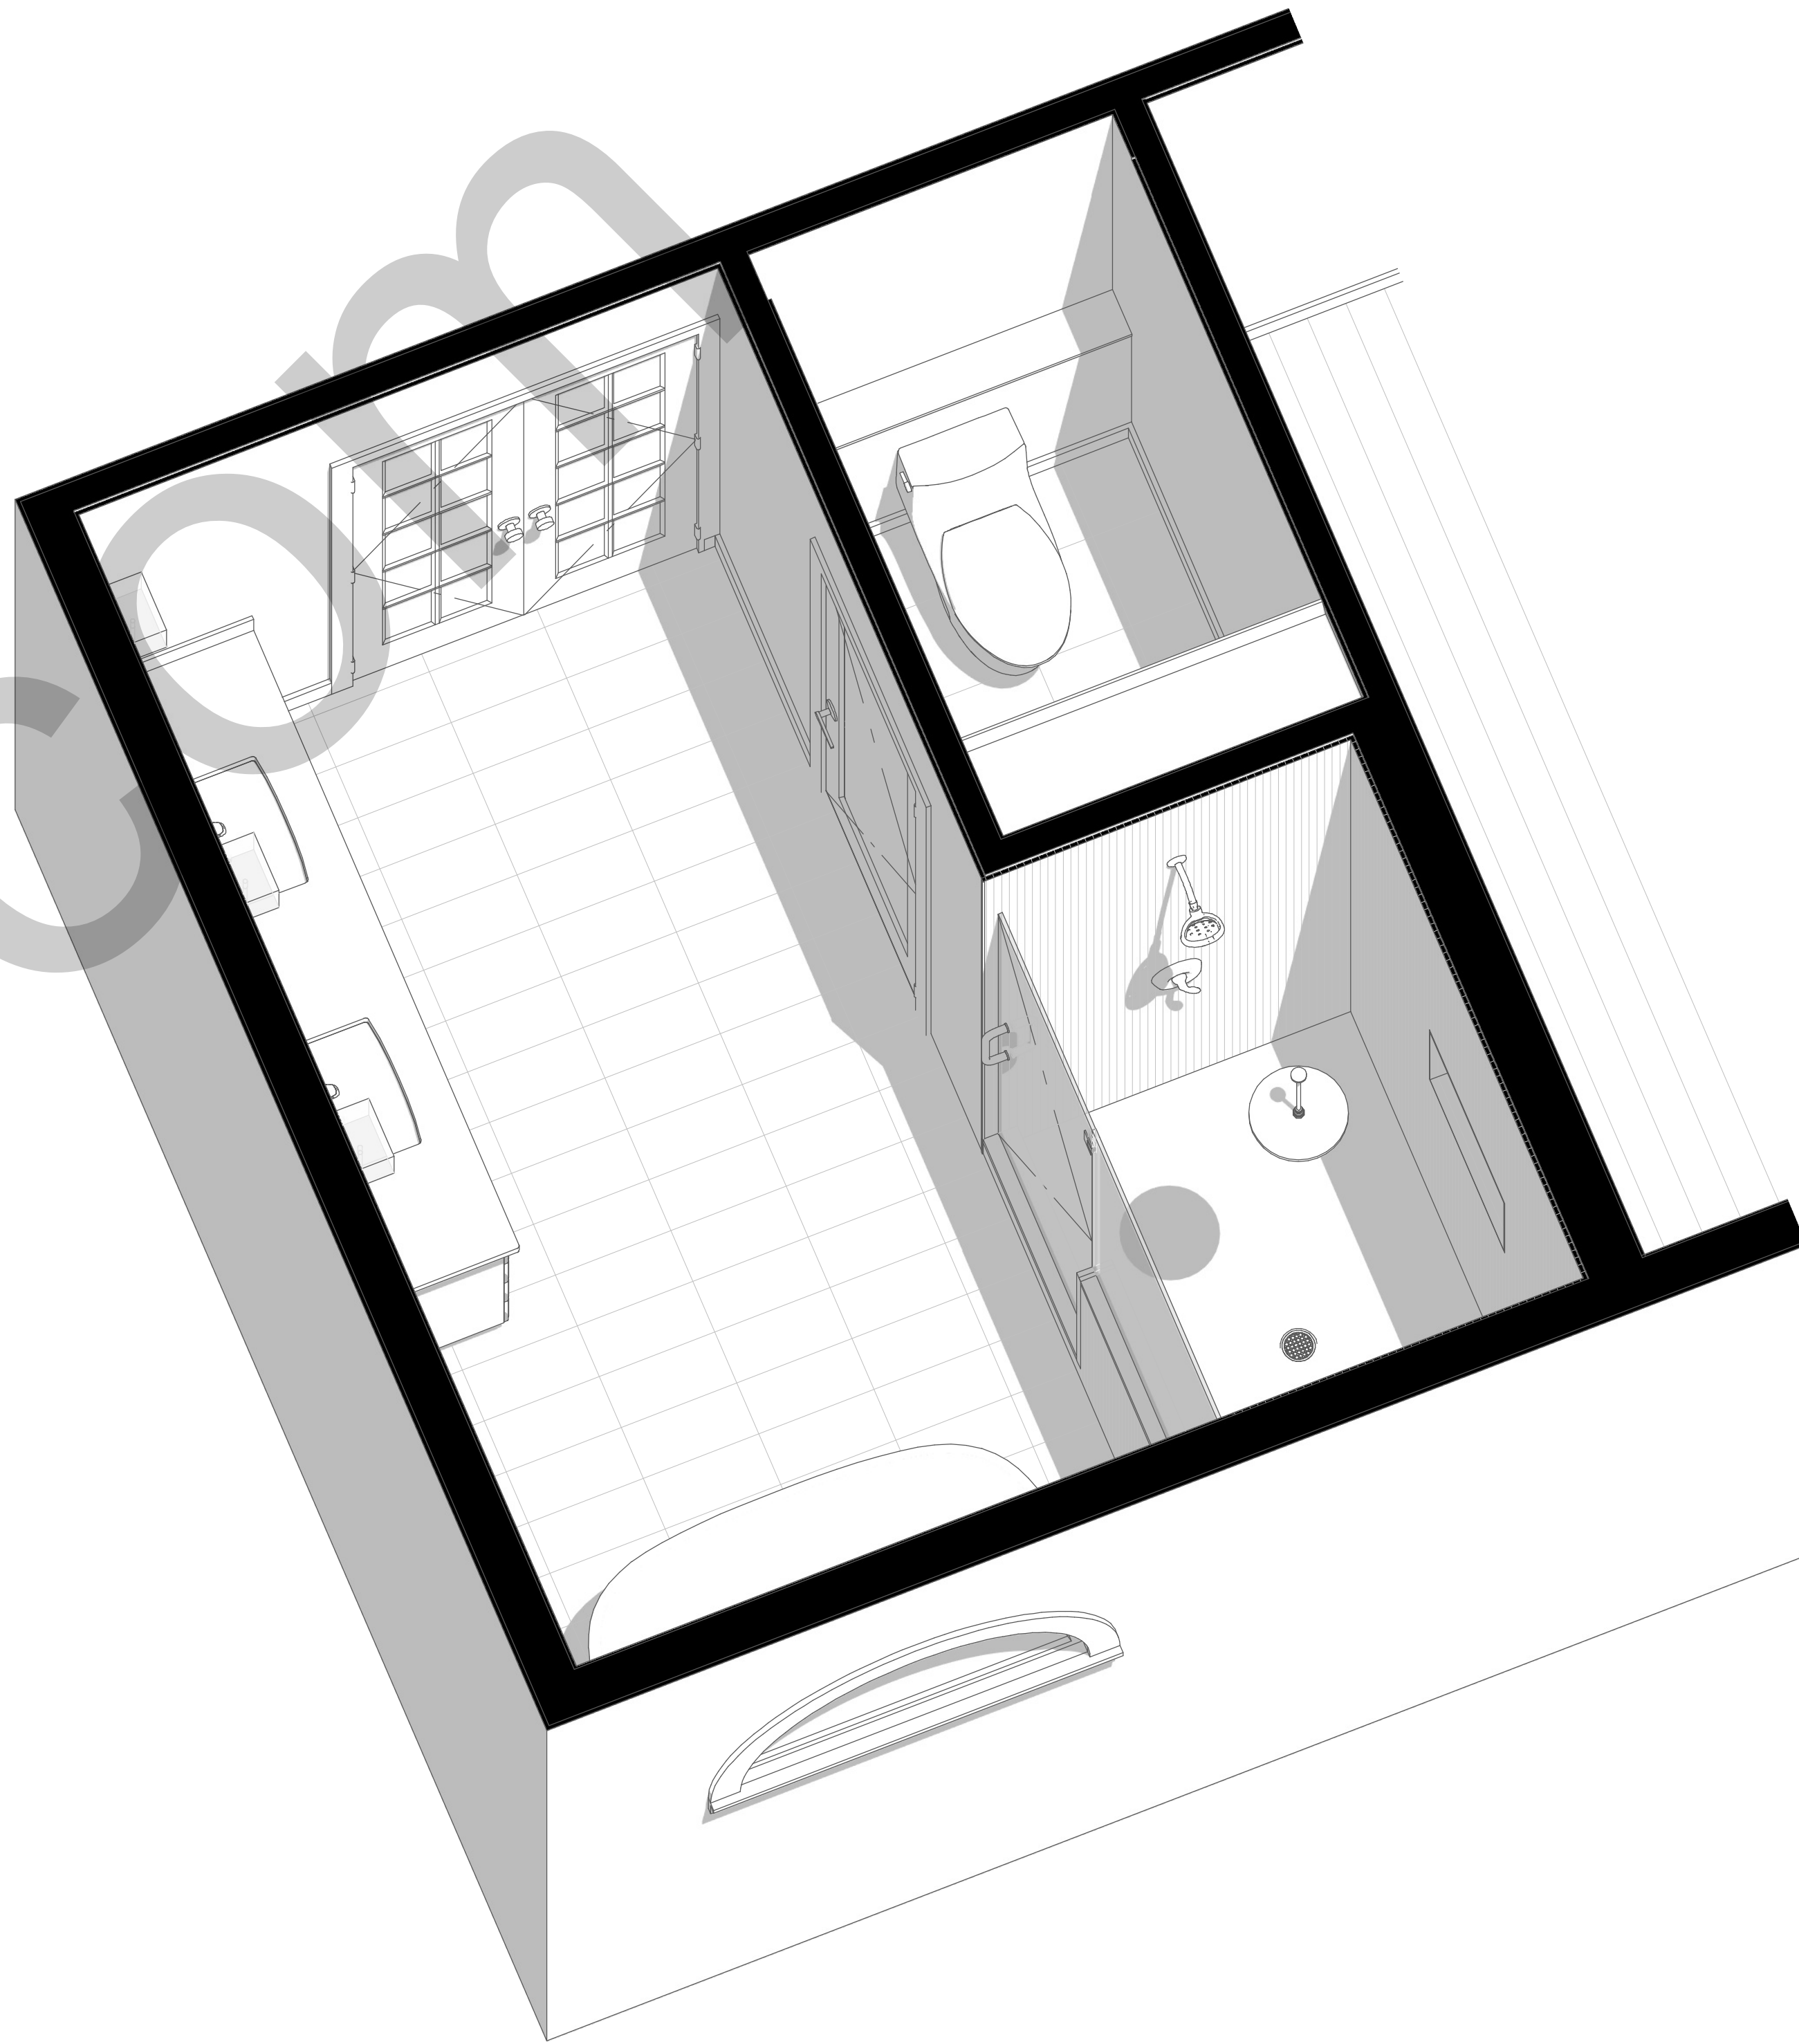

AXONOMETRIC FLOOR OVERVIEW  
NTS

SHEET #	DRAWINGS BY:	DATE:	PROJECT DESCRIPTION
3	Oz G.	2025.1.6	Bell Bathroom Remodeling Project


SHEET TITLE	SCALE	PAGE SIZE
Proposed Design Reflected Ceiling Plan	1/2" = 1'	ARCH D

REVISION TABLE			
NUMBER	DATE	REVISED BY	DESCRIPTION


COPYRIGHT  
All rights reserved. These drawings, plans and specifications and the copyright are the property of <name removed> © and must not be used, reproduced or copied wholly or in part without the written permission of <name removed> ©




VERIFY CEILING HEIGHT AFTER FLOORING INSTALLATION

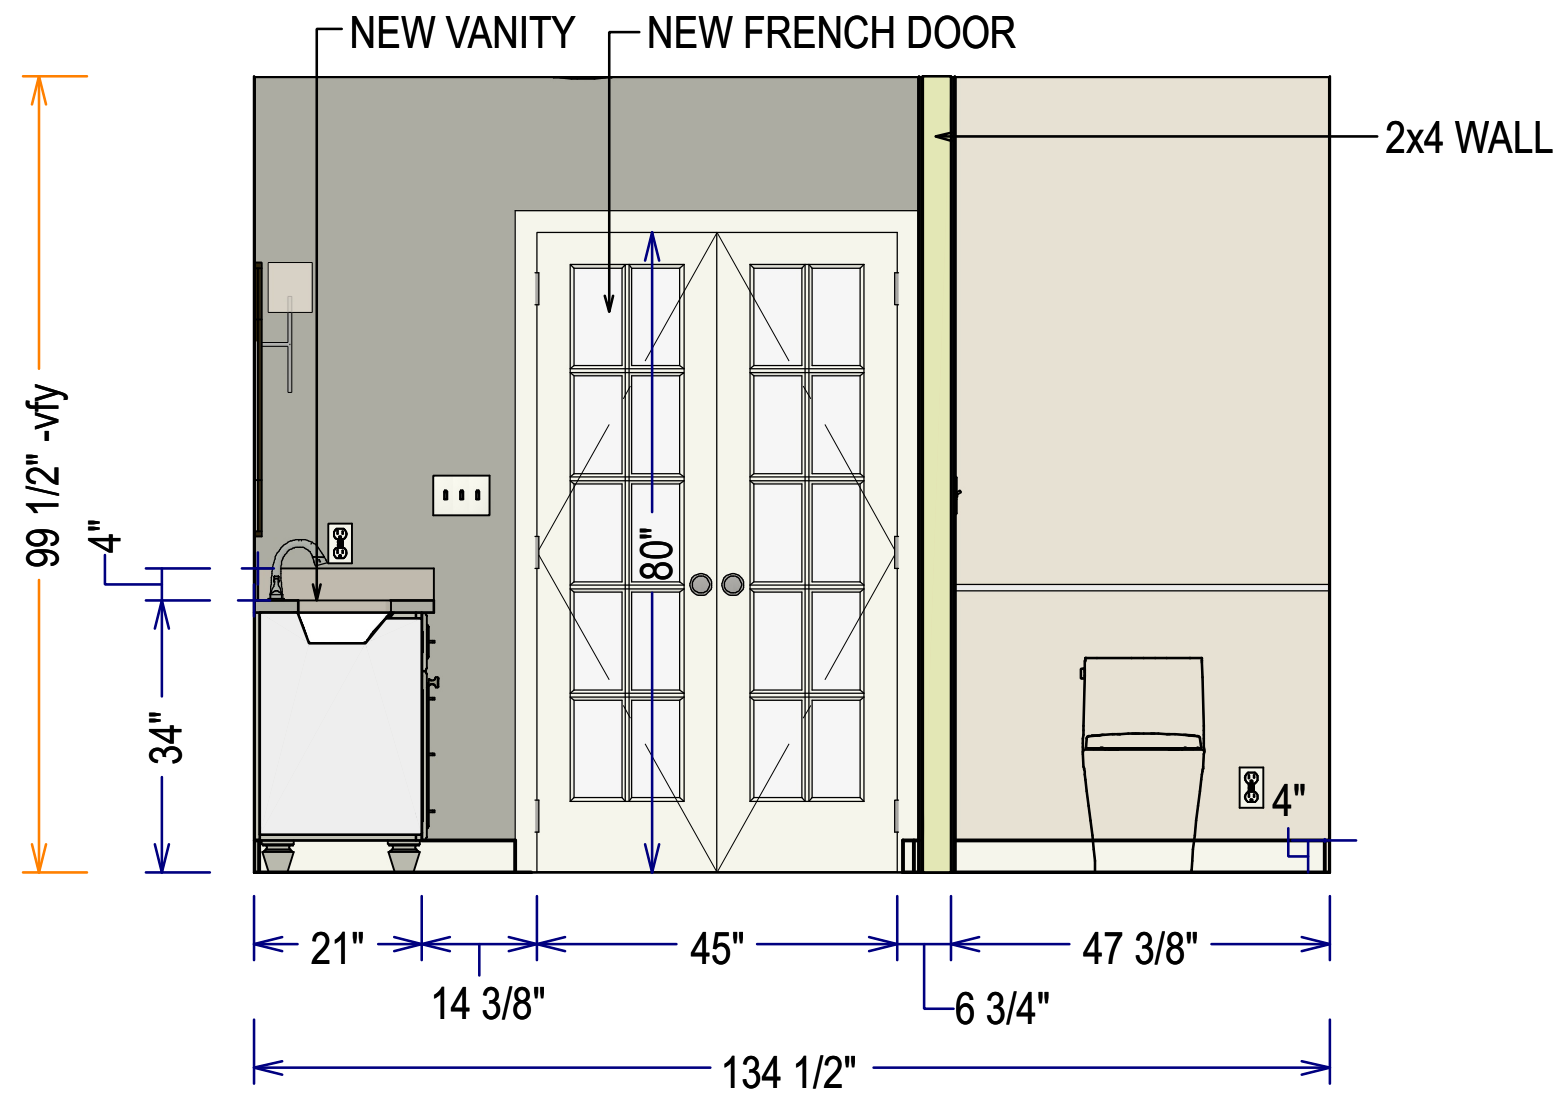


ELEVATION-1  
SCALE TO 1/2" = 1' ON ARCH D

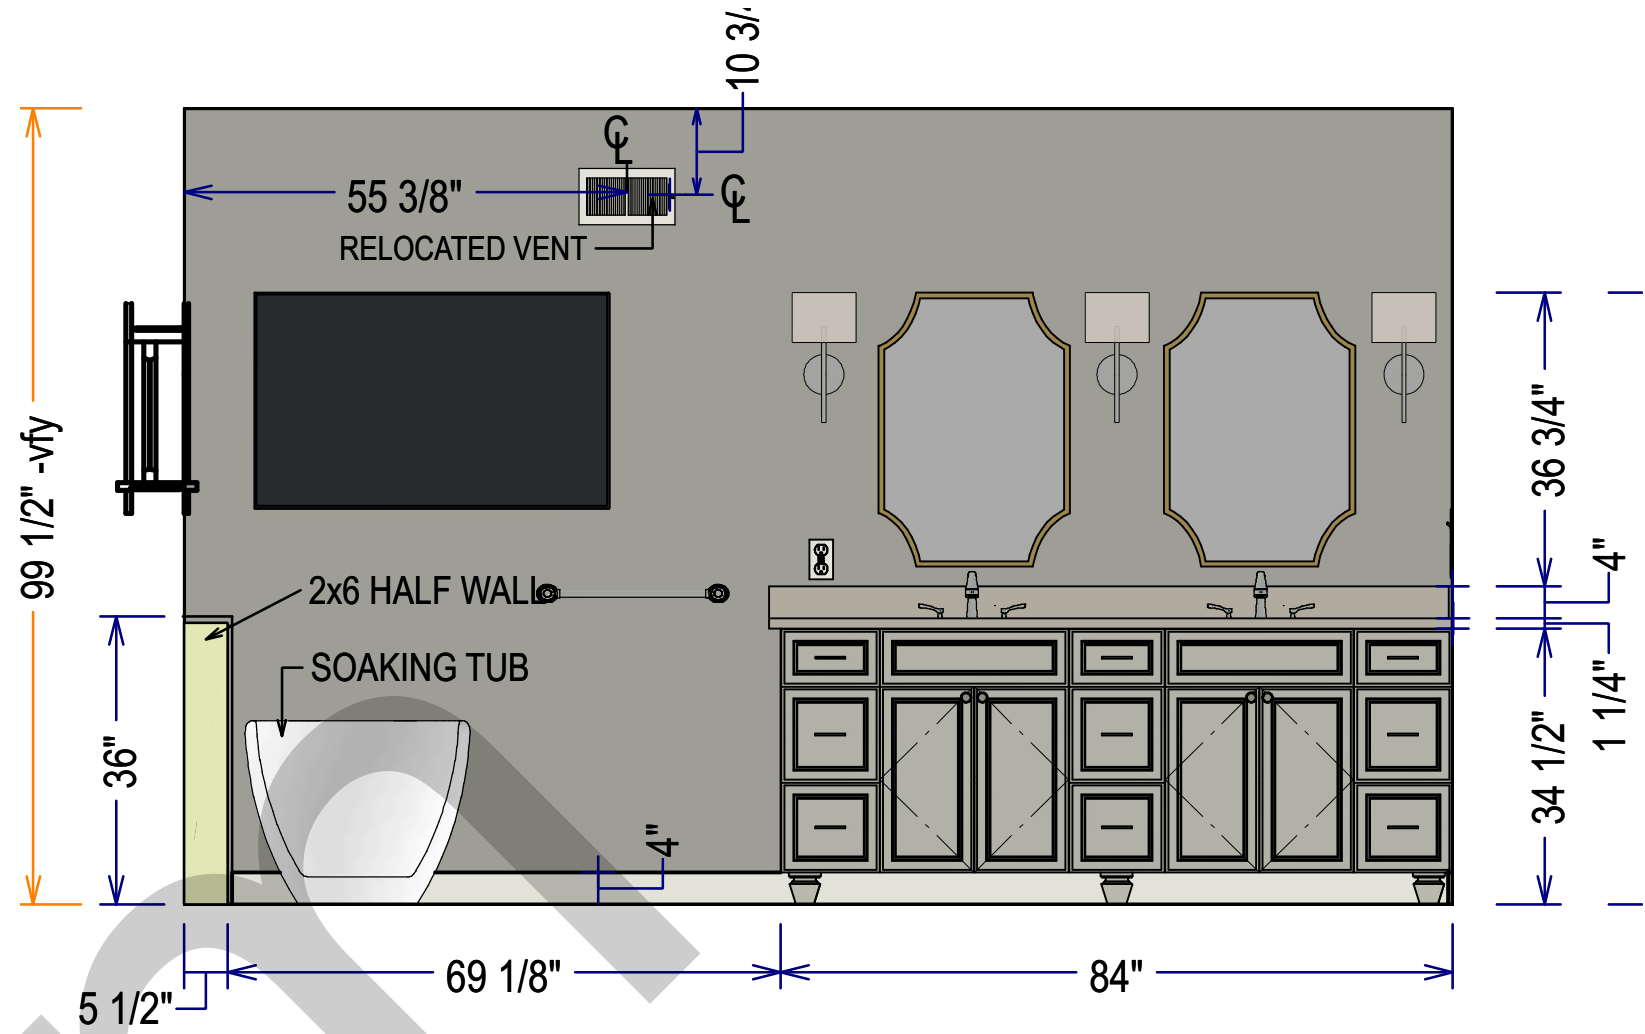


ELEVATION-2  
SCALE TO 1/2" = 1' ON ARCH D

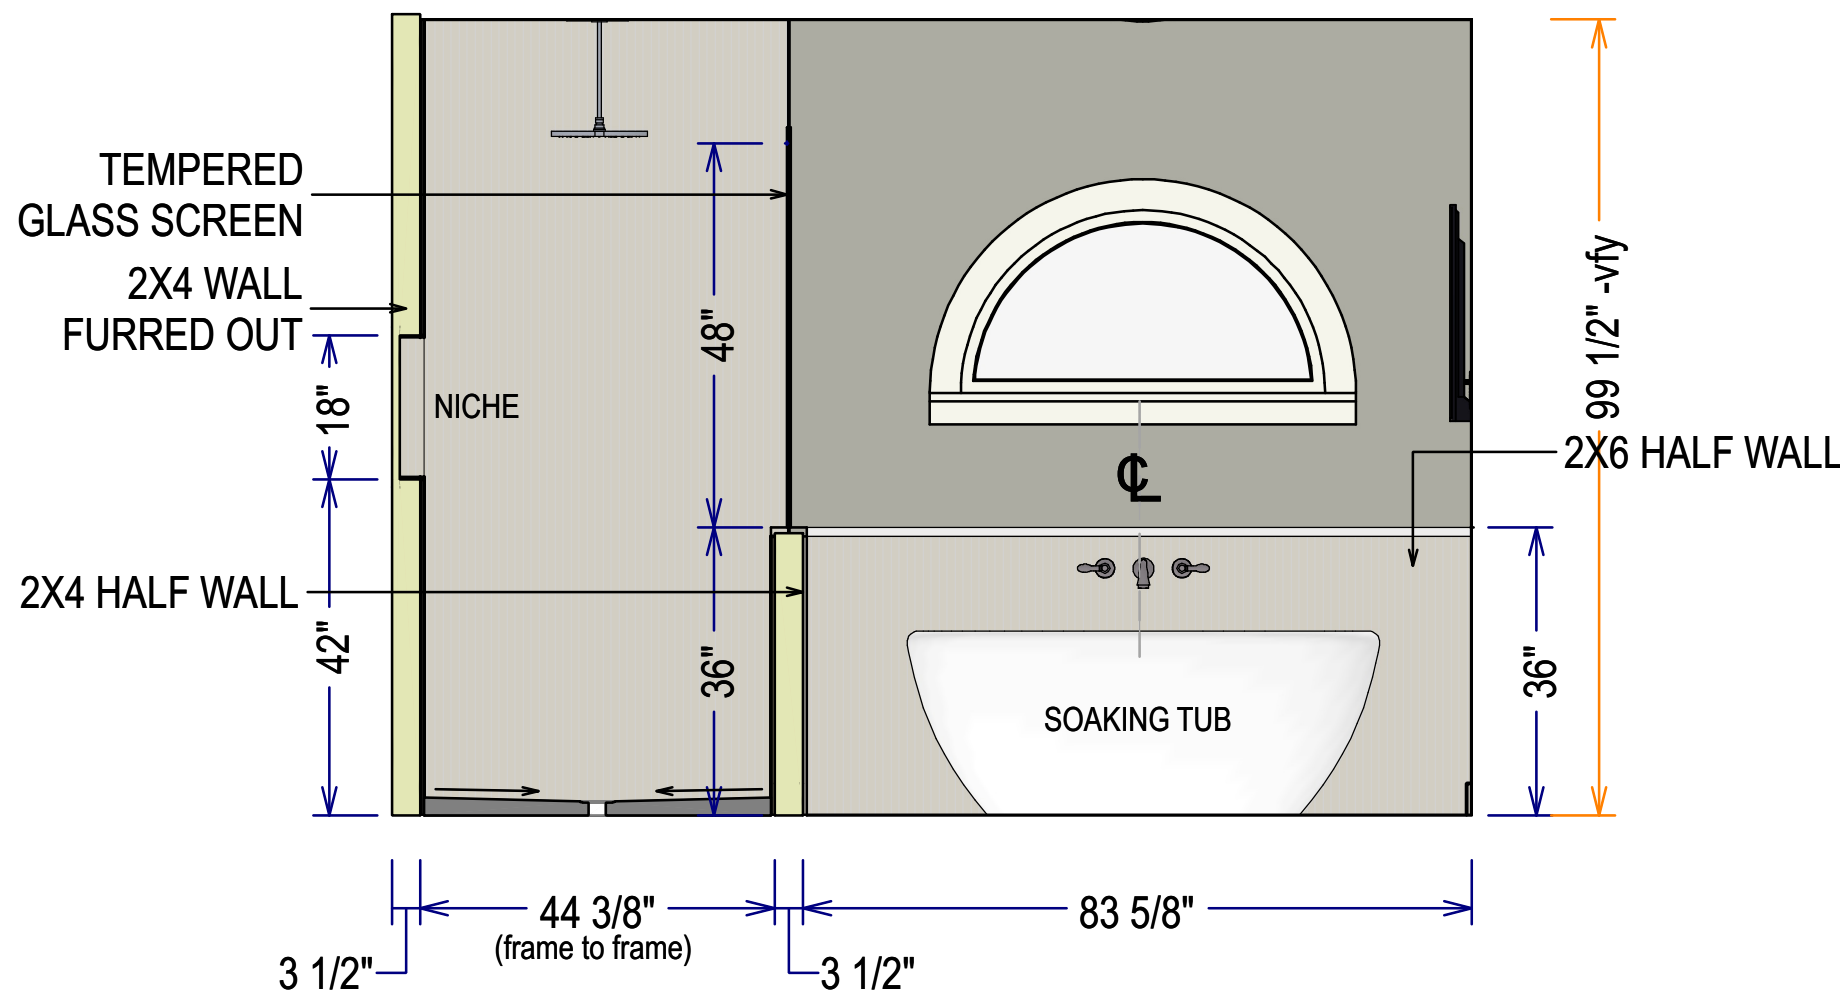


ELEVATION-3  
SCALE TO 1/2" = 1' ON ARCH D

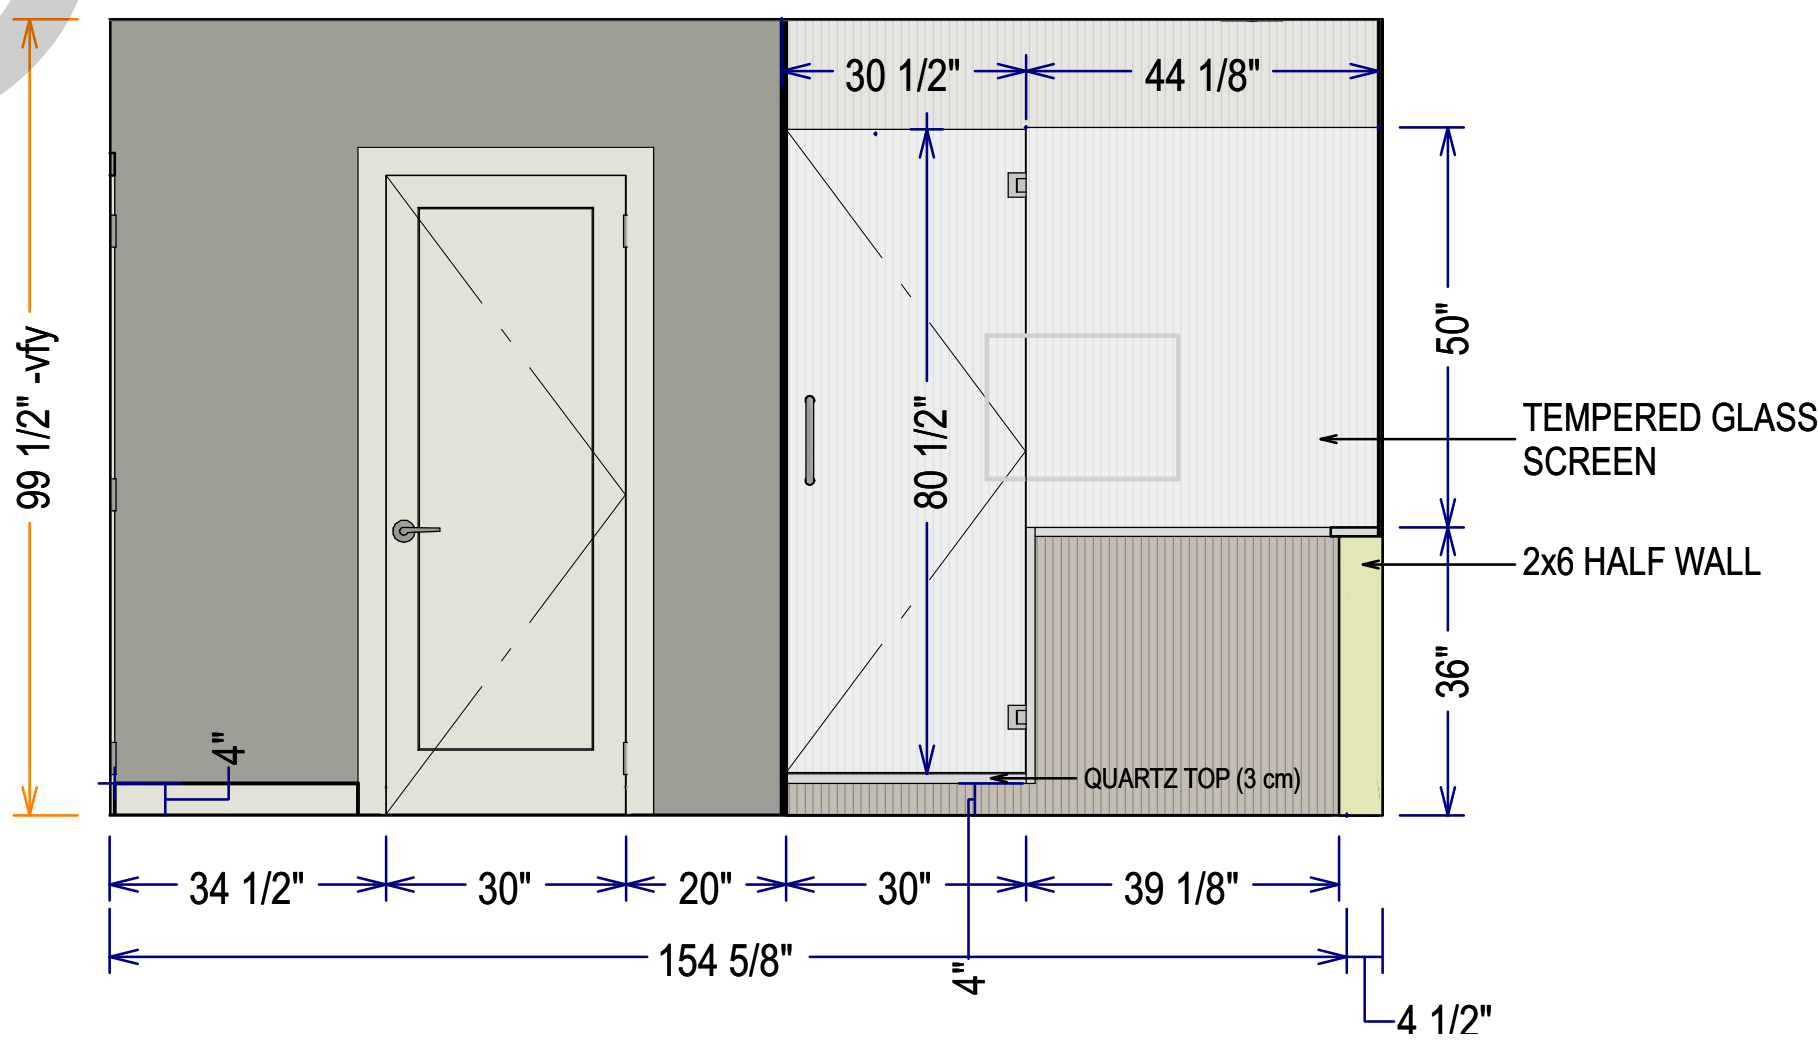


ELEVATION-4  
SCALE TO 1/2" = 1' ON ARCH D

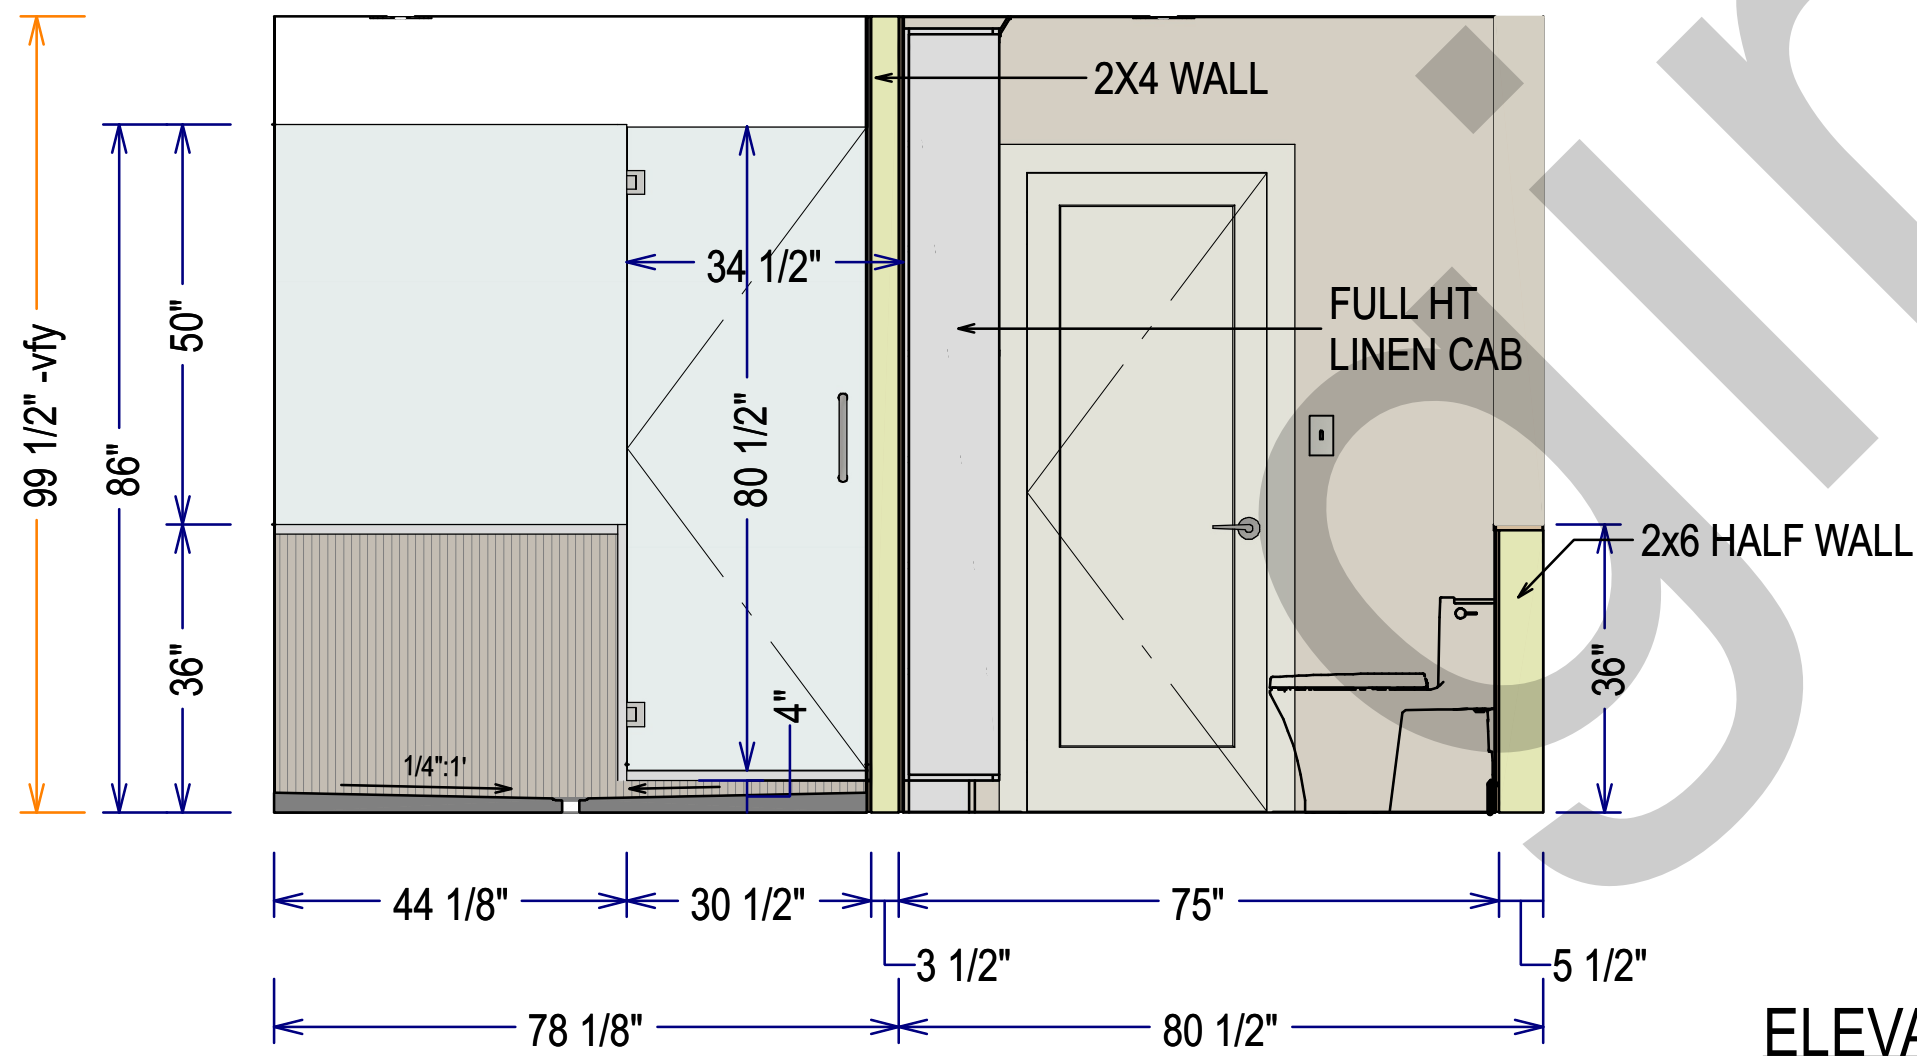

ELEVATION-5  
SCALE TO 1/2" = 1' ON ARCH D

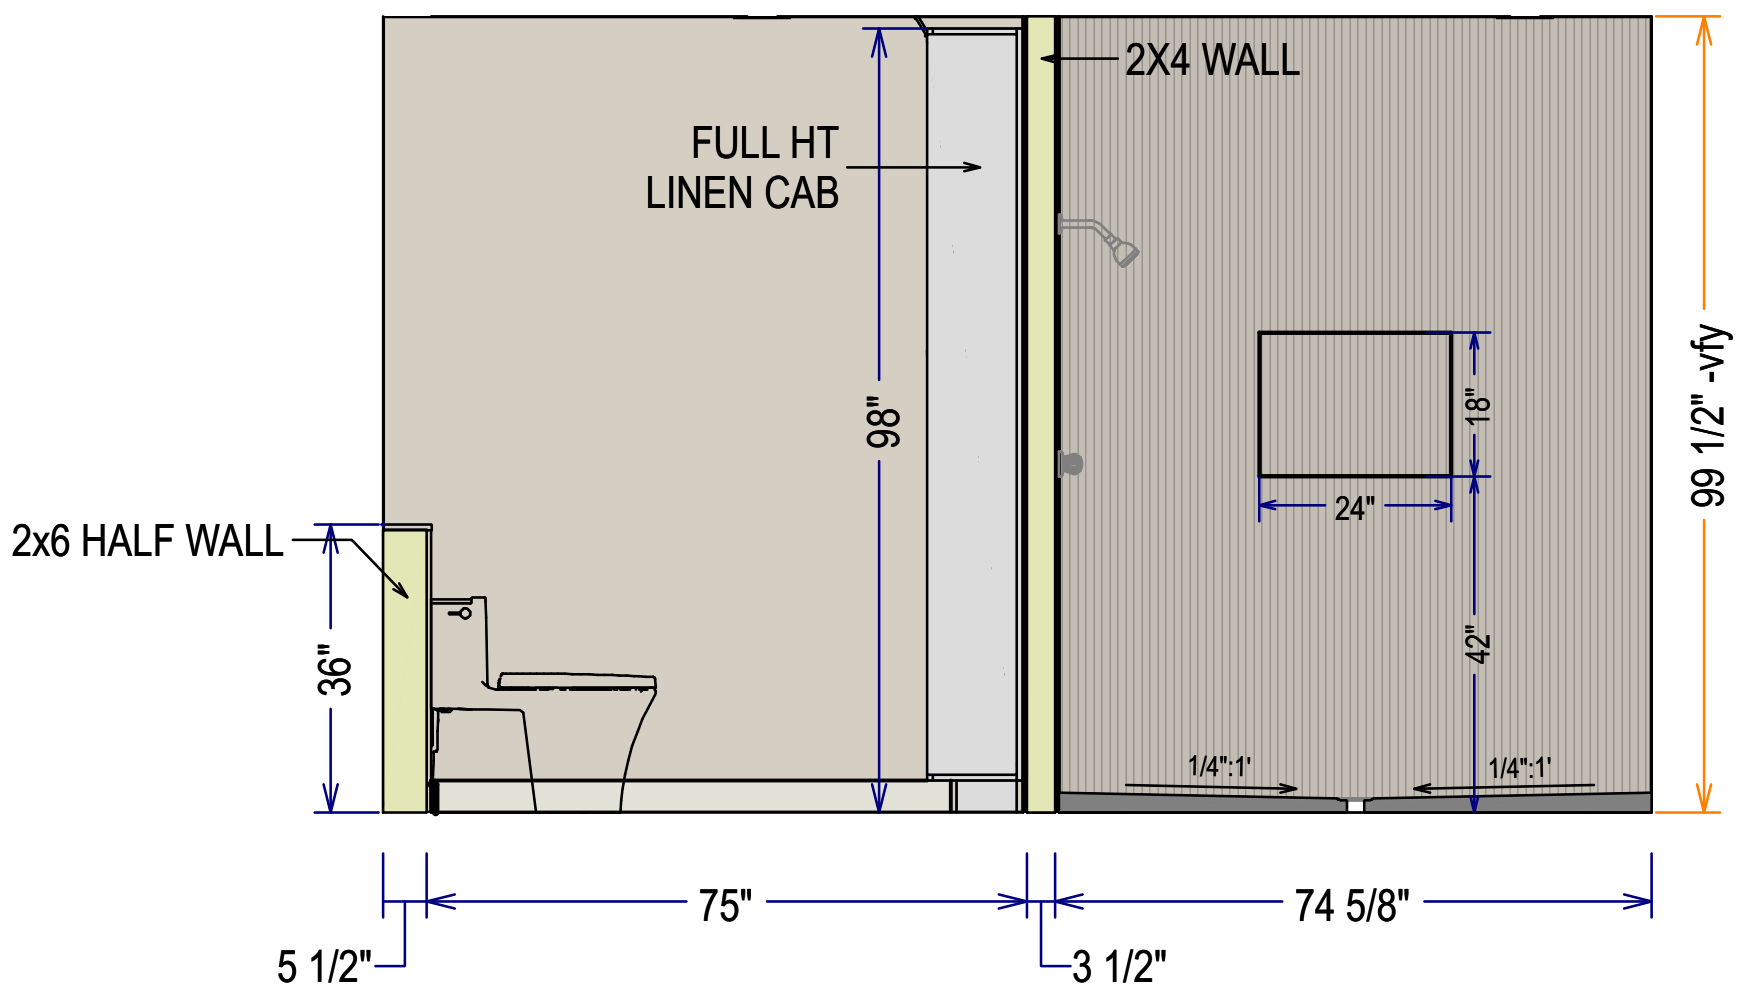

 ELEVATION-6  
SCALE TO 1/2" = 1' ON ARCH D



SHEET #	DRAWINGS BY:	DATE:
4	Oz G.	2025.1.6

PROJECT DESCRIPTION
Bell Bathroom Remodeling Project

SHEET TITLE	SCALE	PAGE SIZE
Wall Elevations	1/2" = 1'	ARCH D

REVISION TABLE			
NUMBER	DATE	REVISED BY	DESCRIPTION

COPYRIGHT All rights reserved. These drawings, plans and specifications and the copyright are the property of <name removed> © and must not be used, reproduced or copied wholly or in part without the written permission of <name removed> ©
---





Vanity Doors&Drawers: Fabuwood Imperio, Color: Nickel  
Vanity Legs: Fabuwood Furniture Style Legs (Vera)



Ulric Decorative Bathroom Vanity Mirror  
by Signature Hardware



Possini Euro Favreau  
16 1/4" High Brushed Nickel Wall Sconce



FLOOR TILES: Kenridge Chevron Gray 24x48  
Wood Look Matte Porcelain Tile



Drawer Pulls: Top Knobs TK812BSN Serene Collection 3-3/4"



Door Knobs: Top Knobs TK880BSN Devon Collection 1-1/4



Fantasy Brown Quartzite Countertop and Backsplash



Wall Color: Sherwin Williams  
SW 9553 Allegory



Vanity Art 29.5-in x 59-in White/Polished Chrome Acrylic Oval  
Freestanding Soaking Bathtub with Drain (Center Drain)



Tube Faucet: Delta T3576LF-WL  
Stryke Faucet



Shower Wall Tiles: Kenridge Ribbon Gray  
24x48 Wood Look Matte Porcelain Tile .



Shower Floor Tiles: Hampton Carrara  
Hex Marble Mosaic Tile - 2 x 2 in.



Rain Showerhead:  
Delta Faucet RP72568SS



Shower Head: Lahara Monitor 17 Solid  
Forged Brass Shower Trim



Kohler Veil K-1381-0  
One-piece elongated toilet

SHEET #	DRAWINGS BY:	DATE:
5	Oz G.	2025.1.6

PROJECT DESCRIPTION
Bell Bathroom Remodeling Project

SHEET TITLE	SCALE	PAGE SIZE
Project Specifications		ARCH D

REVISION TABLE			
NUMBER	DATE	REVISED BY	DESCRIPTION

<p><b>COPYRIGHT</b> All rights reserved. These drawings, plans and specifications and the copyright are the property of &lt;name removed&gt; © and must not be used, reproduced or copied wholly or in part without the written permission of &lt;name removed&gt; y©</p>	
---	--





render1

SHEET #			DRAWINGS BY:		DATE:	PROJECT DESCRIPTION		SHEET TITLE		SCALE	PAGE SIZE	REVISION TABLE				COPYRIGHT All rights reserved. These drawings, plans and specifications and the copyright are the property of <name removed> © and must not be used, reproduced or copied wholly or in part without the written permission of <name removed> y©	
6			Oz G.		2025.1.6	Bell Bathroom Remodeling Project		Rendering			ARCH D	NUMBER	DATE	REVISED BY	DESCRIPTION		





render2

SHEET #	DRAWINGS BY:	DATE:	PROJECT DESCRIPTION	SHEET TITLE	SCALE	PAGE SIZE	REVISION TABLE				COPYRIGHT All rights reserved. These drawings, plans and specifications and the copyright are the property of <name removed> © and must not be used, reproduced or copied wholly or in part without the written permission of <name removed>y ©	
7	Oz G.	2025.1.6	Bell Bathroom Remodeling Project	Rendering		ARCH D	NUMBER	DATE	REVISED BY	DESCRIPTION		





render3

SHEET #	DRAWINGS BY:	DATE:	PROJECT DESCRIPTION	SHEET TITLE	SCALE	PAGE SIZE
8	Oz G.	2025.1.6	Bell Bathroom Remodeling Project	Rendering	ARCH D	

REVISION TABLE			
NUMBER	DATE	REVISED BY	DESCRIPTION

COPYRIGHT  
All rights reserved. These drawings, plans and specifications and the copyright are the property of <name removed> © and must not be used, reproduced or copied wholly or in part without the written permission of <name removed> y ©





render4

SHEET #	DRAWINGS BY:	DATE:	PROJECT DESCRIPTION	SHEET TITLE	SCALE	PAGE SIZE	REVISION TABLE				COPYRIGHT All rights reserved. These drawings, plans and specifications and the copyright are the property of <name removed> © and must not be used, reproduced or copied wholly or in part without the written permission of <name removed>y ©	
9	Oz G.	2025.1.6	Bell Bathroom Remodeling Project	Rendering		ARCH D	NUMBER	DATE	REVISED BY	DESCRIPTION		





SHEET #	DRAWINGS BY:	DATE:	PROJECT DESCRIPTION	SHEET TITLE	SCALE	PAGE SIZE	
10	Oz G.	2025.1.6	Bell Bathroom Remodeling Project	Rendering		ARCH D	

REVISION TABLE			
NUMBER	DATE	REVISED BY	DESCRIPTION

COPYRIGHT

All rights reserved. These drawings, plans and specifications and the copyright are the property of <name removed> © and must not be used, reproduced or copied wholly or in part without the written permission of <name removed> y ©





render7

SHEET #	DRAWINGS BY:	DATE:	PROJECT DESCRIPTION	SHEET TITLE	SCALE	PAGE SIZE	REVISION TABLE				COPYRIGHT All rights reserved. These drawings, plans and specifications and the copyright are the property of <name removed> © and must not be used, reproduced or copied wholly or in part without the written permission of <name removed>y ©	
11	Oz G.	2025.1.6	Bell Bathroom Remodeling Project	Rendering		ARCH D	NUMBER	DATE	REVISED BY	DESCRIPTION		